



"PROVISION OF MISSING FACILITIES FOR THE SHAIKH AYAZ UNIVERSITY SHIKARPUR"



ADMINISTRATION BLOCK VOLUME III TENDER DRAWINGS DEC, 2022

DESIGN BY



NEW VISION ENGINEERING CONSULTANT

HEAD OFFICE:



Office No.B-6 Second Floor Masood Arcade
IJP Road Islamabad.

Ph: +92-51-4848375, Fax: +92-51-4848375
Email: newvisionec@yahoo.com

REGIONAL OFFICE:

287-A Street # 6,
Cavalry Ground ,Lahore
Ph: +92-42-37250130

Sr.No	PROPOSED FACILITIES	Sr.No	PROPOSED FACILITIES	Sr.No	PROPOSED FACILITIES
1-	MAIN ENTRANCE	9B-	SCHOOL OF MANAGEMENT SCIENCES	24-	PARKING
2-	HERITAGE PARK	9C-	SCHOOL OF ARTS & HUMANITIES	25-	OVER HEAD WATER TANK
3-	ADMINISTRATION BLOCK	9D-	SCHOOL OF AGRI & VETERINARY SCIENCES	26-	TUBE WELL
4-	AUDITORIUM	10-	MALE TEACHER ACCOMMODATION	27-	BOYS HOSTEL FOR STUDENTS FUTURE BLOCKS
5-	LIBRARY	11-	BOYS HOSTEL FOR STUDENTS	28-	HOUSES FOR SENIOR FACULTY
6-	MASJID	12-	FEMALE HOSTEL FOR STUDENTS	29-	03 BED FLATS FOR SENIOR FACULTY
7-	MEDICAL CENTER	13-	FEMALE TEACHER ACCOMMODATION	30-	02 BED FLATS FOR FACULTY
7A-	BUSINESS & INNOVATION CENTER	14-	VC RESIDENCE	31-	PARK
7B-	BOOK SHOP & TUCK SHOPS	15-	SCHOOL	32-	SILICON VALLEY
7C-	CANTEEN	16-	GUEST HOUSE	33-	QUARTERS FOR JUNIOR STAFF
8-	GOLF COURSE WITH WATER BODY	17-	SECURITY & DISASTER MANAGEMENT	34-	BANKS
8A-	FITNESS CENTER	18-	PUBLIC TOILETS	35-	POLICE CHECK POST
8B-	CRICKET GROUND	19-	SITE FOR AGRICULTURE RESEARCH/ TREE GROVES	36-	WATCH TOWER
8C-	FOOTBALL GROUND	20-	SEWERAGE TREATMENT PLANT	37-	CLUB
8D-	SPORTS ARENA	21-	TRANSPORT SECTION	38-	SOLID WASTE MANAGEMENT
9-	SCHOOL OF NATURAL SCIENCE	22-	COMMERCIAL AREA		
9A-	SCHOOL OF ICT & MATHEMATICS	23-	SIDE ENTRANCES		

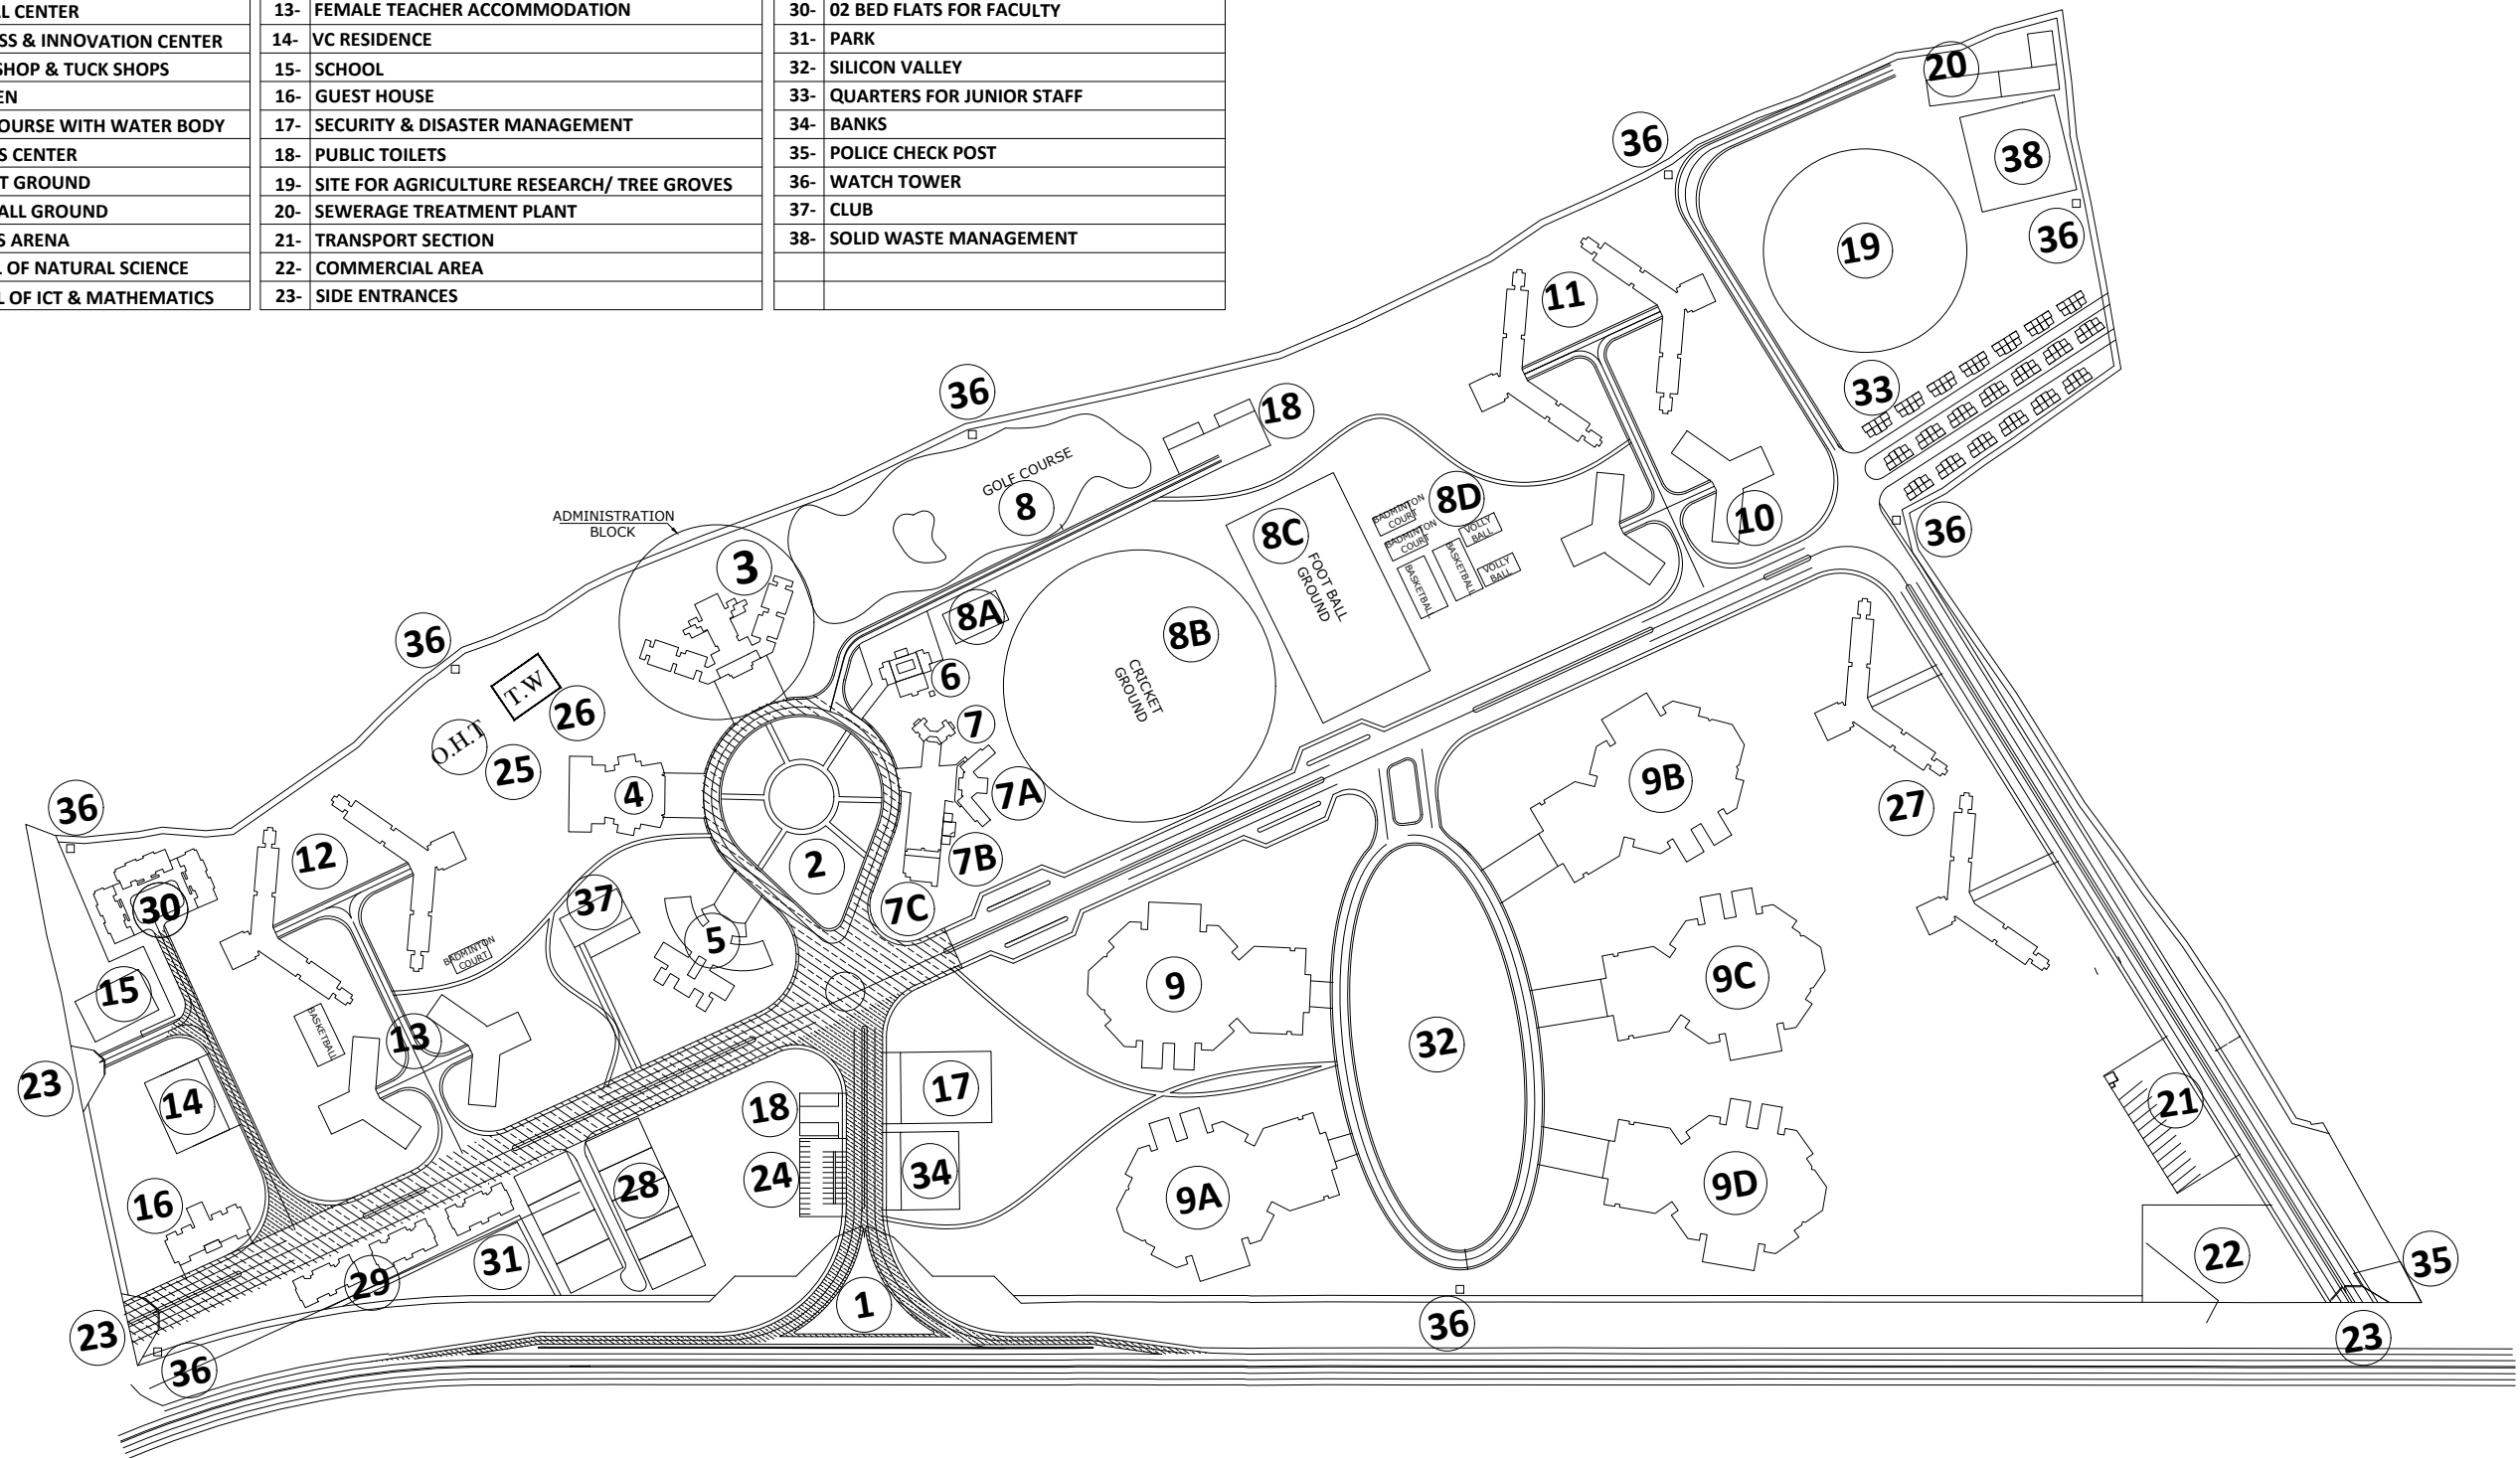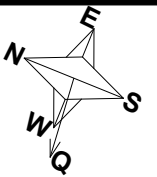

ADDITION & REVISION					
ADD/REV. NO.	DATE	DESCRIPTION	DES. BY	CHK. BY	APP. BY



NEW VISION ENGINEERING CONSULTANT
Head Office: Office No.B-6 Second Floor Masood Arcade
IJP Road Islamabad.
Ph: +92-51-4848375, Fax: +92-51-4848375
Email: newvisionec@yahoo.com
Regional Office: 287-A Street # 6, Cavalry Ground ,Lahore
Ph: +92-42-37250130

PROJECT:

"PROVISION OF MISSING FACILITIES FOR THE
SHAikh AYAZ UNIVERSITY SHIKARPUR"

TITLE:

ADMINISTRATION BLOCK

MASTER PLAN

CAD filename:

CLIENT:

THE SHAIKH AYAZ UNIVERSITY

DESIGNED BY:

AR. SALMAN

APPROVED BY:

S A

DATE :

AUGUST, 2022

DRAWN BY:

RANA ALI HAIDER


JOB NO.

SCALE:

N.T.S

DRG. NO.

MP-01

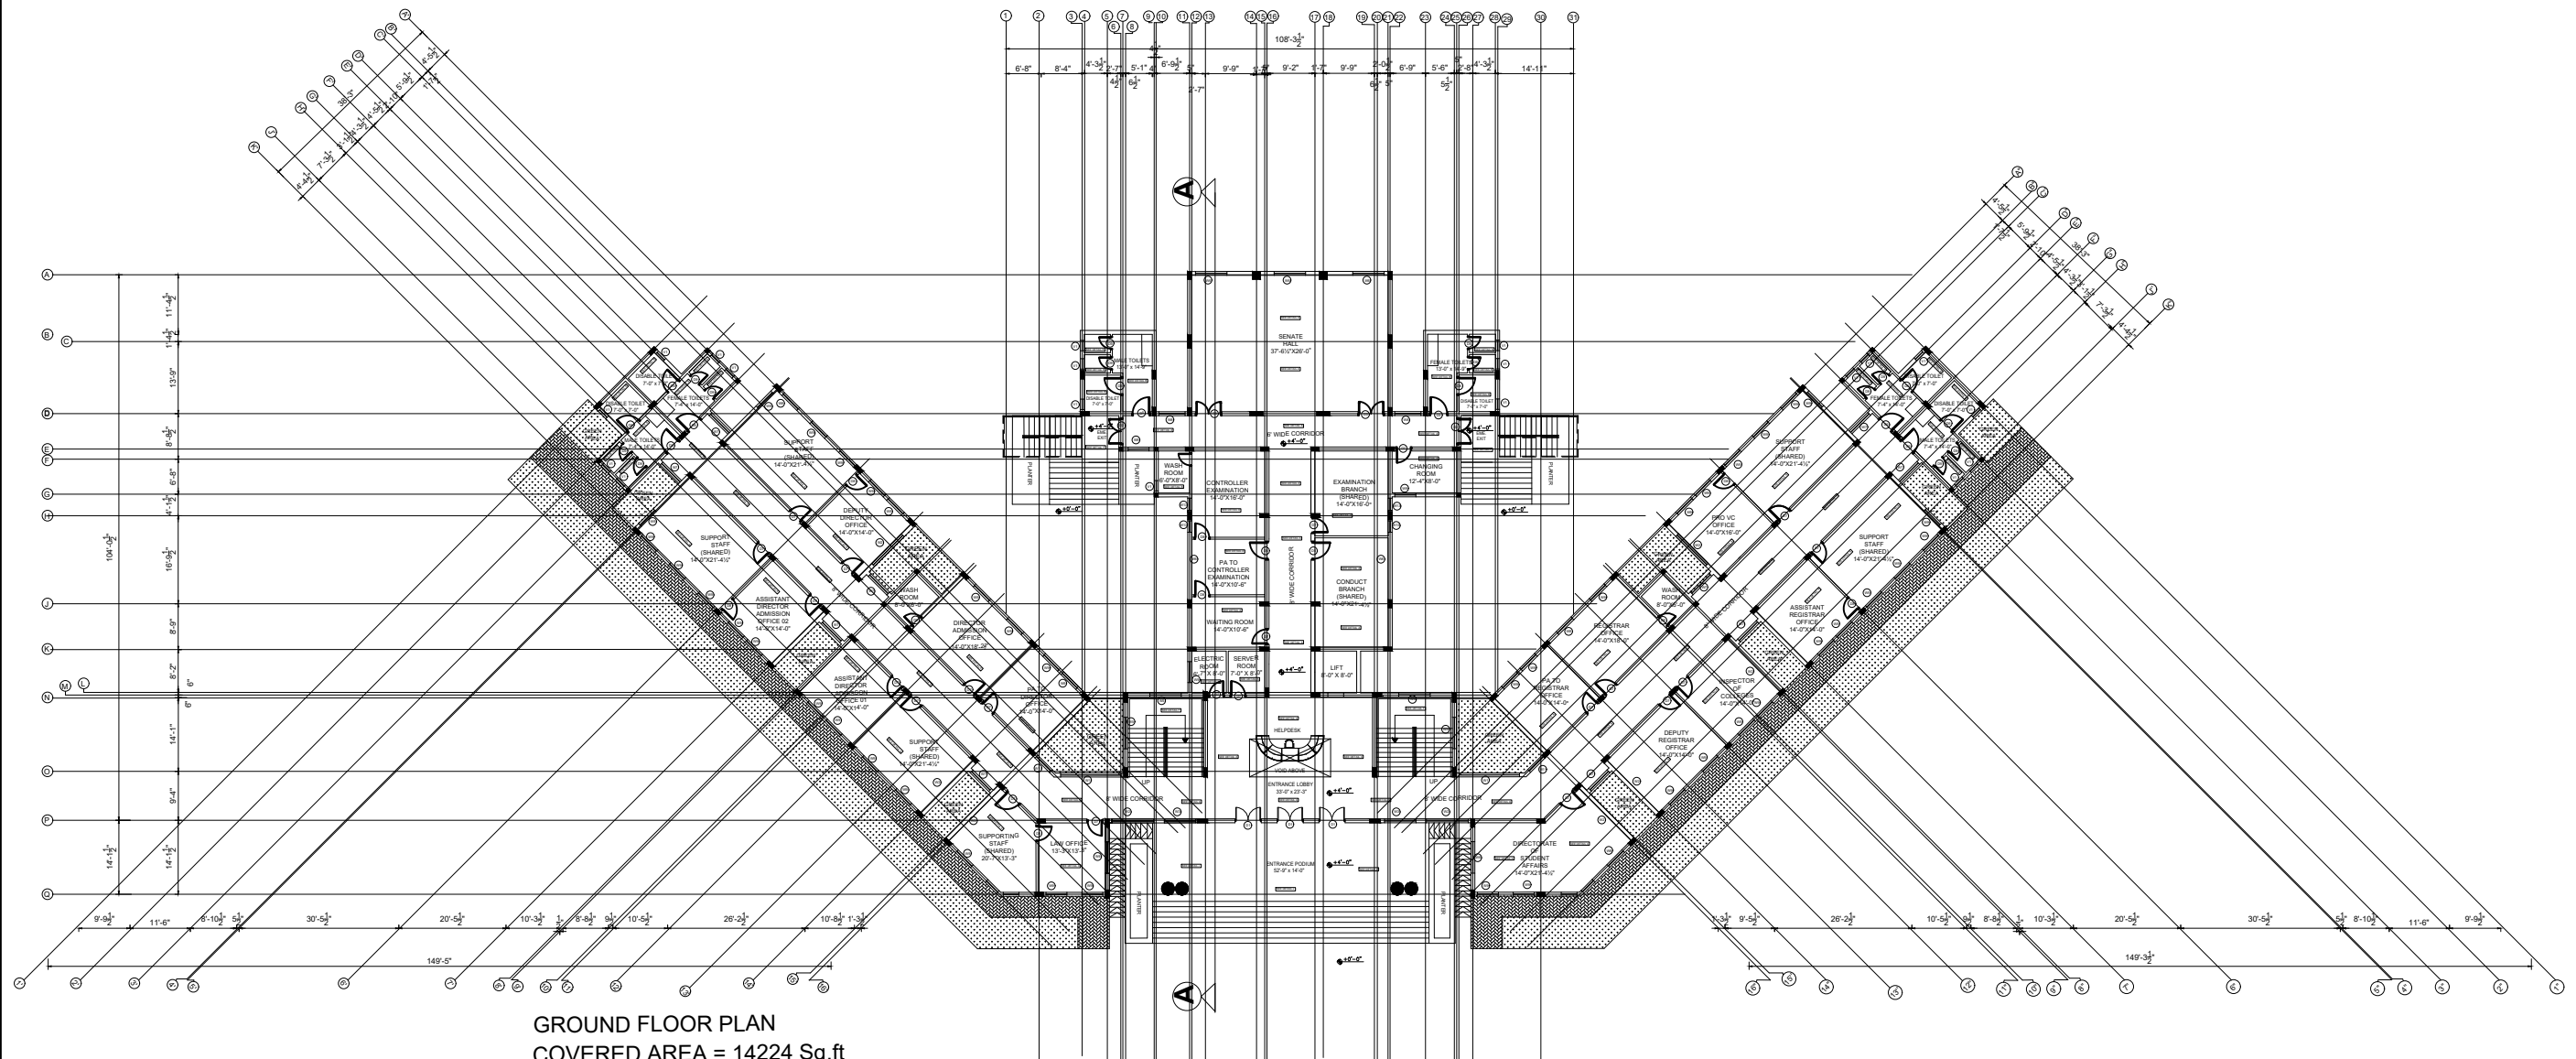[illegible]

NEW VISION ENGINEERING CONSULTANT

Head Office: Office No.B-6 Second Floor Masood Arcade
IJP Road Islamabad.
Ph: +92-51-4848375, Fax: +92-51-4848375
Email: newvisionec@yahoo.com

Regional Office: 287-A Street # 6, Cavalry Ground ,Lahore
Ph: +92-42-37250130



PROJECT:

**"PROVISION OF MISSING FACILITIES FOR THE
SHAIKH AYAZ UNIVERSITY SHIKARPUR"**

TITLE:

ADMINISTRATION BLOCK

GROUND FLOOR PLAN

CAD filename:

CLIENT:

THE SHAIKH AYAZ UNIVERSITY

DESIGNED BY:	AR. SALMAN
--------------	------------

	APPROVED BY:
N	S A

DATE : AUGUST, 2022



DRAWN BY:
RANA ALI HAIDER

JOB NO.	
---------	--

SCALE: N.T.S

	DRG. NO.
--	----------

AR-01

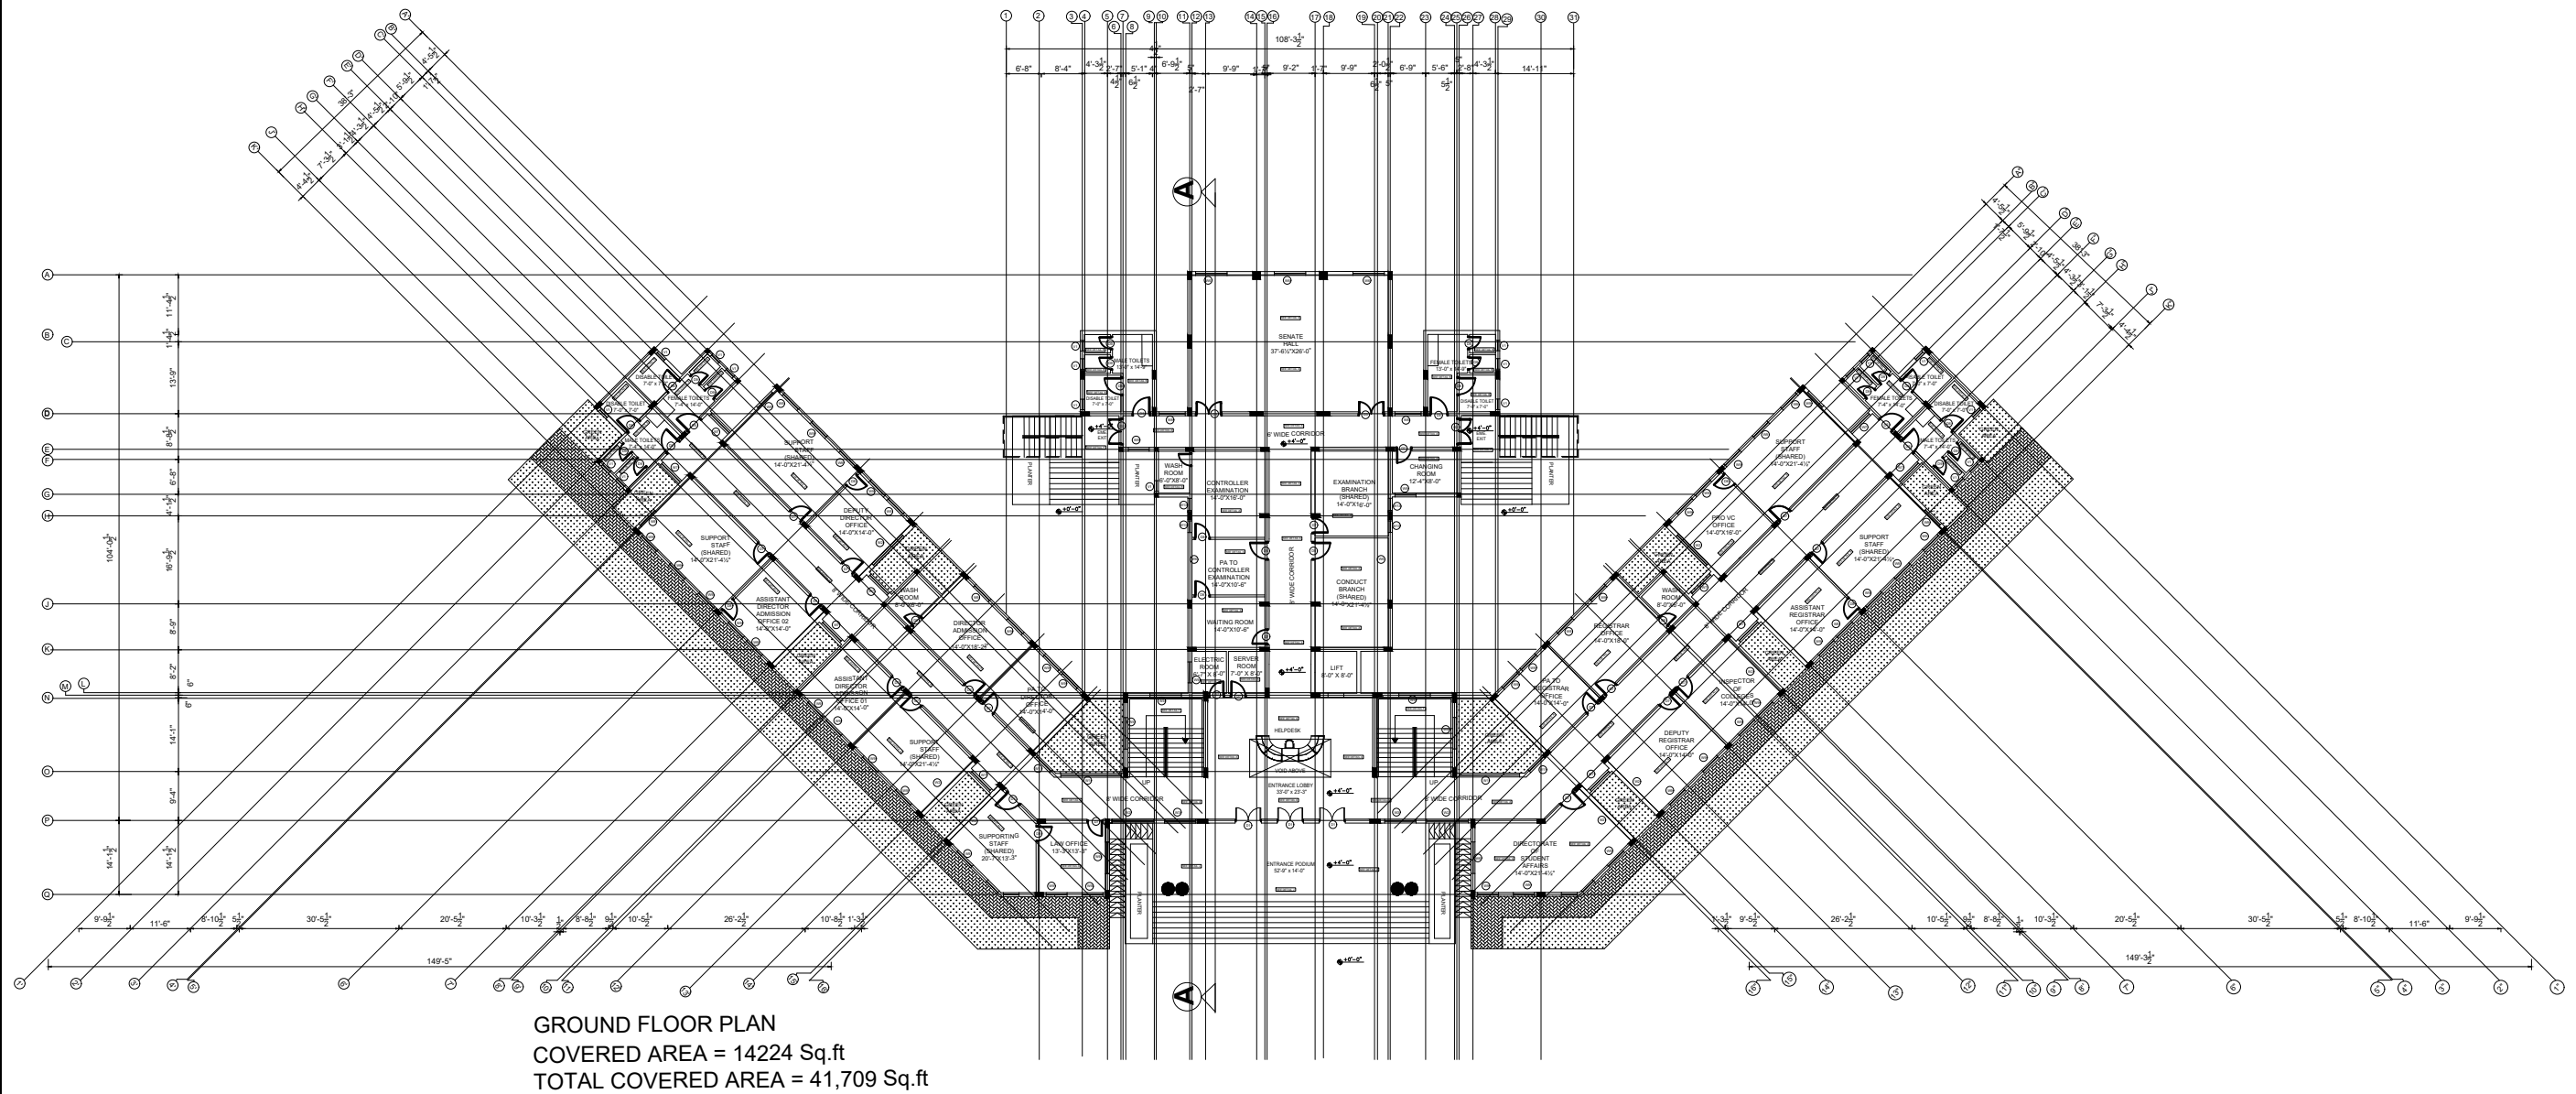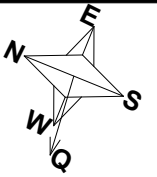



ADDITION & REVISION					
ADD/REV. NO.	DATE	DESCRIPTION	DES. BY	CHK. BY	APP. BY



NEW VISION ENGINEERING CONSULTANT
Head Office: Office No.B-6 Second Floor Masood Arcade
IJP Road Islamabad.
Ph: +92-51-4848375, Fax: +92-51-4848375
Email: newvisionec@yahoo.com
Regional Office: 287-A Street # 6, Cavalry Ground ,Lahore
Ph: +92-42-37250130

PROJECT:	"PROVISION OF MISSING FACILITIES FOR THE SHAIKH AYAZ UNIVERSITY SHIKARPUR"	
TITLE:	ADMINISTRATION BLOCK GROUND FLOOR PLAN	
CAD filename:		

CLIENT:			THE SHAIKH AYAZ UNIVERSITY		
DESIGNED BY:	AR. SALMAN	APPROVED BY:	S A	DATE :	AUGUST, 2022
DRAWN BY:	RANA ALI HAIDER	JOB NO.		SCALE:	N.T.S
DRG. NO.	AR-01				

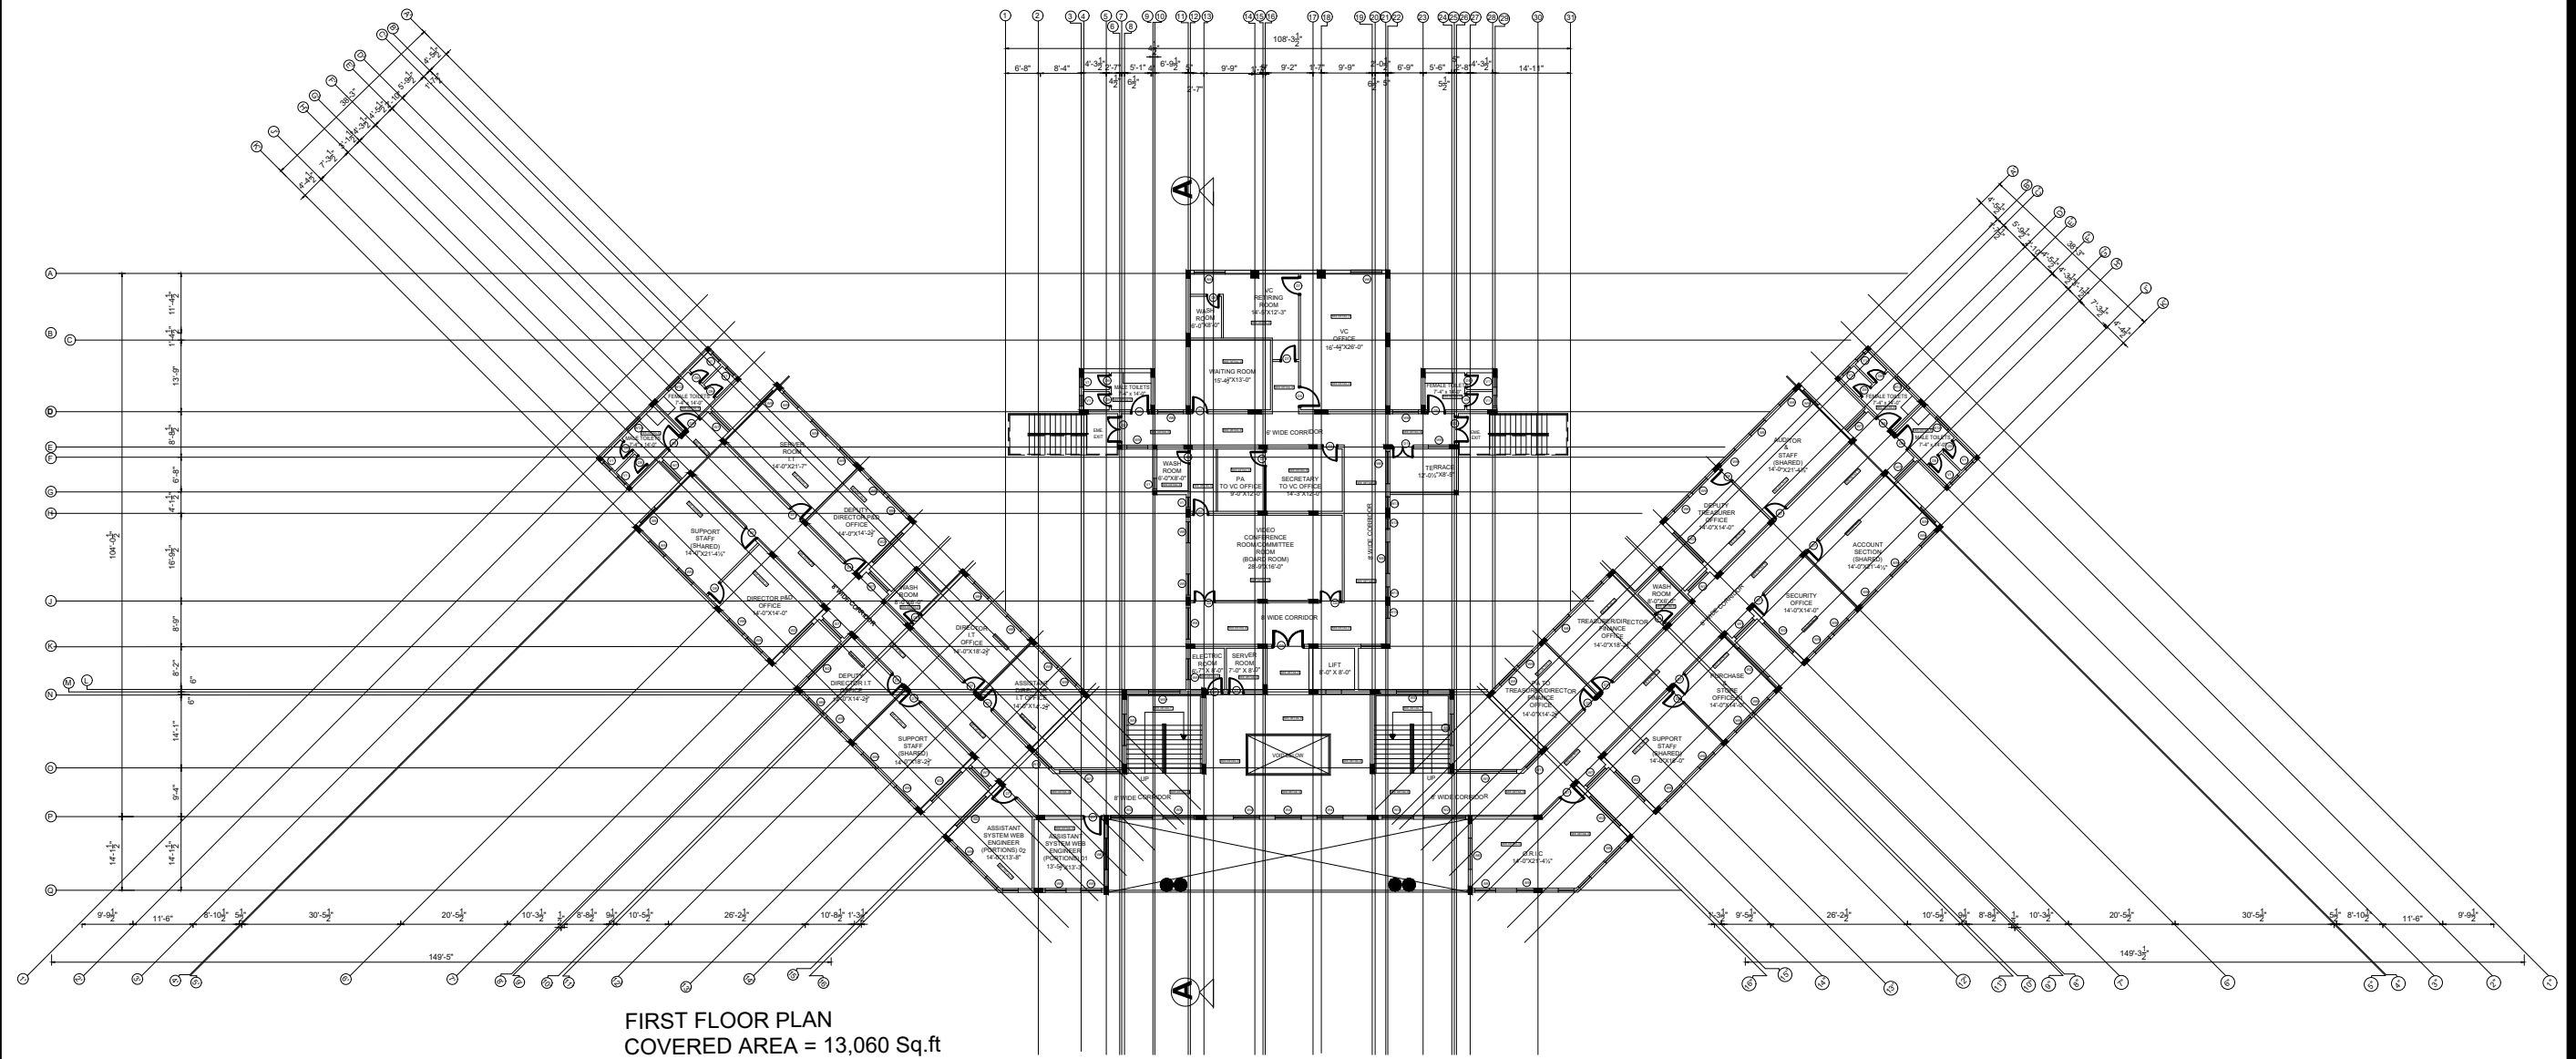
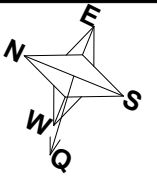


ADDITION & REVISION					
ADD./REV. NO.	DATE	DESCRIPTION	DES. BY	CHK. BY	APP. BY



NEW VISION ENGINEERING CONSULTANT
Head Office: Office No.B-6 Second Floor Masood Arcade
IJP Road Islamabad.
Ph: +92-51-4848375, Fax: +92-51-4848375
Email: newvisionec@yahoo.com
Regional Office: 287-A Street # 6, Cavalry Ground ,Lahore
Ph: +92-42-37250130

T e	PROJECT: "PROVISION OF MISSING FACILITIES FOR THE SHAIKH AYAZ UNIVERSITY SHIKARPUR"		CLIENT: THE SHAIKH AYAZ UNIVERSITY	
	TITLE: ADMINISTRATION BLOCK FIRST FLOOR PLAN	DESIGNED BY: AR. SALMAN	APPROVED BY: S A	DATE : AUGUST, 2022
		DRAWN BY: RANA ALI HAIDER	JOB NO.	SCALE: N.T.S
CAD filename:		DRG. NO. AR-02		

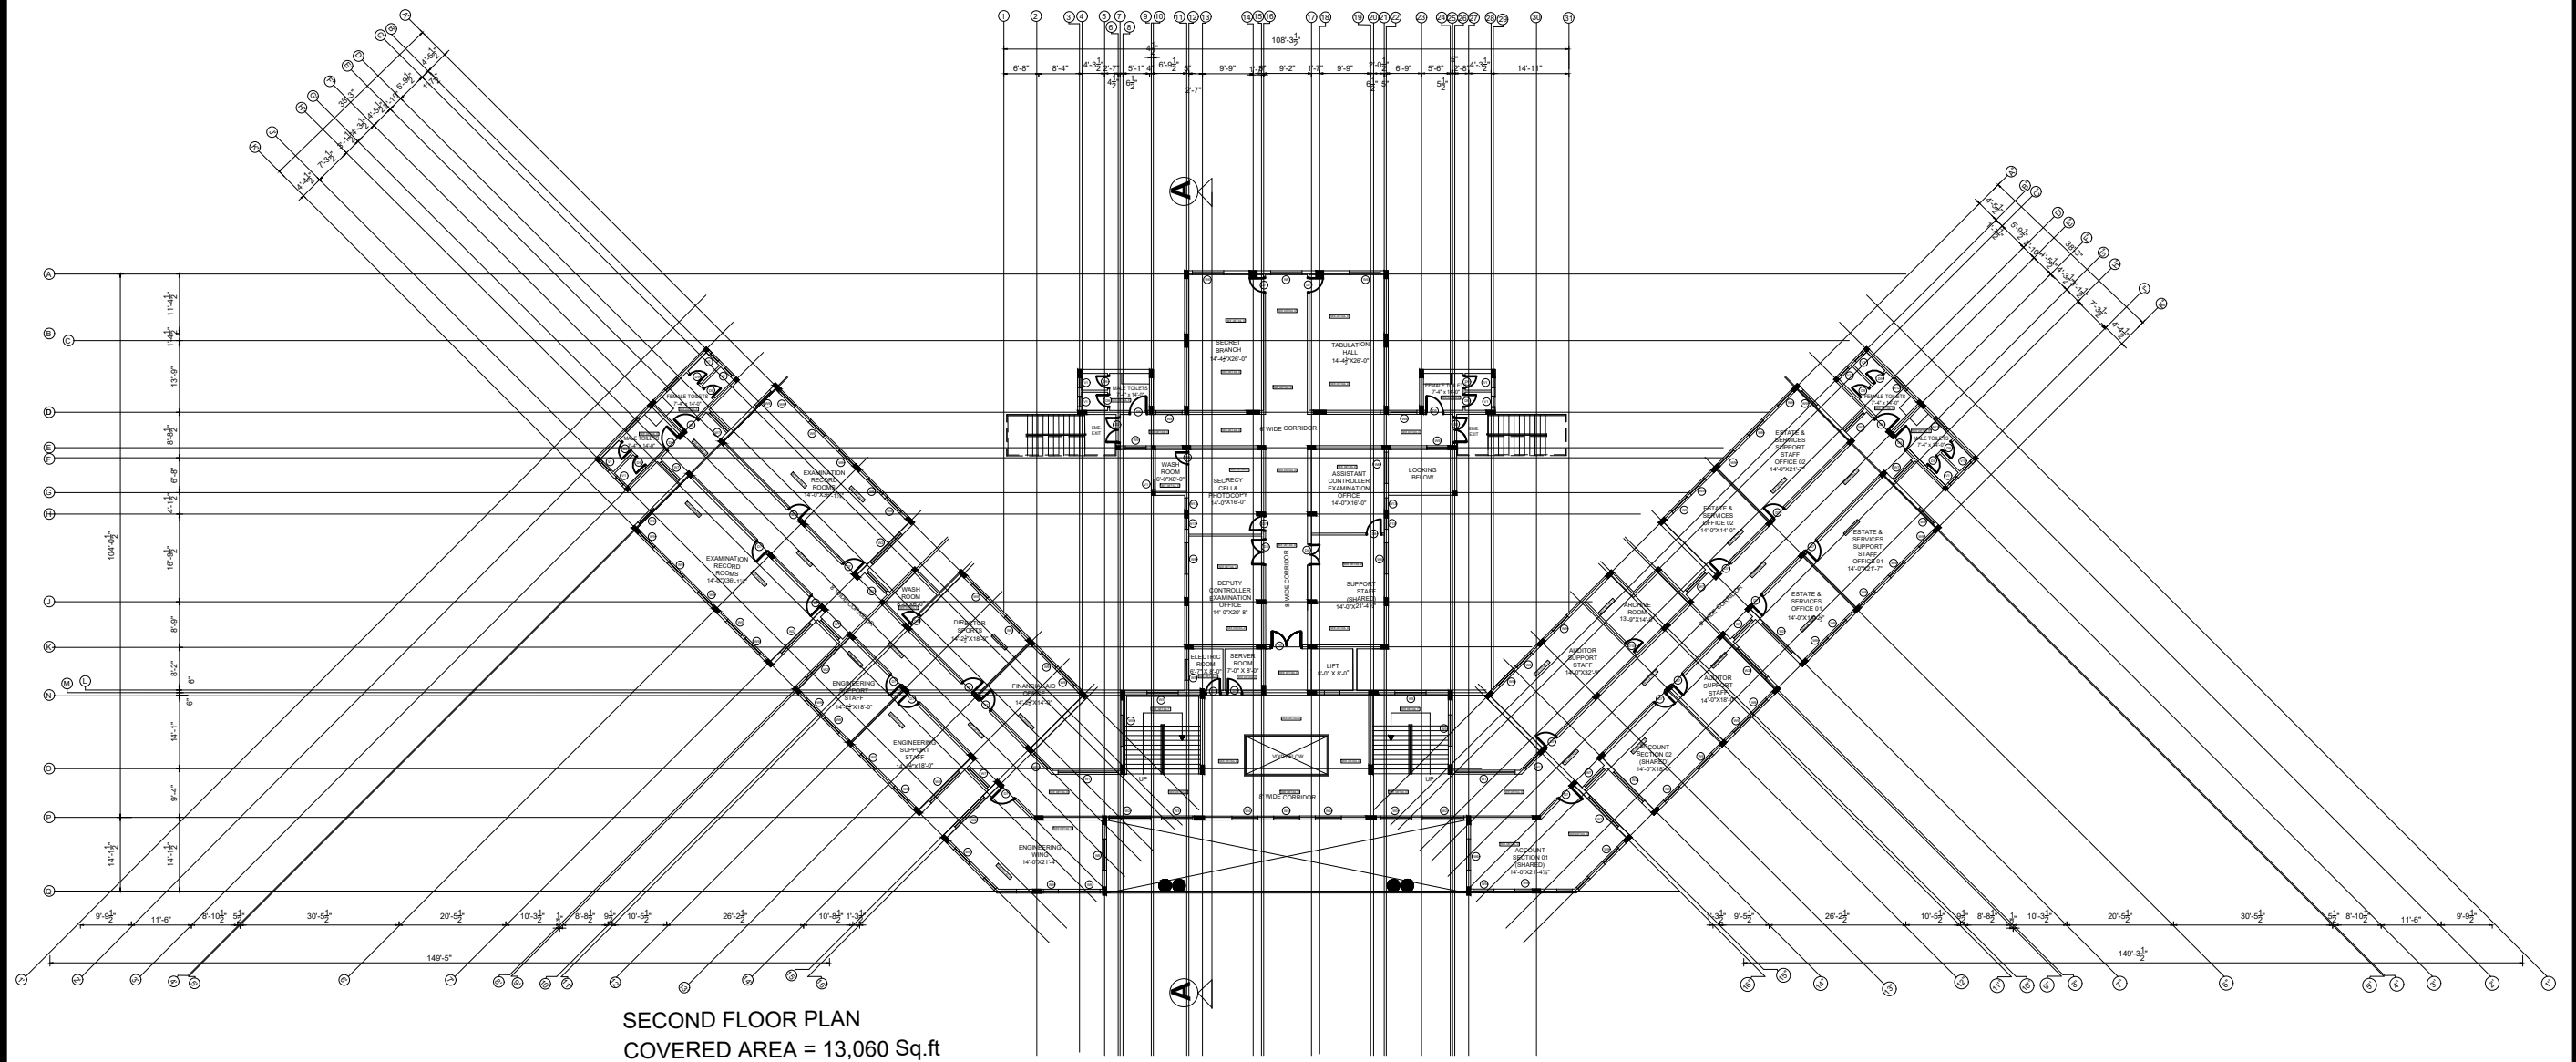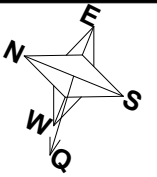

SECOND FLOOR PLAN
COVERED AREA = 13,060 Sq.ft

ADDITION & REVISION					
ADD./REV. NO.	DATE	DESCRIPTION	DES. BY	CHK. BY	APP. BY



NEW VISION ENGINEERING CONSULTANT
Head Office: Office No.B-6 Second Floor Masood Arcade
IJP Road Islamabad.
Ph: +92-51-4848375, Fax: +92-51-4848375
Email: newvisionec@yahoo.com
Regional Office: 287-A Street # 6, Cavalry Ground ,Lahore
Ph: +92-42-37250130

PROJECT:

"PROVISION OF MISSING FACILITIES FOR THE SHAIKH AYAZ UNIVERSITY SHIKARPUR"

CLIENT:

THE SHAIKH AYAZ UNIVERSITY

DESIGNED BY:

AR. SALMAN

APPROVED BY:

S A

DATE :

AUGUST, 2022

TITLE:

ADMINISTRATION BLOCK

SECOND FLOOR PLAN

DRAWN BY:

RANA ALI HAIDER

JOB NO.



SCALE:

N.T.S

CAD filename:

DRG. NO.

AR-03

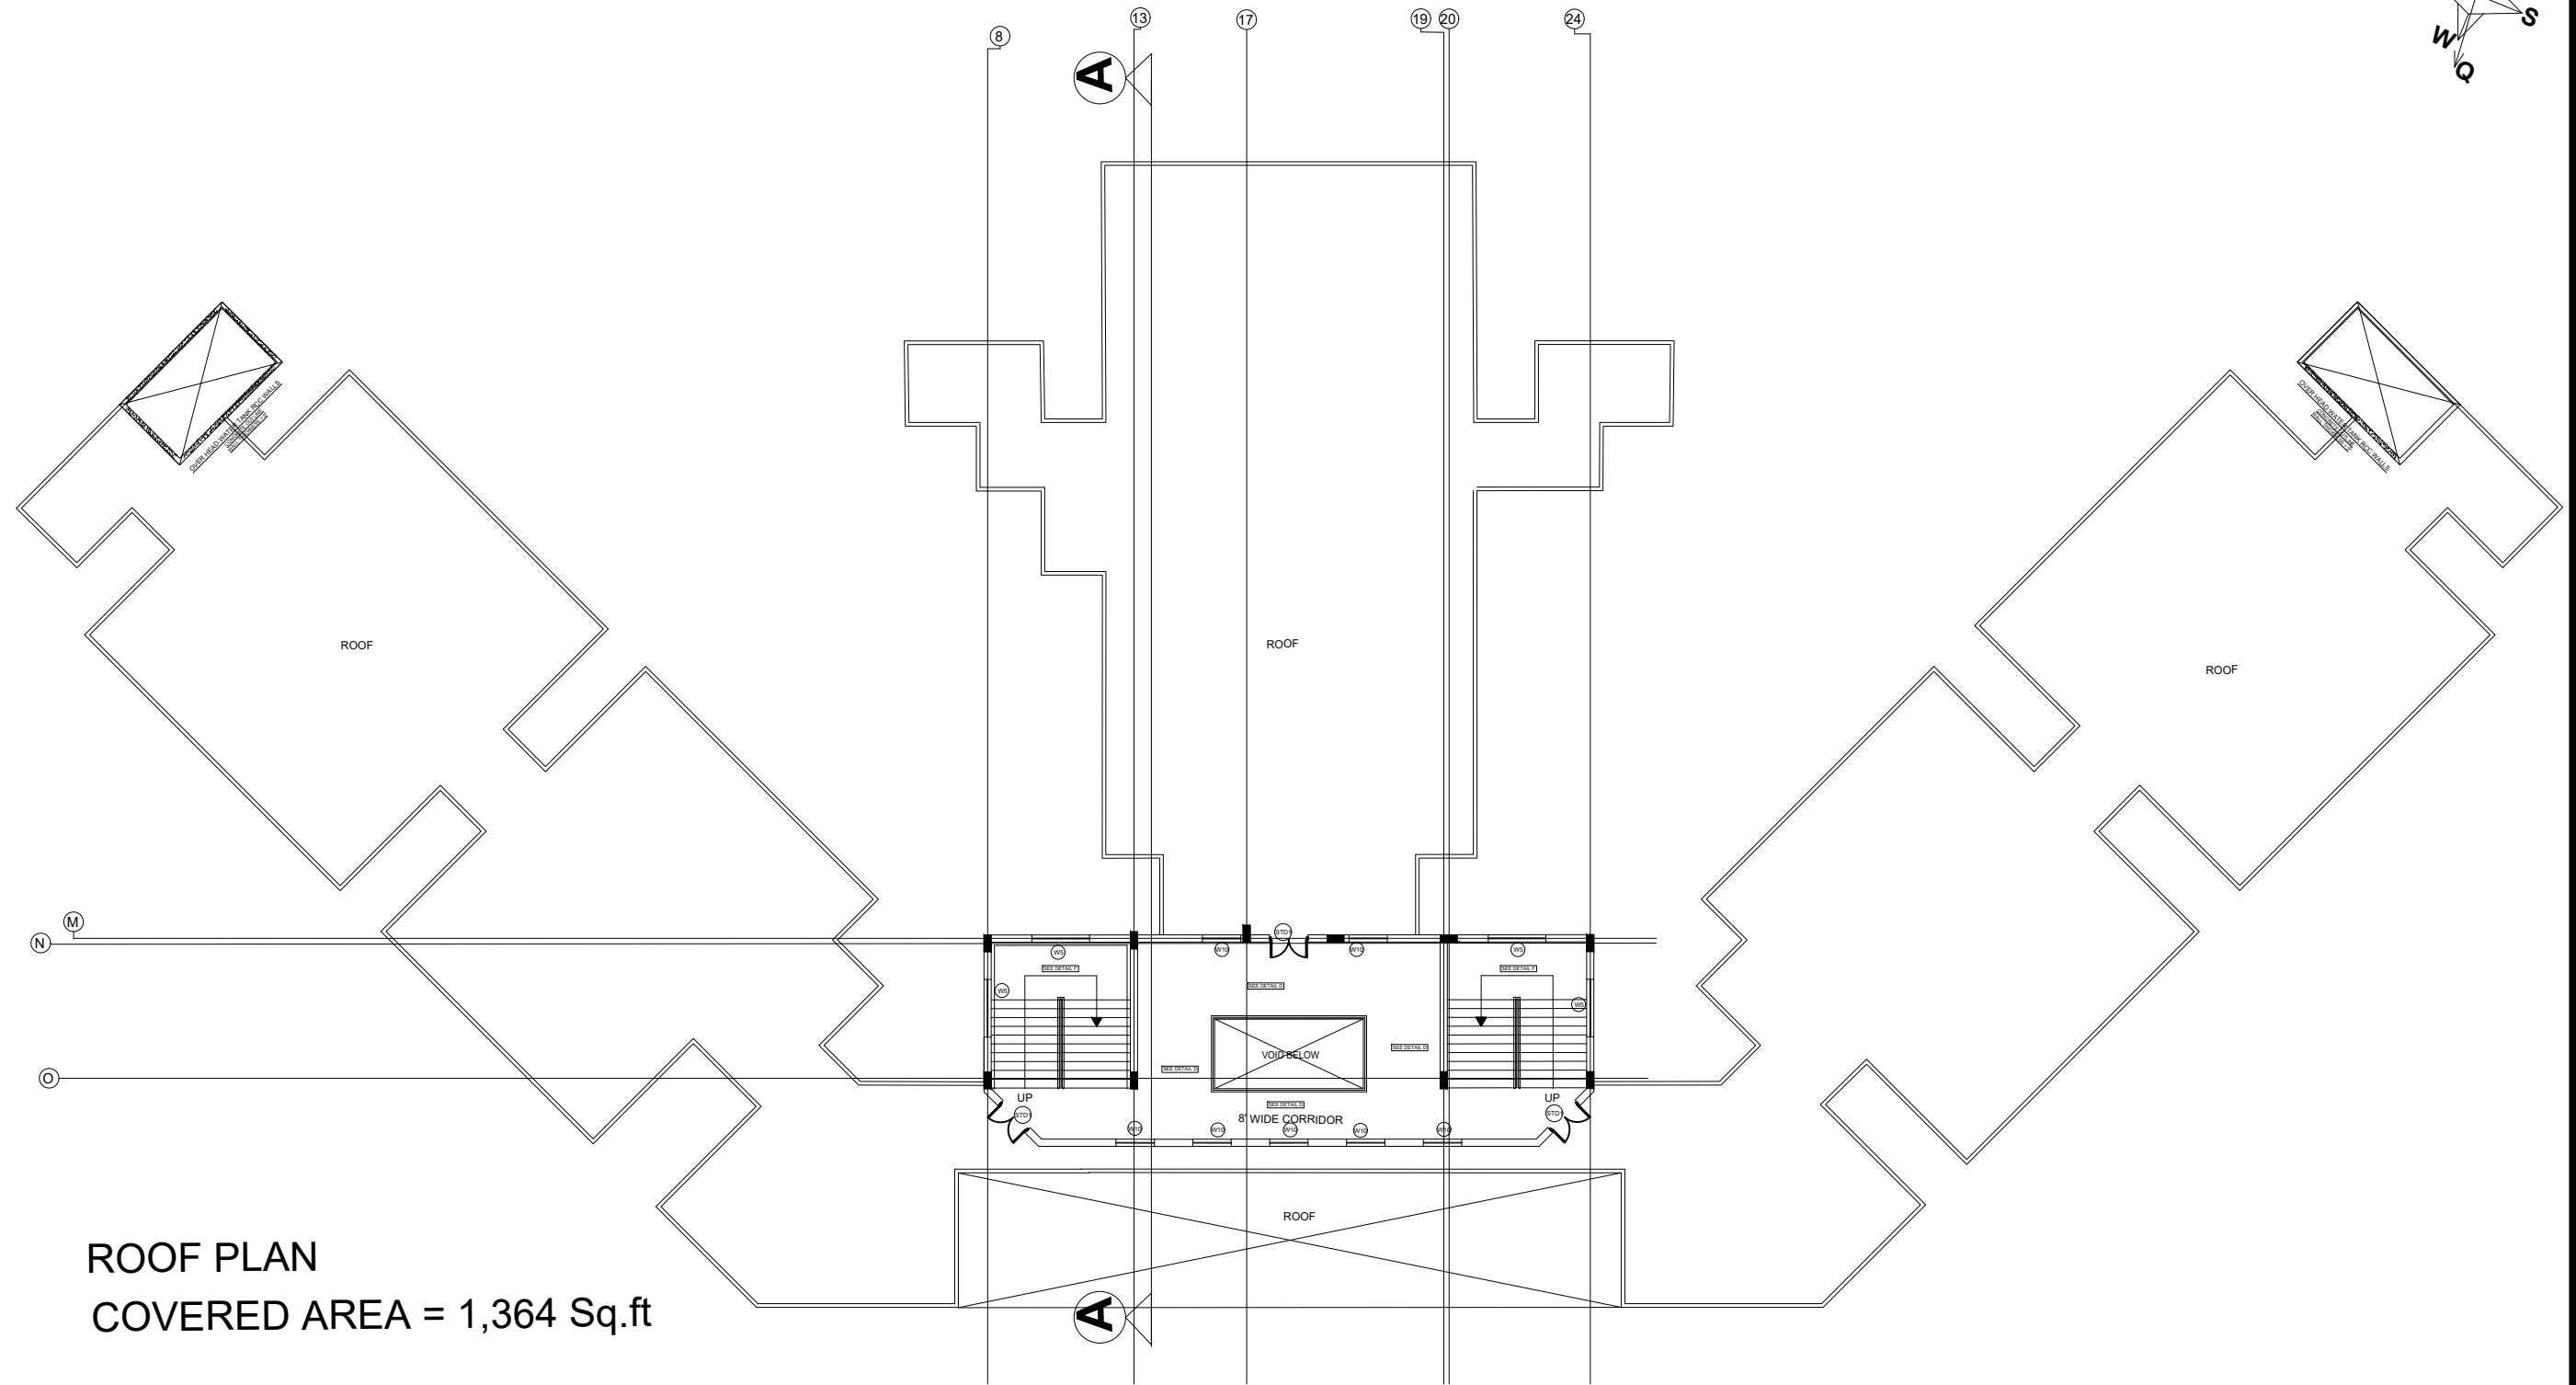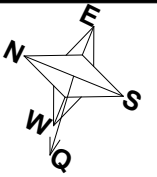



ROOF PLAN
COVERED AREA = 1,364 Sq.ft

ADDITION & REVISION						
ADD/REV. NO.	DATE	DESCRIPTION	DES. BY	CHK. BY	APP. BY	



NEW VISION ENGINEERING CONSULTANT
Head Office: Office No.B-6 Second Floor Masood Arcade
IJP Road Islamabad.
Ph: +92-51-4848375, Fax: +92-51-4848375
Email: newvisionec@yahoo.com
Regional Office: 287-A Street # 6, Cavalry Ground ,Lahore
Ph: +92-42-37250130

PROJECT: "PROVISION OF MISSING FACILITIES FOR THE SHAIKH AYAZ UNIVERSITY SHIKARPUR"		CLIENT: THE SHAIKH AYAZ UNIVERSITY	
TITLE: ADMINISTRATION BLOCK ROOF FLOOR PLAN	DESIGNED BY: AR. SALMAN		APPROVED BY: S A
	DRAWN BY: RANA ALI HAIDER		JOB NO.
CAD filename:		DRG. NO. AR-04	
		DATE : AUGUST, 2022	
		SCALE: N.T.S	

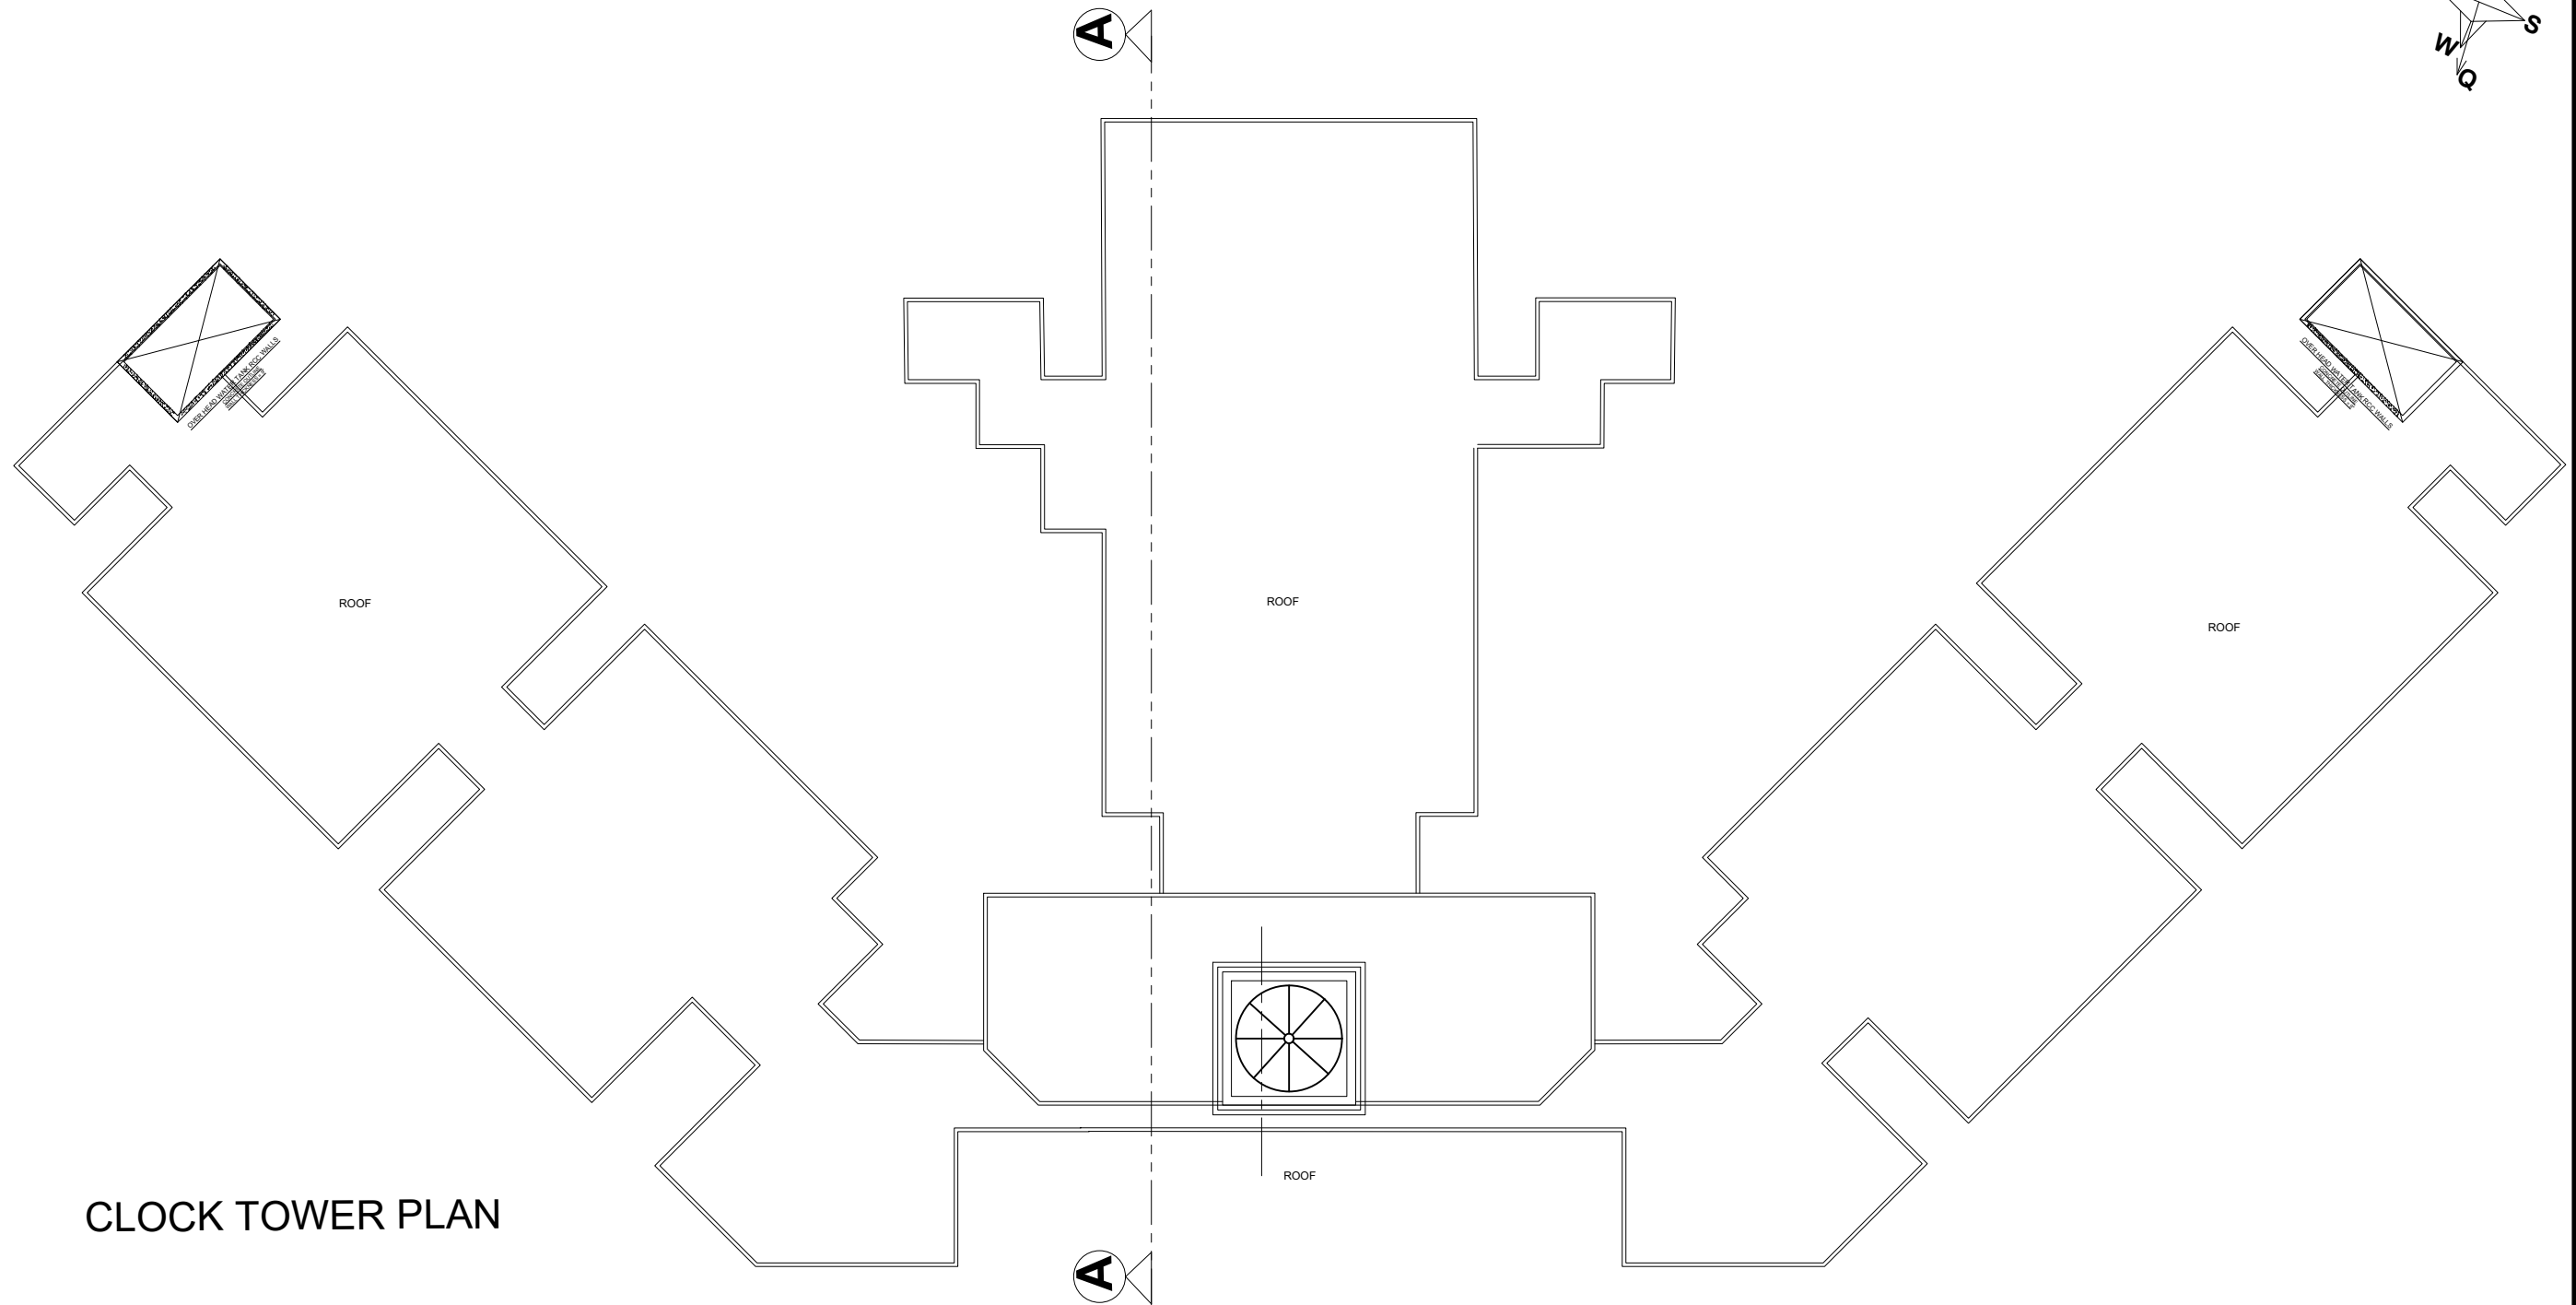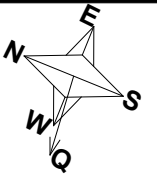


CLOCK TOWER PLAN

ADDITION & REVISION					
ADD./REV. NO.	DATE	DESCRIPTION	DES. BY	CHK. BY	APP. BY



NEW VISION ENGINEERING CONSULTANT
Head Office: Office No.B-6 Second Floor Masood Arcade
IJP Road Islamabad.
Ph: +92-51-4848375, Fax: +92-51-4848375
Email: newvisionec@yahoo.com
Regional Office: 287-A Street # 6, Cavalry Ground ,Lahore
Ph: +92-42-37250130

PROJECT: "PROVISION OF MISSING FACILITIES FOR THE SHAIKH AYAZ UNIVERSITY SHIKARPUR"		CLIENT: THE SHAIKH AYAZ UNIVERSITY	
TITLE: ADMINISTRATION BLOCK CLOCK TOWER PLAN	DESIGNED BY: AR. SALMAN		APPROVED BY: S A
	DRAWN BY: RANA ALI HAIDER		JOB NO.
CAD filename:		DRG. NO. AR-05	
		DATE : AUGUST, 2022	
		SCALE: N.T.S	

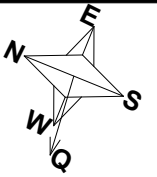

ADMIN BLOCK AREA'S



GROUND FLOOR PLAN	14224 sft
FIRST FLOOR PLAN	13060 sft
SECOND FLOOR PLAN	13060 sft
ROOF FLOOR PLAN	1364 sft
TOTAL AREA	41708 sft

ADDITION & REVISION					
ADD/REV. NO.	DATE	DESCRIPTION	DES. BY	CHK. BY	APP. BY



NEW VISION ENGINEERING CONSULTANT
Head Office: Office No.B-6 Second Floor Masood Arcade
IJP Road Islamabad.
Ph: +92-51-4848375, Fax: +92-51-4848375
Email: newvisionec@yahoo.com
Regional Office: 287-A Street # 6, Cavalry Ground ,Lahore
Ph: +92-42-37250130

PROJECT:	"PROVISION OF MISSING FACILITIES FOR THE SHAIKH AYAZ UNIVERSITY SHIKARPUR"		
TITLE:	ADMINISTRATION BLOCK AREA'S		
CAD filename:			
CLIENT:	THE SHAIKH AYAZ UNIVERSITY		
DESIGNED BY:	AR. SALMAN	APPROVED BY:	S A
DRAWN BY:	RANA ALI HAIDER	JOB NO.	
DRG. NO.		SCALE:	N.T.S

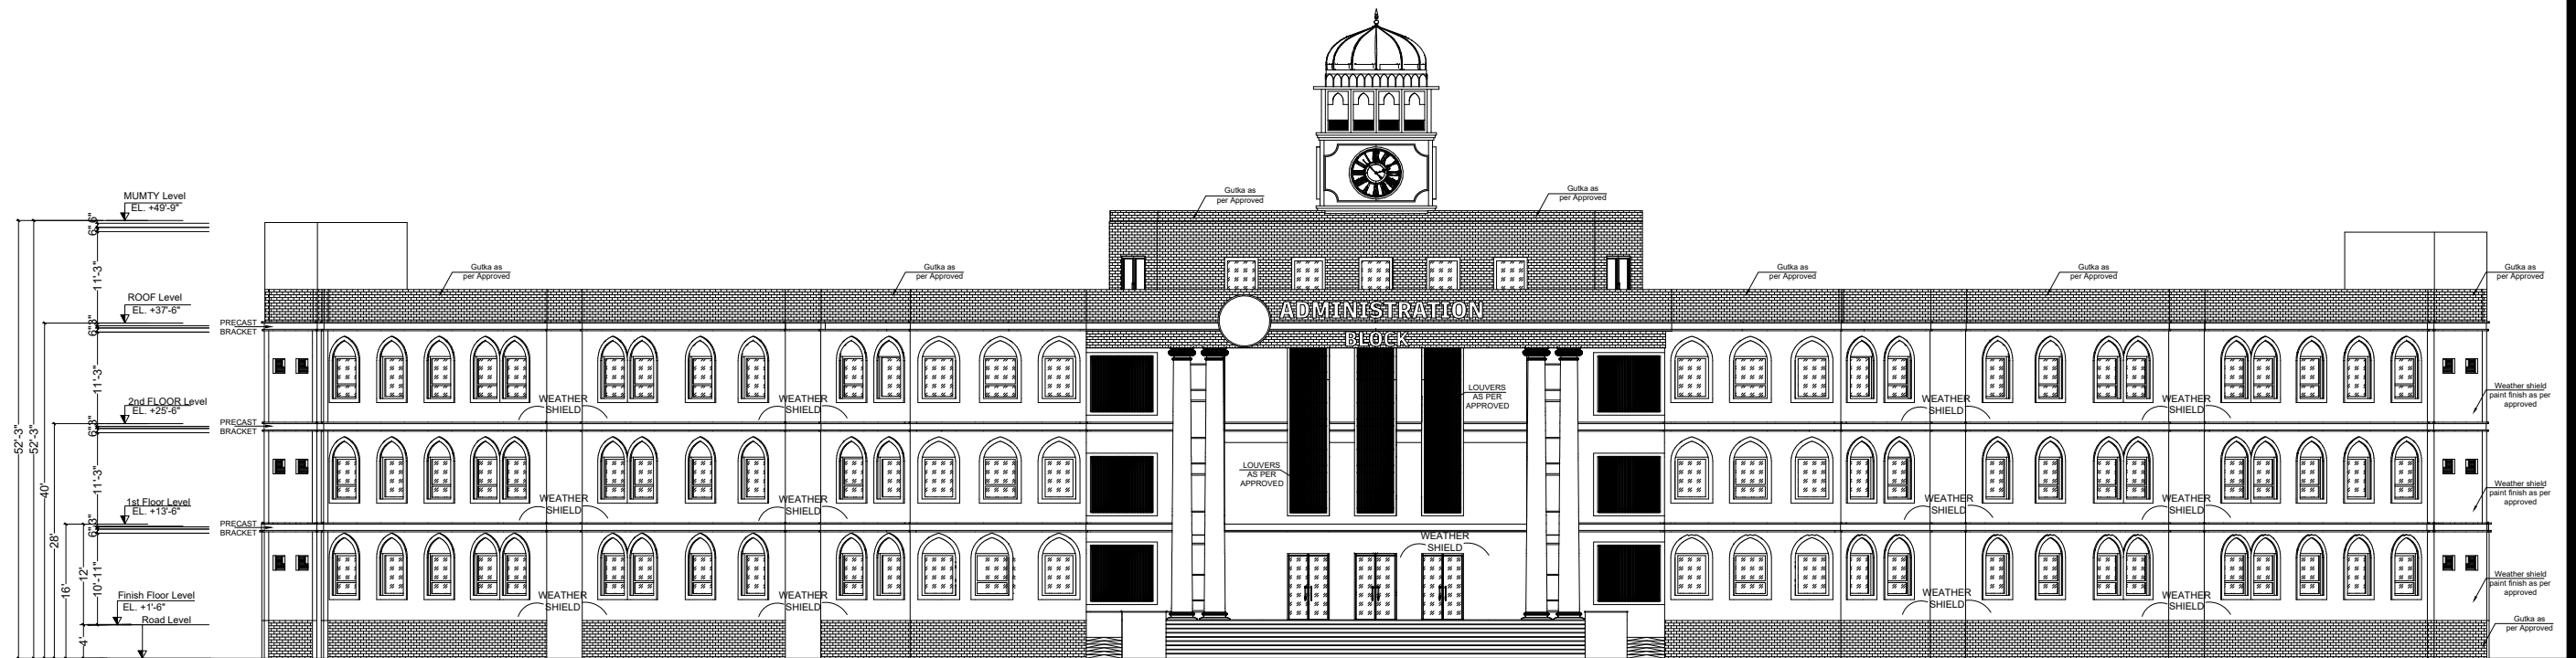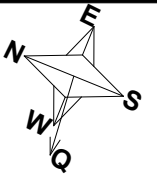


ADDITION & REVISION					
ADD./REV. NO.	DATE	DESCRIPTION	DES. BY	CHK. BY	APP. BY



NEW VISION ENGINEERING CONSULTANT
Head Office: Office No.B-6 Second Floor Masood Arcade
IJP Road Islamabad.
Ph: +92-51-4848375, Fax: +92-51-4848375
Email: newvisionec@yahoo.com
Regional Office: 287-A Street # 6, Cavalry Ground ,Lahore
Ph: +92-42-37250130

T

PROJECT: "PROVISION OF MISSING FACILITIES FOR THE SHAIKH AYAZ UNIVERSITY SHIKARPUR"		CLIENT: THE SHAIKH AYAZ UNIVERSITY		
TITLE: ADMINISTRATION BLOCK ELEVATION AT E1	DESIGNED BY: AR. SALMAN		APPROVED BY: S A	DATE : AUGUST, 2022
	DRAWN BY: RANA ALI HAIDER		JOB NO.	SCALE: N.T.S
	CAD filename: DRG. NO. AR-07			

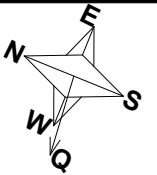

DETAIL SECTION A / A

AS PER STRUCTURE DETAILS

ADDITION & REVISION						
ADD/REV. NO.	DATE	DESCRIPTION	DES. BY	CHK. BY	APP. BY	



NEW VISION ENGINEERING CONSULTANT
Head Office: Office No.B-6 Second Floor Masood Arcade
IJP Road Islamabad.
Ph: +92-51-4848375, Fax: +92-51-4848375
Email: newvisionec@yahoo.com
Regional Office: 287-A Street # 6, Cavalry Ground ,Lahore
Ph: +92-42-37250130

PROJECT:

"PROVISION OF MISSING FACILITIES FOR THE
SHAIKH AYAZ UNIVERSITY SHIKARPUR"

CLIENT:

THE SHAIKH AYAZ UNIVERSITY

DESIGNED BY:

AR. SALMAN

APPROVED BY:

S A

DATE :

AUGUST, 2022

TITLE:

ADMINISTRATION BLOCK
SECTION AT A-A

DRAWN BY:

RANA ALI HAIDER

JOB NO.



SCALE:

N.T.S

CAD filename:

DRG. NO.

AR-11

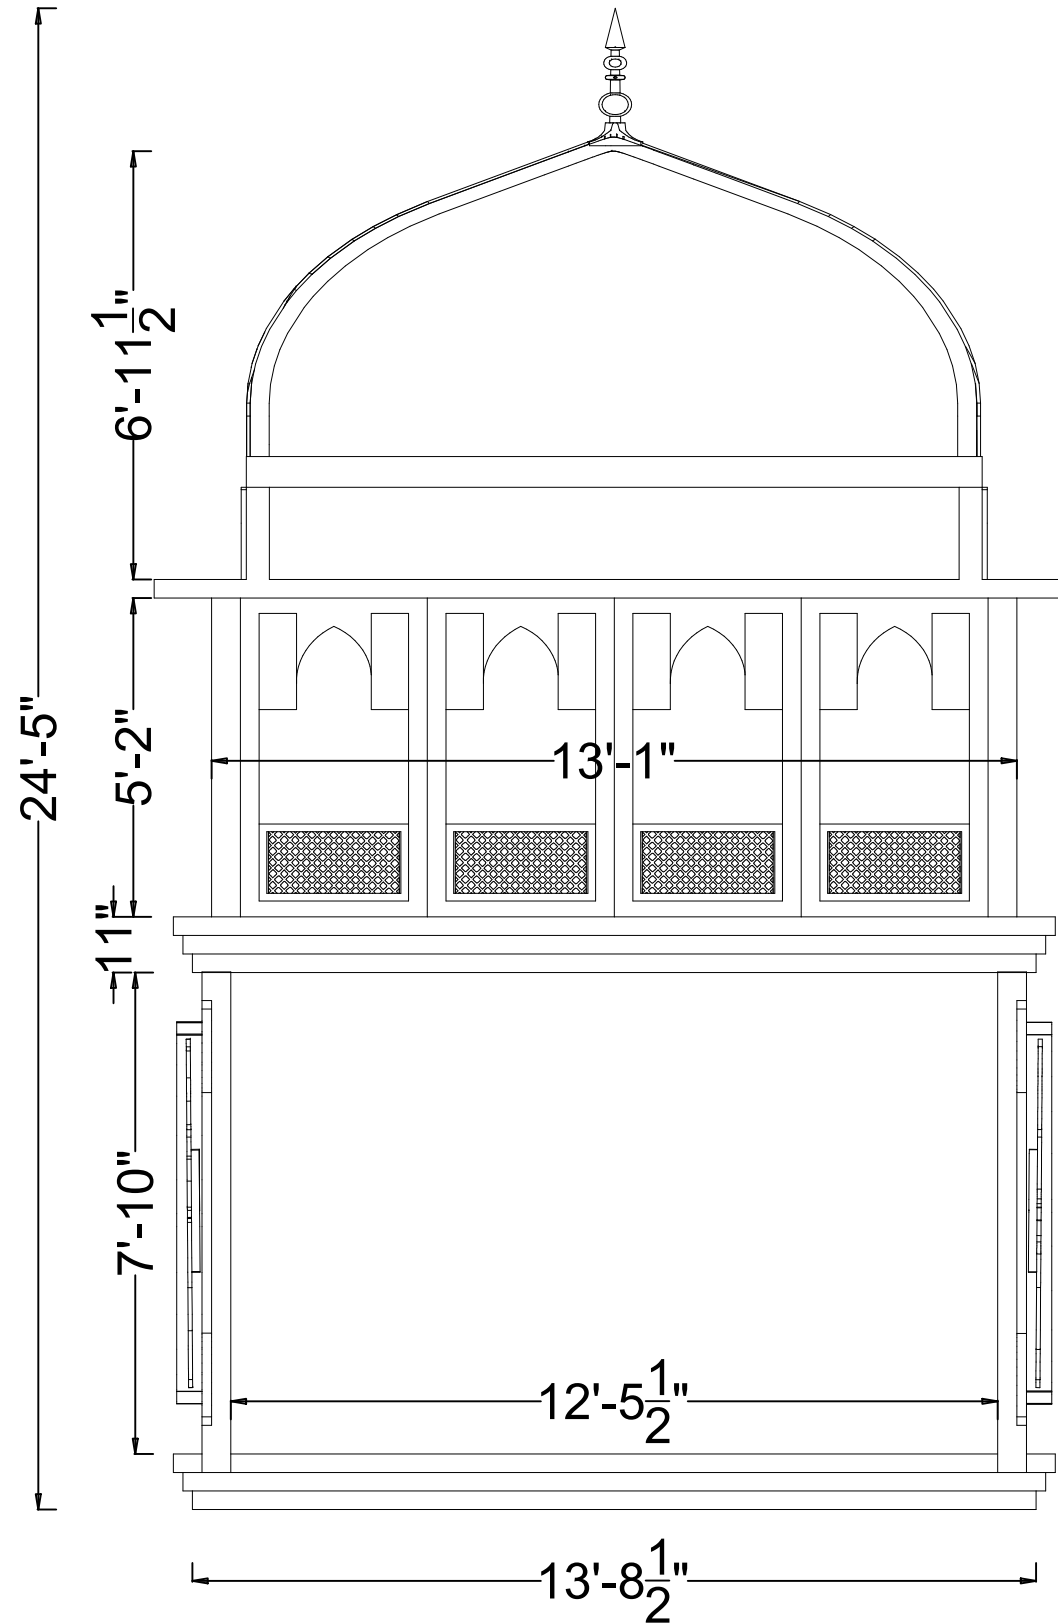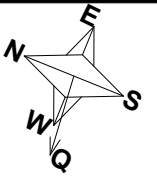

ADDITION & REVISION						
ADD/REV. NO.	DATE	DESCRIPTION	DES. BY	CHK. BY	APP. BY	



NEW VISION ENGINEERING CONSULTANT
Head Office: Office No.B-6 Second Floor Masood Arcade
IJP Road Islamabad.
Ph: +92-51-4848375, Fax: +92-51-4848375
Email: newvisionec@yahoo.com
Regional Office: 287-A Street # 6, Cavalry Ground ,Lahore
Ph: +92-42-37250130

PROJECT:

"PROVISION OF MISSING FACILITIES FOR THE SHAIKH AYAZ UNIVERSITY SHIKARPUR"

CLIENT:

THE SHAIKH AYAZ UNIVERSITY

TITLE:

ADMINISTRATION BLOCK
CLOCK SECTION AT A-A

DESIGNED BY:

AR. SALMAN

APPROVED BY:

S A

DATE :

AUGUST, 2022

DRAWN BY:

RANA ALI HAIDER

JOB NO.

SCALE:

N.T.S

CAD filename:

DRG. NO.

AR-11a

GENERAL TECHNICAL NOTES

1. Figured dimensions are to be followed.
 2. Class "A" kiln burnt brick with minimum crushing strength of 2000 PSI should be used & joint at end should be sloppy, Vertical toothed joint at corners are prohibited.
 3. A steel G-60 deformed steel should be used in beams footing slabs and water retaining structures, in columns, for all diameters.
 4. All steel should be checked for its quality and placement DETAIL as shown in drawings.
 5. Extra care is required for proper placement of top reinforcement at support sections and cantilevers.
 6. Dotted bars designate top reinforcement.
 7. Provide L- shaped end hooks for all bars at discontinuous ends in footings, walls, beams and slabs as shown in drawings.
 8. Lap length should be followed As except specified:-
 - (a) 1" $\varnothing$ = 60"
 - (b) 3/4" $\varnothing$ = 45"
 - (c) 5/8" $\varnothing$ = 36"
 - (d) 1/2" $\varnothing$ = 30"
 - (e) 3/8" $\varnothing$ = 23"
 09. Provide 3/8" dia at 12" c/c as distribution steel if not shown in drawings.
 10. Minimum concrete cover.
 - a) Footing = 2"
 - b) Slabs = 3/4"
 - c) Beams = 1 1/2"
 - d) Columns = 1 1/2"
 - e) Water tank and retaining wall
i- Water/earth face or exposed to weather = 2"
ii- Other faces = 1"
 11. All footing should be taken below the original Ground Level to achieve the minimum depth as shown in drawings. Footing should not be placed on uncompacted fill area.
 12. All drawings should be read in conjunction with Architectural Drawings.
 13. Contractor will co-ordinate all drawings such as architectural, structural, electrical, mechanical, water supply, drainage etc: before execution of work.
 14. Standard ACI 318, Astm C 33 and Astm A-615 use for structural concrete
 15. Fine modulus of fine aggregate varies from 2- 3.5mm
For concrete use 2.9- 3.2mm
For plaster use 2.2- 3.6mm
- QUALITY OF CONCRETE
1. FOOTINGS & RETAINING WALLS.
Minimum concrete compressive strength for 6"x12" cylinder to be 3000 psi at 28 days age. Concrete Nominal Mix 1:2:4 or more rich to provide specified strength (Equivalent 6"x6"x6" cube strength 3750 psi)

2. COLUMNS.

Minimum concrete compressive strength for 6"x12" cylinder to be 4000 psi at 28 days age. Concrete Nominal Mix to be 1:1½:3 or more rich to provide specified strength

3. BEAMS, RIBS & SLABS.

Minimum concrete compressive strength for 6"x12" cylinder to be 3000 psi at 28 days age. Concrete Nominal Mix to be 1:2:4 or more rich to provide specified strength (Equivalent 6"x6"x6" cube strength 3750 psi)


4. Use of plasticizers recommended to reduce the water cement ratio and increase workability of concrete.
5. All concrete mixes to be used, should be got designed & approved before execution of work.
6. Quality, size and gradation of aggregates (fine & course) as used during the mix design, should be strictly adhered with.
7. The Design is in accordance with Seismic Zone 2A.

NOTES

1. ALL LAYOUT DIMENSIONS AND F.FLOOR LEVELS TO BE AS PER ARCH DRAWING.
2. PROVIDE PLINTH BEAM PB AT PLINTH LEVEL, WALL BEAMS AT SLAB LEVEL.
3. PROVIDE #2 DOUBLE-LEG TIE BARS AT 12" CENTRES AT COMMON JOINT BETWEEN WALLS AND COLUMNS. THESE BARS SHOULD PASS INTO WALLS ON EACH SIDE OF COLUMNS.

REINFORCING STEEL

REINFORCING STEEL $f_y = 60,000$ psi			
BAR NO.	BAR DIA (IN.)	DEVELOPMENT LENGTH (INCH) IN TENSION	
		$f_c = 3000$ psi	$f_c = 4000$ psi
#3	0.375	12"	15"
#4	0.500	22"	19"
#5	0.625	28"	24"
#6	0.750	33"	29"
#7	0.875	48"	42"
#8	1.000	55"	48"
BAR NO.	BAR DIA (IN.)	DEVELOPMENT LENGTH (INCH) IN COMPRESSION	
		$f_c = 3000$ psi	$f_c = 4000$ psi
#3	0.375	9"	8"
#4	0.500	11"	10"
#5	0.625	14"	12"
#6	0.750	17"	15"
#7	0.875	20"	17"
#8	1.000	22"	19"
BAR NO.	BAR DIA (IN.)	SPLICE LENGTH (INCH) IN TENSION	
		$f_c = 3000$ psi	$f_c = 4000$ psi
#3	0.375	22"	20"
#4	0.500	29"	25"
#5	0.625	37"	32"
#6	0.750	43"	38"
#7	0.875	63"	55"
#8	1.000	72"	63"

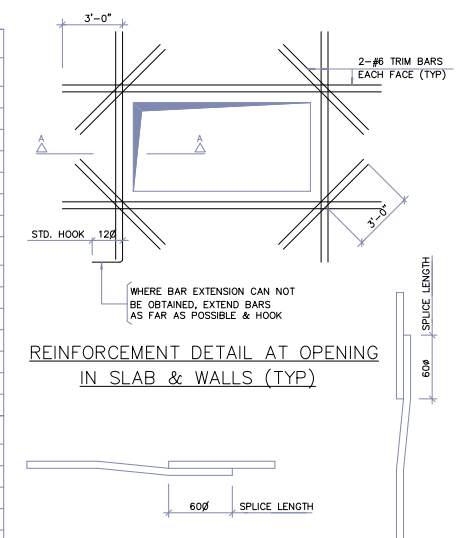

REINFORCEMENT DETAIL AT OPENING
IN SLAB & WALLS (TYP)

BEAM SPLICE
(TYP)


COLUMN SPLICE
(TYP)

BAR DIA	D
#3	2½"
#4	3"
#5	4"
#6	4½"
#8	6"
#9	9"
#11	11"




STANDARD BAR HOOKS


BAR DIA	D
Ø3	1 1/2"
Ø4	2"
Ø5	2 1/2"

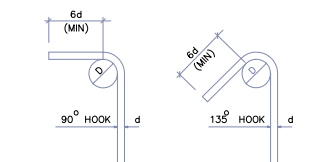

STIRRUPS AND TIE HOOKS

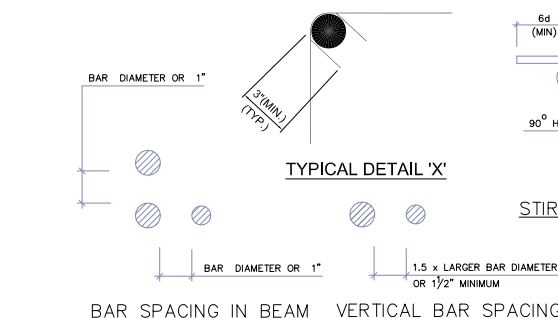

BAR SPACING IN BEAM	VERTICAL BAR SPACING
100	100
125	125
150	150
175	175
200	200
225	225
250	250
275	275
300	300
325	325
350	350
375	375
400	400
425	425
450	450
475	475
500	500
525	525
550	550
575	575
600	600
625	625
650	650
675	675
700	700
725	725
750	750
775	775
800	800
825	825
850	850
875	875
900	900
925	925
950	950
975	975
1000	1000

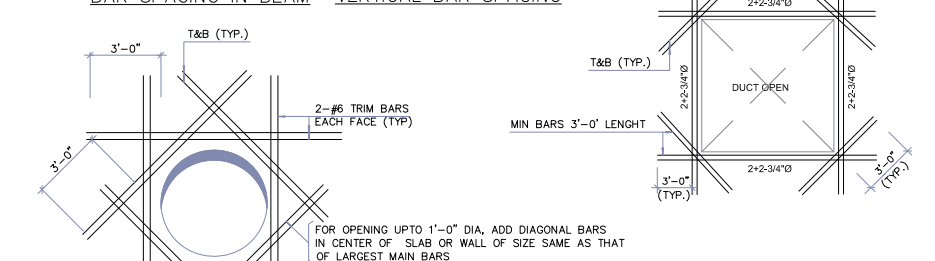


TYP. DUCT OPENING DETAIL

NOTES

WHERE BAR EXTENSION CAN NOT
BE OBTAINED, EXTEND BARS
AS FAR AS POSSIBLE & HOOK

MAXIMUM DIAMETER OF SLEEVE IS 1'-0", FOR TRIM BARS
AROUND LARGE SLEEVE REFER TO OTHER DETAIL.

REINFORCEMENT AROUND SLEEVE IN SLAB & WALLS (TYP)

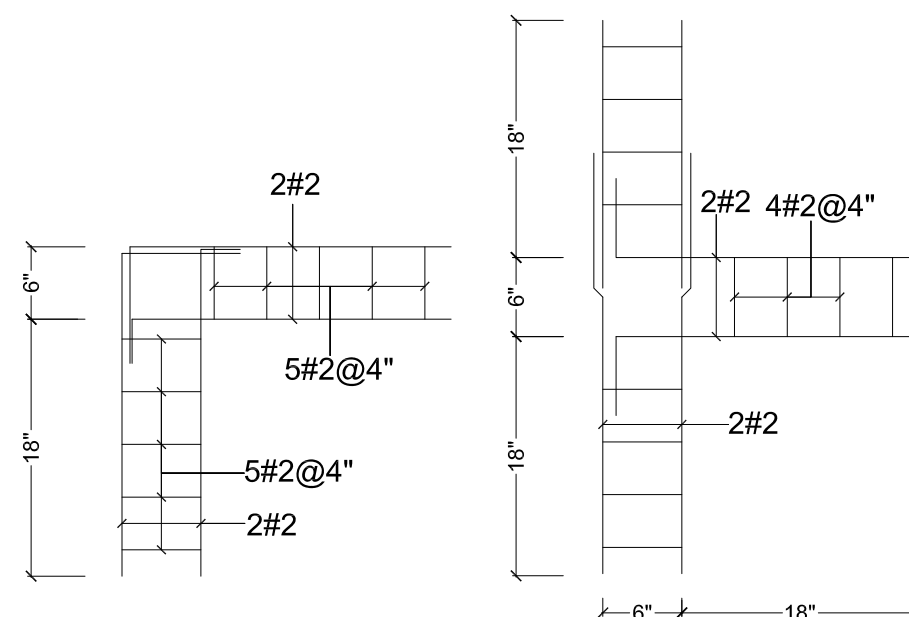

PLAN OF BRICK WALL TIE FOR CORNER JOINT

PLAN OF BRICK WALL TIE FOR T- JOINT

ADDITION & REVISION					
ADD./REV. NO.	DATE	DESCRIPTION	DWG. BY	CHK. BY	APP. BY



NEW VISION ENGINEERING CONSULTANT
 Head Office: Office No.B-6 SECOND FLOOR Masood Arcade
 IJP Road Islamabad.
 Ph: +92-51-4848375, Fax: +92-51-4848375
 Email: newvisionec@yahoo.com
 Regional Office: 287-A Street # 6, Cavalry Ground ,Lahore
 Ph: +92-42-37250130

PROJECT:

**"PROVISION OF MISSING FACILITIES FOR THE
SHAIKH AYAZ UNIVERSITY SHIKARPUR"**

TITLE:

GENERAL NOTES

CLIENT:

SHAIKH AYAZ UNIVERSITY SHIKARPUR

DESIGNED BY:

APPROVED BY:

DATE: AUG. 2022






DRAWN BY:

	JOB NO.
--	---------

SCALE:

DRG. NO.

ST-02

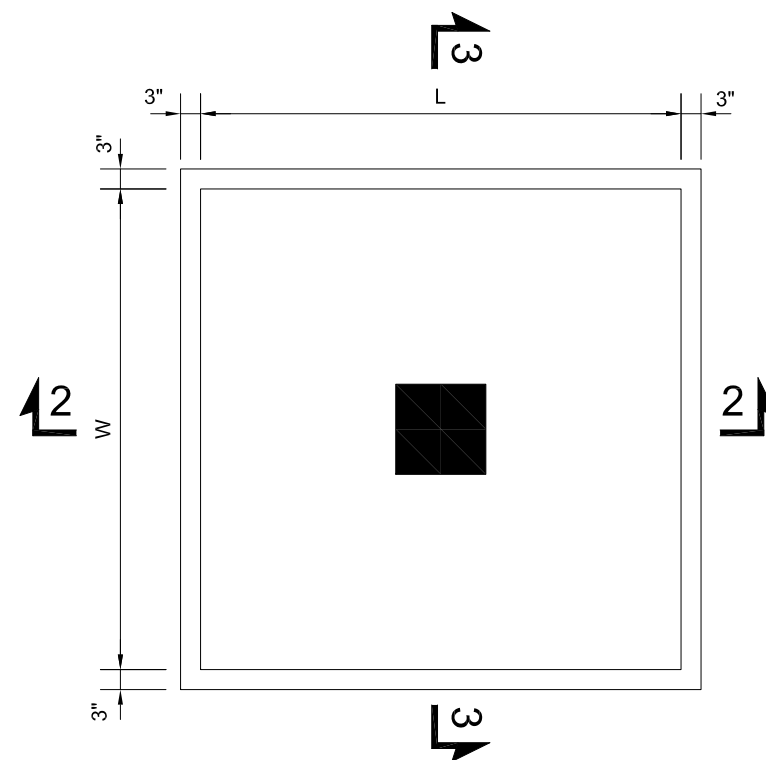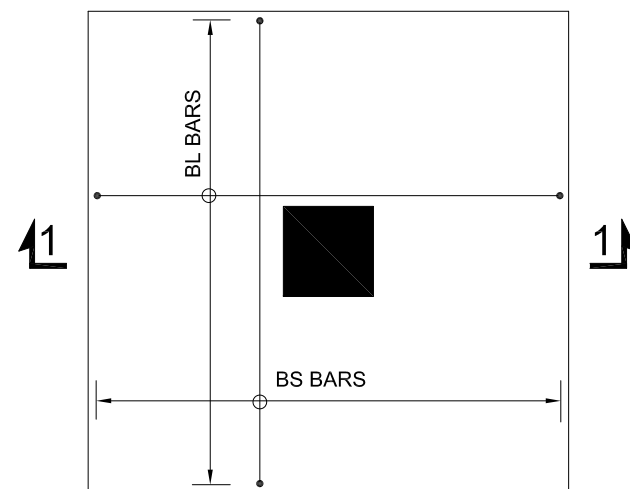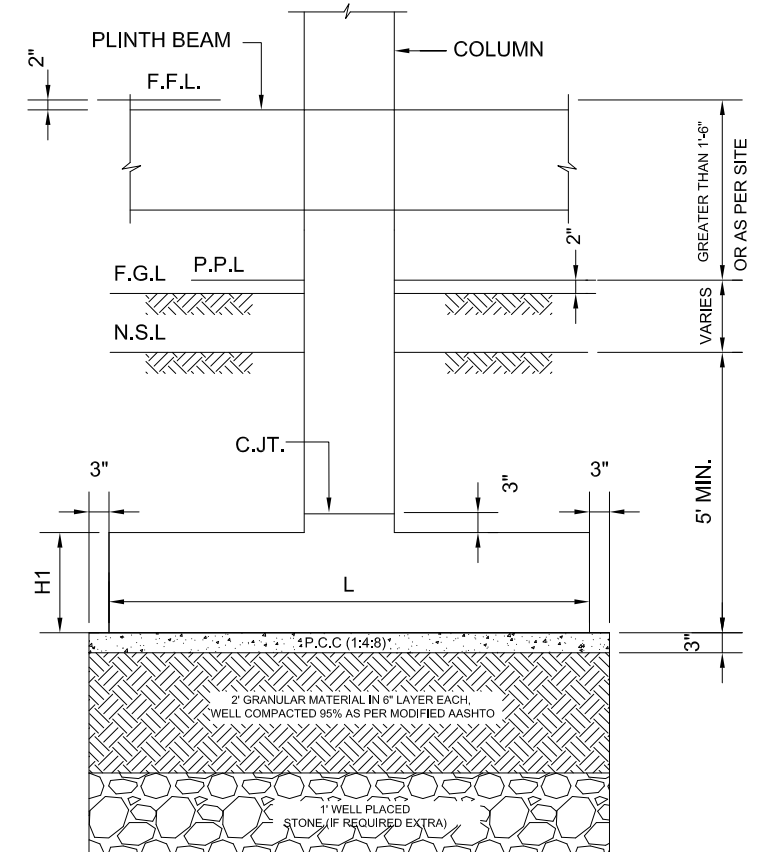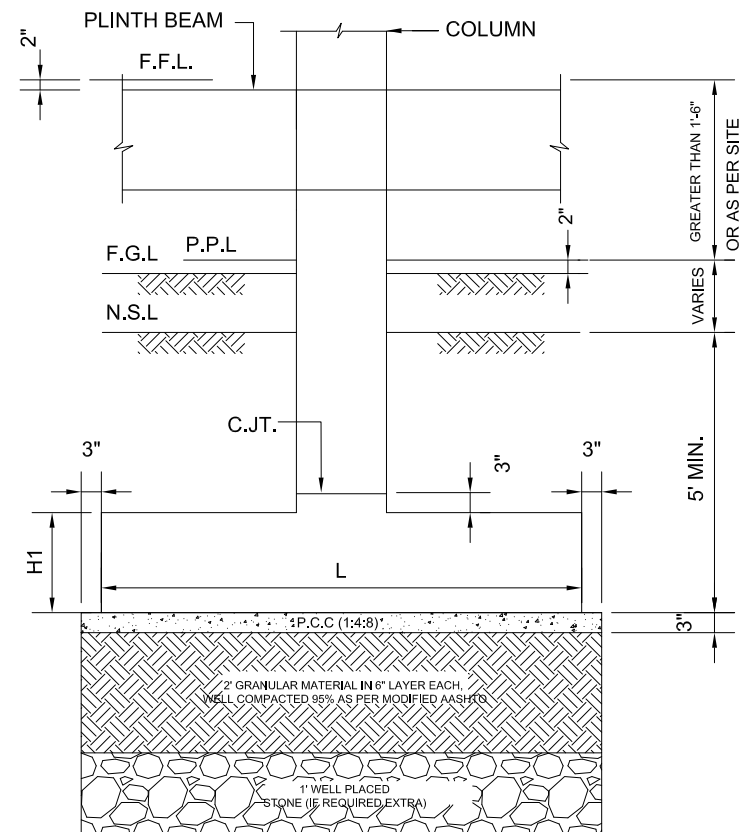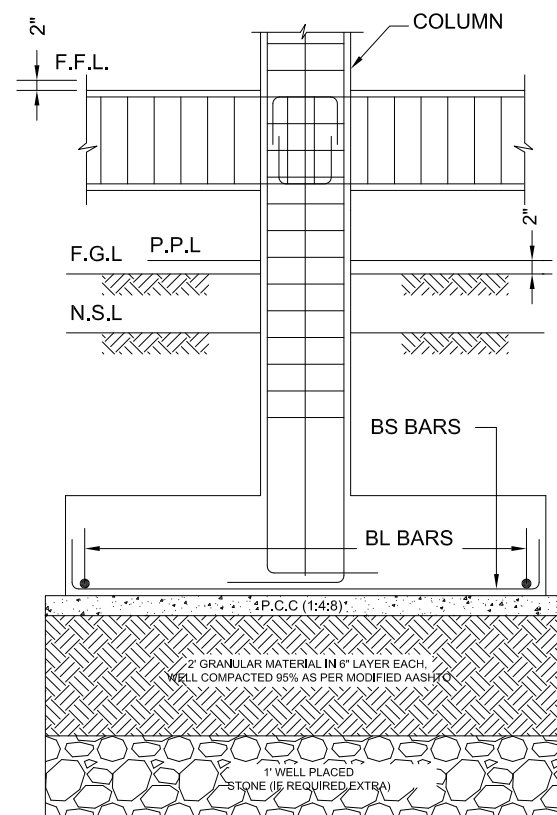

ADDITION & REVISION					
ADD./REV. NO.	DATE	DESCRIPTION	DES. BY	CHK. BY	APP. BY




NEW VISION ENGINEERING CONSULTANTS

Head Office: Office No-83, SECOND FLOOR Masood Arcade
Head Office: Office No-96, 7th Floor Masood Arcade
1JP Road Islampabad
Pk+92-51404675, Karachi-2810-Fax+92-51404675
Email:nnewvisionee@yahom.com


Regional Office: 2874 Street # 6, Gerdary Compound Lahore
Pak+92-4242(8795)30

PROJECT:	"PROVISION OF MISSING FACILITIES FOR THE SHAikh AYAZ UNIVERSITY SHIKARPUR"
TITLE:	FOUNDATION SECTION

CLIENT:		
SHAIKH AYAZ UNIVERSITY SHIKARPUR		
DESIGNED BY: ENG. DANISH	APPROVED BY:	DATE : AUG, 2022
DRAWN BY: HAMZA MUJAHID	JOB NO.	SCALE: N.T.S
DRG. NO.		ST-08

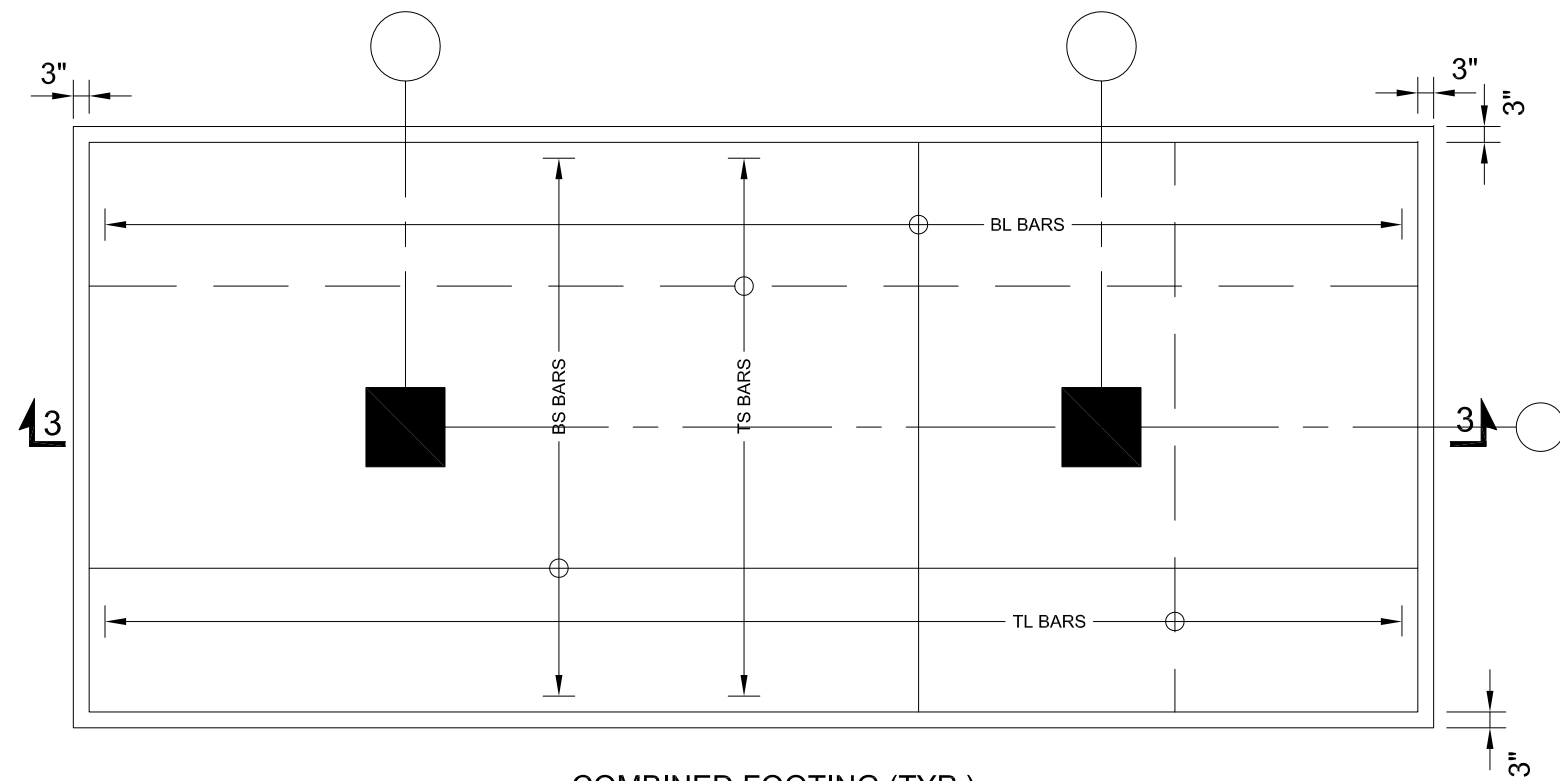

COMBINED FOOTING (TYP.)
REINFORCEMENT DETAILS

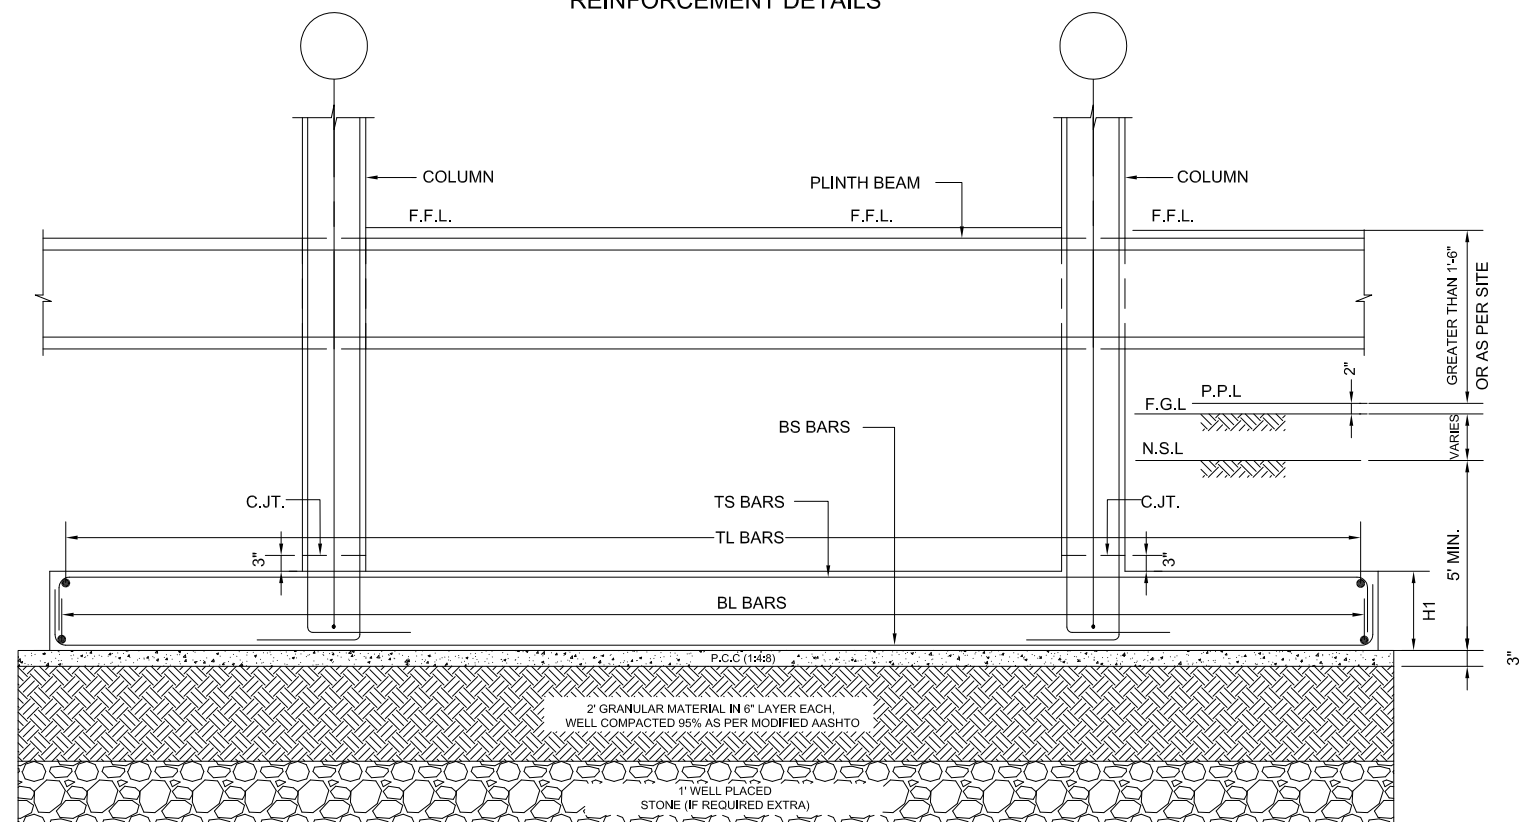

SECTION 3-3




ADDITION & REVISION					
ADD./REV. NO.	DATE	DESCRIPTION	DES. BY	CHK. BY	APP. BY



NEW VISION ENGINEERING CONSULTANT
 Head Office: Office No.B-6 SECOND FLOOR Masood Arcade
 IJP Road Islamabad.
 Ph: +92-51-4848375, Fax: +92-51-4848375
 Email: newvisionec@yahoo.com
 Regional Office: 287-A Street # 6, Cavalry Ground ,Lahore
 Ph: +92-42-37250130

PROJECT:	"PROVISION OF MISSING FACILITIES FOR THE SHAIKH AYAZ UNIVERSITY SHIKARPUR"	
TITLE:	FOUNDATION SECTION	


CLIENT: SHAIKH AYAZ UNIVERSITY SHIKARPUR		
DESIGNED BY: ENG. DANISH	APPROVED BY:	DATE : AUG, 2022
DRAWN BY: HAMZA MUJAHID	JOB NO.	SCALE: N.T.S
DRG. NO.	ST-09	

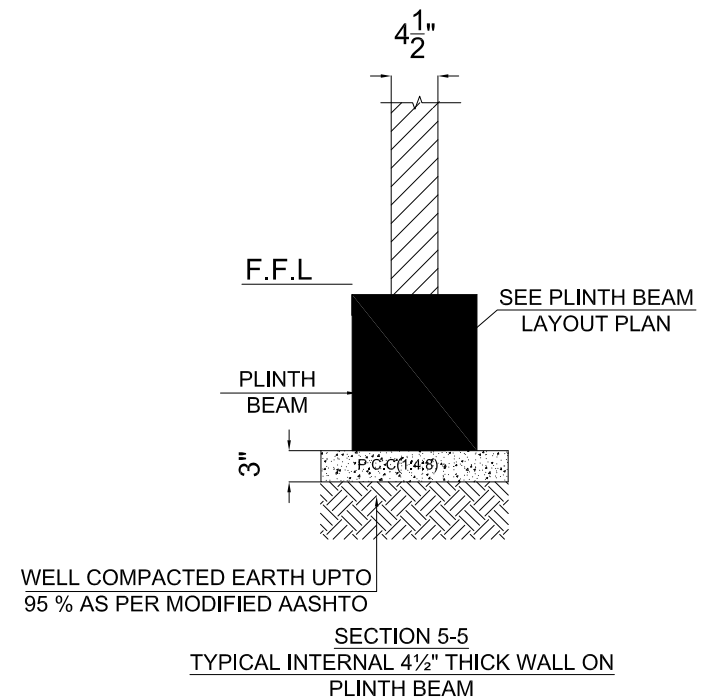  


NEW VISION ENGINEERING CONSULTANTS
 Head Office: Office No.B-6 SECOND FLOOR Masood Arcade
 IJP Road Islamabad.
 Ph: +92-51-4848375, Fax: +92-51-4848375
 Email: newvisionec@yahoo.com
 Regional Office: 287-A Street # 6, Cavalry Ground ,Lahore
 Ph: +92-42-37250130

PROJECT:	"PROVISION OF MISSING FACILITIES FOR THE SHAIKH AYAZ UNIVERSITY SHIKARPUR"
TITLE:	BRICK MASONRY FOOTING SECTION


CLIENT:		
SHAIKH AYAZ UNIVERSITY SHIKARPUR		
DESIGNED BY: ENG. DANISH	APPROVED BY:	DATE : AUG, 2022
DRAWN BY: HAMZA MUJAHID	JOB NO.	SCALE: N.T.S
DRG. NO.		ST-11

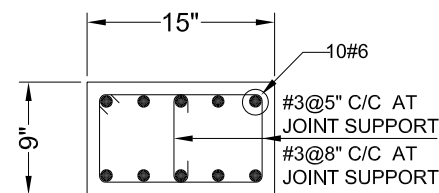


COLUMN
C1

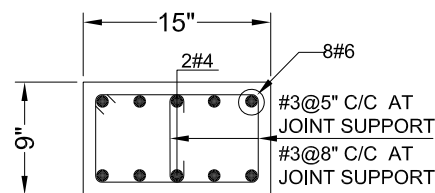


COLUMN
C2

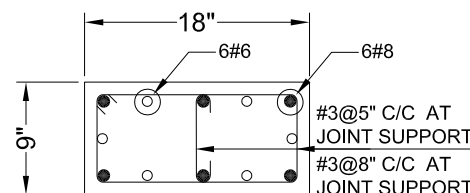


COLUMN
C3

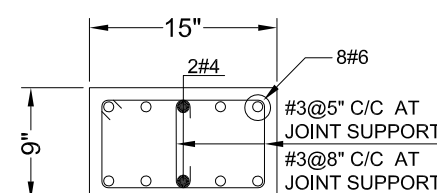


COLUMN
C4

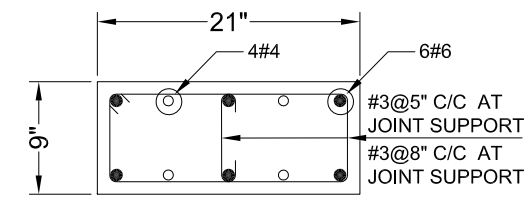


COLUMN
C5

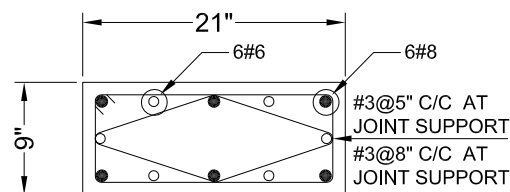


COLUMN
C6

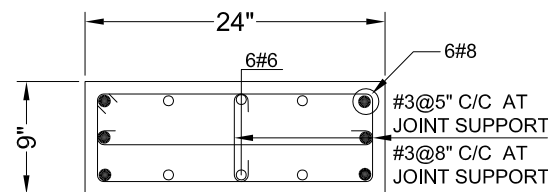


COLUMN
C7

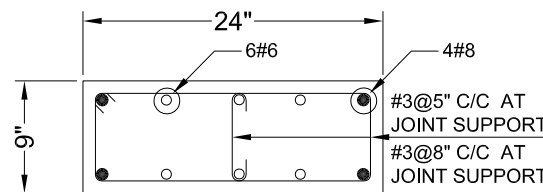


COLUMN
C8

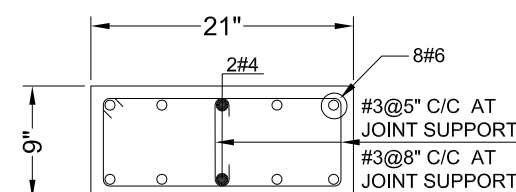


COLUMN
C9

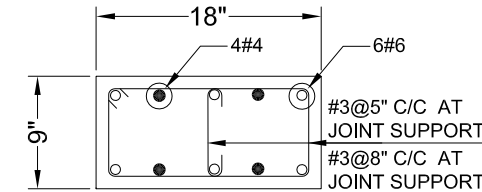


COLUMN
C10

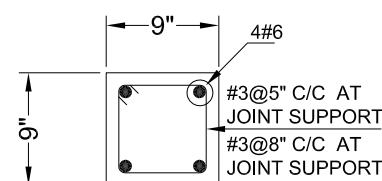


COLUMN
C11

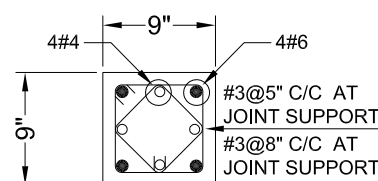


COLUMN
C12

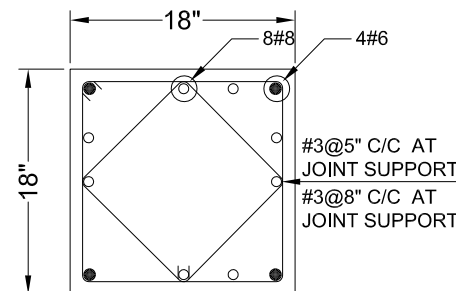


COLUMN
C13

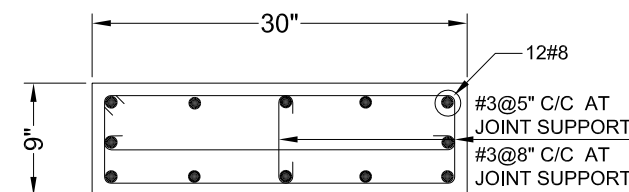


COLUMN
C14

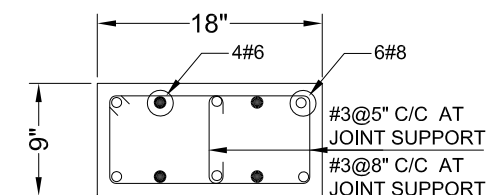


COLUMN
C15

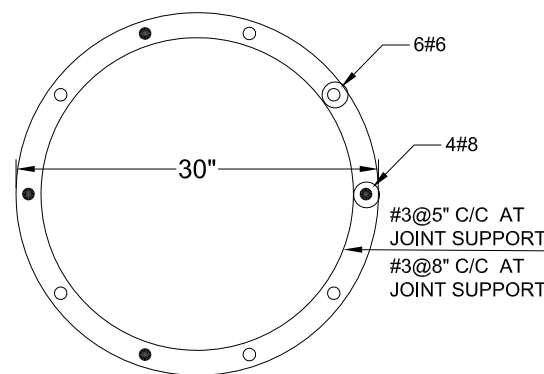

COLUMN AT
BOTTOM C16

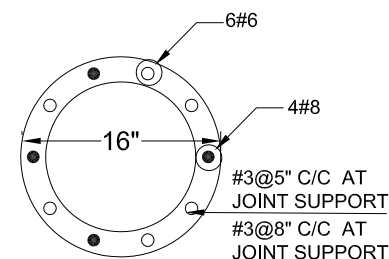

COLUMN AT TOP
C16

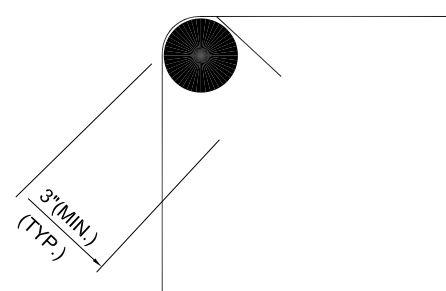

DETAIL 'X'


ADDITION & REVISION					
ADD./REV. NO.	DATE	DESCRIPTION	DES. BY	CHK. BY	APP. BY



NEW VISION ENGINEERING CONSULTANT
 Head Office: Office No.B-6 SECOND FLOOR Masood Arcade
 IJP Road Islamabad.
 Ph: +92-51-4848375, Fax: +92-51-4848375
 Email: newvisionec@yahoo.com
 Regional Office: 287-A Street # 6, Cavalry Ground ,Lahore
 Ph: +92-42-37250130

PROJECT:	"PROVISION OF MISSING FACILITIES FOR THE SHAIKH AYAZ UNIVERSITY SHIKARPUR"	
TITLE:	COLUMN SECTION	

CLIENT:		SHAIKH AYAZ UNIVERSITY SHIKARPUR	
DESIGNED BY:	APPROVED BY:	DATE :	
ENG. DANISH		AUG, 2022	
DRAWN BY:	JOB NO.	SCALE:	
HAMZA MUJAHID		N.T.S	
DRG. NO.		ST-13	

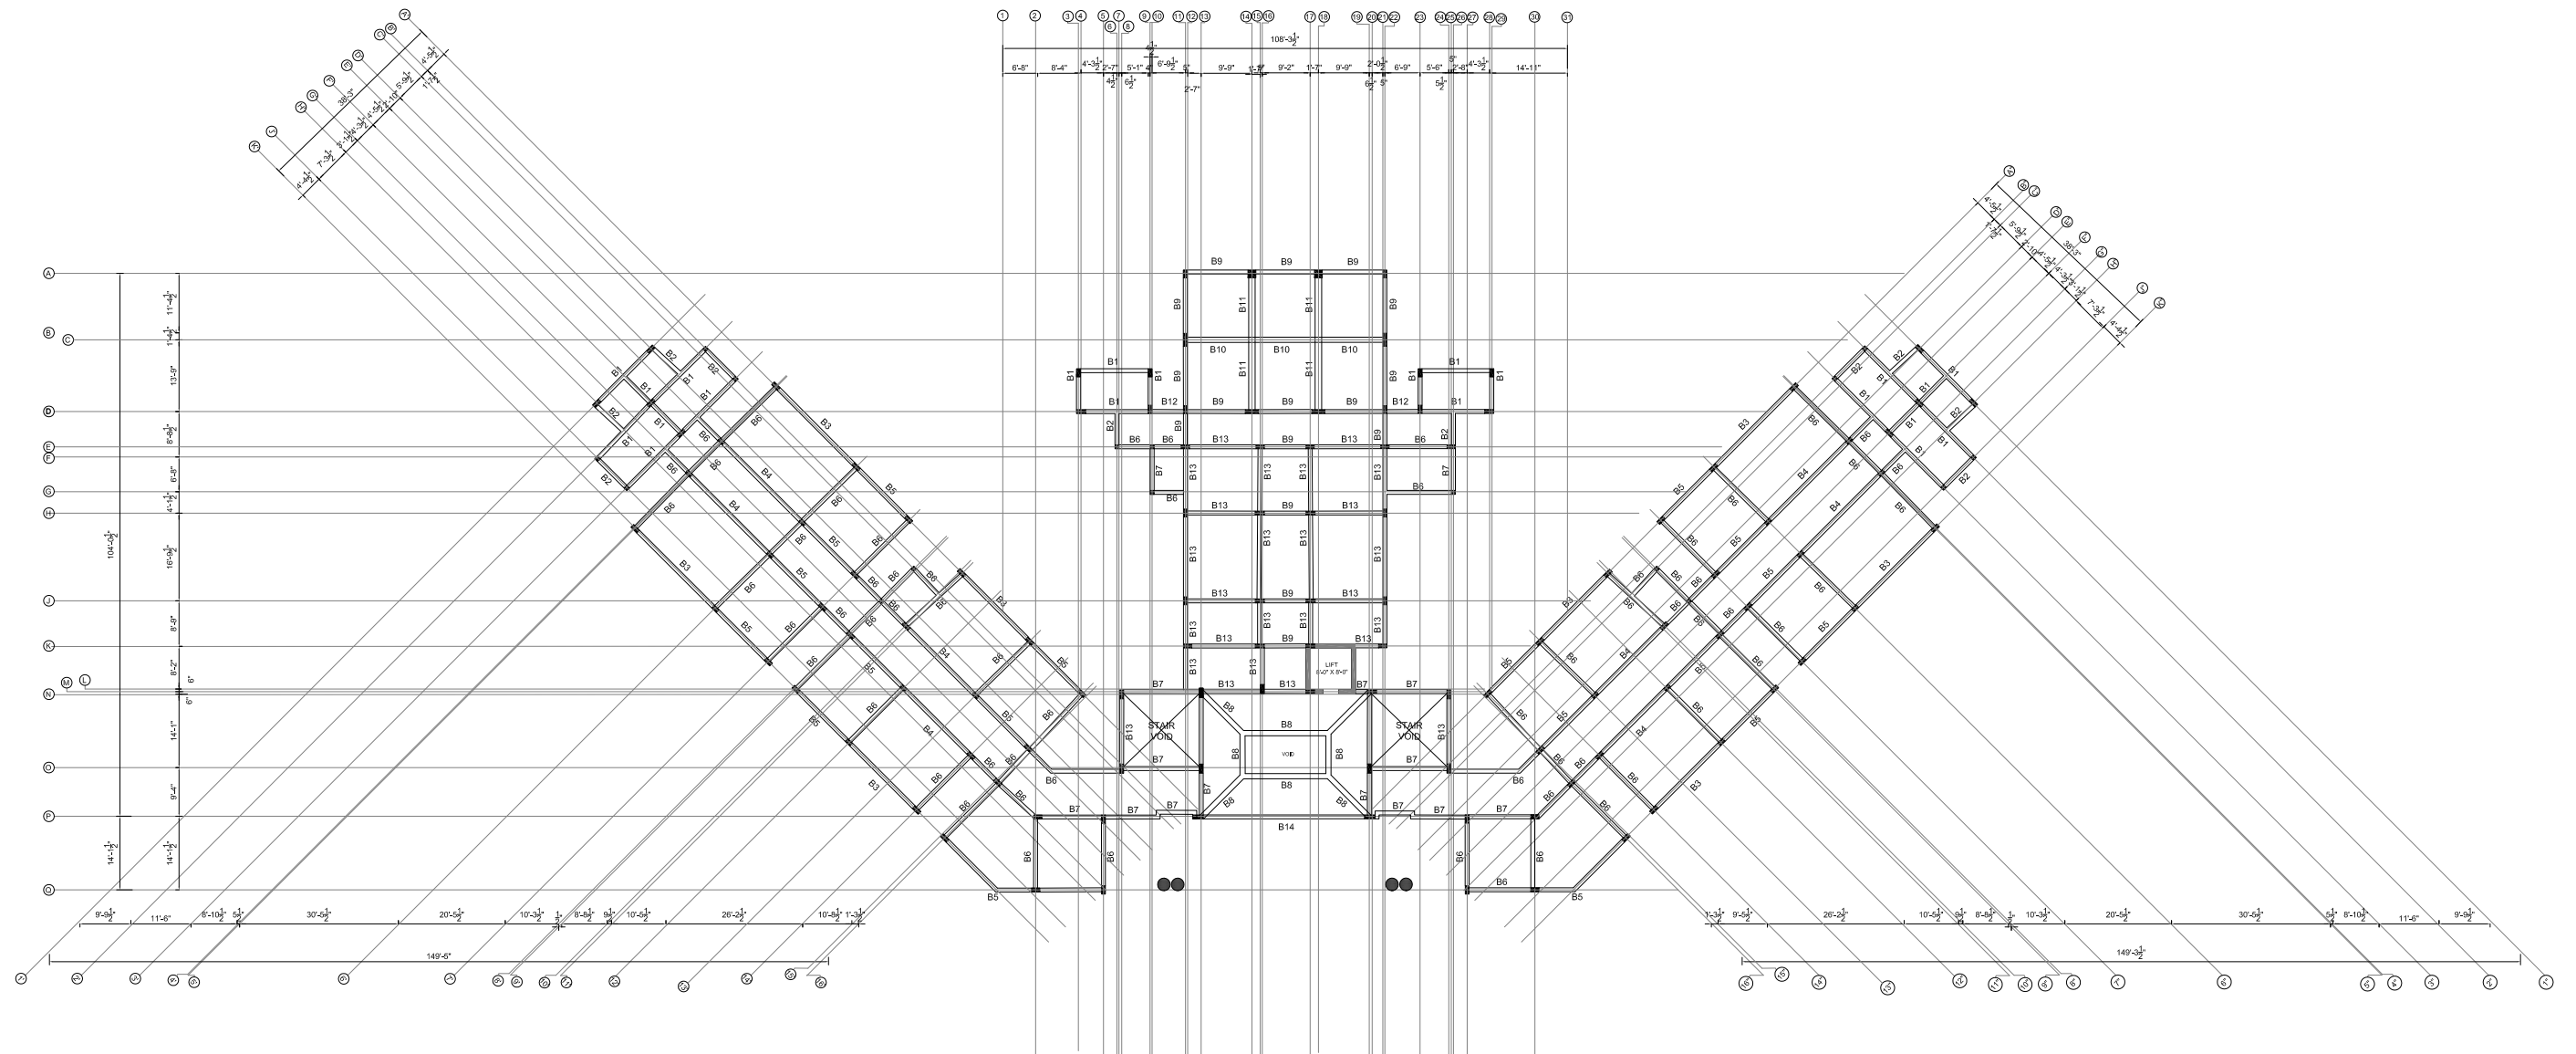


GROUND FLOOR BEAMS LAYOUT PLAN
FOR MORE DETAIL REFER TO ARCHITECTURAL DRAWINGS

ADDITION & REVISION					
ADD./REV. NO.	DATE	DESCRIPTION	DES. BY	CHK. BY	APP. BY



NEW VISION ENGINEERING CONSULTANT
Head Office: Office No.B-6 SECOND FLOOR Masood Arcade
IJP Road Islamabad.
Ph: +92-51-4848375, Fax: +92-51-4848375
Email: newvisionec@yahoo.com
Regional Office: 287-A Street # 6, Cavalry Ground ,Lahore
Ph: +92-42-37250130

PROJECT: "PROVISION OF MISSING FACILITIES FOR THE SHAIKH AYAZ UNIVERSITY SHIKARPUR"		CLIENT: SHAIKH AYAZ UNIVERSITY SHIKARPUR		
TITLE: GROUND FLOOR BEAM LAYOUT PLAN		DESIGNED BY: ENG. DANISH	APPROVED BY:	DATE : AUG, 2022
		DRAWN BY: HAMZA MUJAHID	JOB NO.	SCALE: N.T.S
		DRG. NO. ST-16		

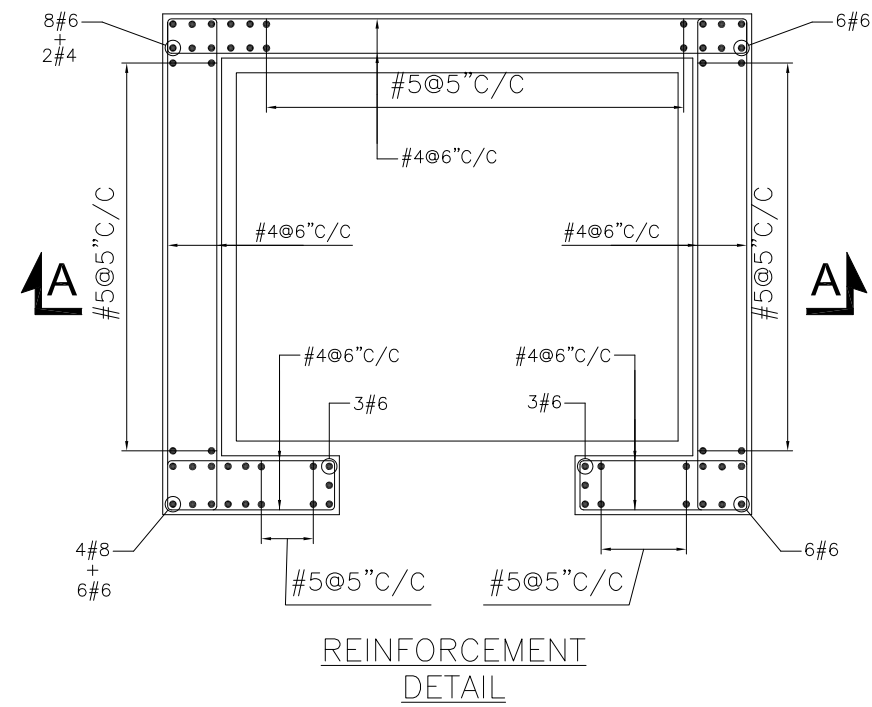

NEW VISION ENGINEERING CONSULTANT
Head Office: Office No.B-6 SECOND FLOOR Masood Arcade
IJP Road Islamabad.
Ph: +92-51-4848375, Fax: +92-51-4848375
Email: newvisionec@yahoo.com
Regional Office: 287-A Street # 6, Cavalry Ground ,Lahore
Ph: +92-42-37250130

PROJECT:

**"PROVISION OF MISSING FACILITIES FOR THE
SHAIKH AYAZ UNIVERSITY SHIKARPUR"**

TITLE:

LIFT DETAIL

CLIENT:	
---------	--

SHAIKH AYAZ UNIVERSITY SHIKARPUR

DESIGNED BY:
ENG. DANISH

APPROVED BY:

DATE :	AUG, 2022
--------	-----------

DRAWN BY:
HAMZA MUJAHID

	JOB NO.
--	---------

SCALE: N.T.S

DRG. NO.	
----------	--

ST-34

GENERAL NOTES

ELECTRICAL SYSTEMS

1. FOLLOWING NOTES SHALL IN GENERAL APPLY TO ALL ELECTRICAL DRAWINGS. THE INSTRUCTIONS IN THESE NOTES SHALL BE FOLLOWED UNLESS STATED OTHERWISE.
2. THESE NOTES SHALL BE APPLICABLE TO THE ENTIRE ELECTRICAL WORKS. IF THE SITE CONDITIONS NECESSITATE ANY ALTERATIONS OR DEVIATIONS THE DIRECTIONS OF THE ENGINEER SHALL BE OBSERVED AS FINAL INSTRUCTIONS.
3. ALL ELECTRICAL DRAWINGS SHALL BE READ IN CONJUNCTION WITH BOQ, TECHNICAL SPECIFICATIONS, ARCHITECTURAL, STRUCTURAL, PLUMBING AND HVAC DRAWINGS & ALL OTHER RELEVANT DETAILS.
4. DIMENSIONS/MEASUREMENTS GIVEN IN LAYOUT AND DETAILED DRAWINGS ARE APPROXIMATE. THE CONTRACTOR SHALL BE RESPONSIBLE TO CALCULATE THE ACTUAL DIMENSIONS/ MEASUREMENTS ACCORDING TO STRUCTURAL AND ARCHITECTURAL DRAWINGS.
5. THE CONTRACTOR SHALL SUBMIT SHOP DRAWINGS WITH ALL RELEVANT DETAILS TO THE ENGINEER FOR APPROVAL ACCORDING TO THE GENERAL CONDITIONS OF CONTRACT WELL IN TIME BEFORE COMMENCEMENT OF THAT WORK.
6. PROPER CO-ORDINATION OF ELECTRICAL WORKS WITH OTHER SERVICES SHALL BE CARRIED OUT AT SITE.
7. ALL NON - CURRENT CARRYING PARTS i.e. OUTER CASINGS OF EQUIPMENT SUCH AS HT & LT PANELS, DISTRIBUTIONS BOARDS, CABLE TRAYS, AUXILIARY CONSTRUCTIONS FOR EQUIPMENT ETC. SHALL BE CONNECTED TO THE GROUNDING/ EARTHING SYSTEM AT REQUIRED NUMBER OF POINTS WITH SPECIFIED SIZES OF CONDUCTORS. WATER PIPES ALONG ELECTRICAL LINE SHALL BE BONDED TO THE EARTHING SYSTEM WITH 10 sq.mm. SINGLE CORE, COPPER CONDUCTOR PVC CABLE.
8. ELECTRICAL POINTS FOR EQUIPMENT SHALL BE INSTALLED IN CO-ORDINATION WITH THE RELEVANT DRAWINGS OF OTHER SERVICES, SUCH AS COMMUNICATION SYSTMS, HVAC, PLUMBING ETC. THE LOCATION ON ELECTRICAL DRAWINGS IS ONLY INDICATIVE.
9. ARRANGEMENT OF ELECTRICAL EQUIPMENTS ON ELECTRICAL DRAWINGS ARE TENTATIVE. EXACT ARRANGEMENT OF EQUIPMENTS SHALL BE MADE IN VIEW OF ITS PHYSICAL DIMENSIONS AND EASE OF MAINTENANCE. AND AS PER SITE REQUIREMENTS.
10. LOADS ON ALL PHASES SHALL BE BALANCED AT THE TESTING/ COMMISSIONING STAGE.
11. CONDUIT/DUCT RUN UNDER FLOOR SHALL HAVE A MINIMUM COVER OF TWO INCHES FROM TOP OF CONDUIT/DUCT TO FINISH FLOOR LEVEL.
12. RUN GREEN-YELLOW OR GREEN SINGLE CORE PVC INSULATED COPPER CONDUCTOR CABLE OF SPECIFIED SIZES AS PROTECTIVE EARTH CONDUCTOR (ECC) ALL ALONG LIGHT AND POWER WIRING. WHEREVER THE SIZE IS NOT SPECIFIED THE FOLLOWING CRITERIA SHALL BE OBSERVED TO DETERMINE MINIMUM CROSS SECTIONAL AREA OF EARTH CONTINUITY CONDUCTOR (ECC) IN RELATION TO THE AREA OF ITS PHASE CONDUCTORS. RUN SEPARATE ECC FOR EACH CIRCUIT.
- ECC & PHASE CONDUCTOR OF SAME SIZE FOR UPTO AND INCLUDING 16 SQMM CABLES
 - 16 SQMM ECC FOR PHASE CONDUCTOR OF 16 SQMM, 25SQMM & 35 SQMM CABLES
 - FOR CABLES OF 50 SQMM AND ABOVE SIZES, ECC IS HALF SIZE OF PHASE CONDUCTOR.
 - MAXIMUM SIZE OF ECC IS 70 SQMM.

ELECTRICAL SYSTEMS

13. THE MAXIMUM CAPACITY OF PVC CONDUITS FOR SIMULTANEOUS DRAWING OF PVC INSULATED CABLES SHALL BE DETERMINED AS PER BS 4607. THE FOLLOWING TABLE SHALL BE USED TO DETERMINE THE MAXIMUM NUMBER OF CABLES.

S. #	NOMINAL CONDUCTOR SIZE(SQMM)	NO. & DIA OF WIRES	NOMINAL OVERALL DIA	20 MM DIA (3/4" DIA)	25 MM DIA (1" DIA)	32 MM DIA (1 1/4" DIA)
1	1.5	1/1.38	3.1	10	18	30
2	2.5	1/1.78	3.5	8	14	23
3	2.5	7/0.67	3.8	7	12	20
4	4	7/0.85	4.3	5	9	15
5	6	7/1.04	4.9	4	7	12
6	10	7/1.35	6.2	2	4	7
7	16	7/1.70	7.3	-	3	5
8	25	7/2.14	9.0	-	2	3
9	35	19/1.53	10.3	-	-	2

14. NORMAL & EMERGENCY CIRCUITS SHALL RUN IN SEPARATE CONDUITS.

15. ALL WIRING FOR CONTROLS SHALL BE CARRIED OUT WITH 1 CORE PVC CABLES OF SPECIFIED VOLTAGE GRADE AND SIZES.

16. THE WIRING SHALL BE CONTINUOUS LOOPING-IN TYPE AND NO JOINT IN WIRES SHALL BE ALLOWED.

17. THE WIRING SYSTEM SHALL BE CARRIED OUT ONLY AFTER THE CONDUIT SYSTEM IS COMPLETELY INSTALLED AND ALL OUTLET BOXES, ETC. ARE FIXED IN POSITION.

18. MOUNTING HEIGHTS OF ELECTRICAL FITTINGS WHEN MEASURED FROM FINISHED FLOOR LEVEL (F.F.L.) TO THE BOTTOM OF FITTINGS SHALL BE AS UNDER, UNLESS OTHERWISE SHOWN OR INSTRUCTED.

MAIN SWITCH BOARD	48 INCHES
DISTRIBUTION BOARD	48 INCHES
CONTROL PANEL	48 INCHES
ON/OFF PUSH BUTTON STATION	48 INCHES
DIMMER CONTROL UNIT	48 INCHES
LIGHT CONTROL SWITCH(ONE WAY/TWO WAY)	48 INCHES
5A SOCKET OUTLETS IN GENERAL AREAS	10 INCHES
15A SOCKET OUTLETS IN GENERAL AREAS	10 INCHES
20A SOCKET OUTLETS IN GENERAL AREAS	10 INCHES
15A SOCKET OUTLETS IN KITCHEN (ABOVE COUNTER)	10 INCHES
15A SOCKET OUTLETS IN TOILETS	66 INCHES
16A TP 5PIN INDUSTRIAL SOCKET OUTLETS IN LABS.	48 INCHES
32A TP 5PIN INDUTRIAL SOCKET OUTLETS IN LABS	48 INCHES
63A TP 5PIN INDUTRIAL SOCKET OUTLETS IN LABS.	48 INCHES
CEILING FAN	96 INCHES
WALL FAN	84 INCHES
EXHAUST FAN	REFER ARCH. DRGS.

COMMUNICATION SYSTEMS

1. FOLLOWING NOTES SHALL IN GENERAL APPLY TO ALL COMMUNICATION SYSTEMS DRAWINGS. THE INSTRUCTIONS IN THESE NOTES SHALL BE FOLLOWED UNLESS STATED OTHERWISE.
2. THESE NOTES SHALL BE APPLICABLE TO THE ENTIRE COMMUNICATION SYSTEMS WORKS. IF THE SITE CONDITIONS NECESSITATE ANY ALTERATIONS OR DEVIATIONS THE DIRECTIONS OF THE ENGINEER SHALL BE OBSERVED AS FINAL INSTRUCTIONS.
3. ALL COMMUNICATION SYSTEMS DRAWINGS SHALL BE READ IN CONJUNCTION WITH TECHNICAL SPECIFICATIONS, ITEMS OF B.O.Q., ARCHITECTURAL STRUCTURAL, HVAC, PLUMBING DRAWINGS AND ALL OTHER RELEVANT DETAILS.
4. DIMENSIONS/MEASUREMENTS GIVEN IN LAYOUT AND DETAILED DRAWINGS ARE APPROXIMATE. THE CONTRACTOR SHALL BE RESPONSIBLE TO CALCULATE THE ACTUAL DIMENSIONS/MEASUREMENTS ACCORDING TO STRUCTURAL AND ARCHITECTURAL DRAWINGS.
5. THE CONTRACTOR SHALL SUBMIT SHOP DRAWINGS WITH ALL RELEVANT DETAILS TO THE ENGINEER FOR APPROVAL ACCORDING TO THE GENERAL CONDITIONS OF CONTRACT WELL IN TIME BEFORE COMMENCEMENT OF THAT WORK.
6. PROPER CO-ORDINATION OF COMMUNICATION SYSTEMS WORKS WITH OTHER SERVICES SHALL BE CARRIED OUT AT SITE.
7. TELEPHONE SYSTEM SHALL BE COMPLETE WITH INSTRUMENTS, EQUIPMENT AND INTERCONNECTING WIRING, TELEPHONE EXCHANGE, TELEPHONE OUTLETS, JUNCTION BOXES, CONDUITS OF SPECIFIED SIZES IN THE BUILDING, AND UNDERGROUND PIPES OF SPECIFIED SIZES SHOWN ON DRAWINGS SHALL BE PROVIDED. WHERE SIZE OF CONDUIT/PIPE IS NOT SPECIFIED SUITABLE SIZE SHALL BE INSTALLED AS DIRECTED BY THE ENGINEER.
8. POINTS FOR COMMUNICATION SYSTEMS EQUIPMENT SHALL BE INSTALLED IN CO-ORDINATION WITH THE RELEVANT DRAWINGS OF OTHER SERVICES, SUCH AS ELECTRICAL, HVAC, PLUMBING ETC. THE LOCATION ON COMMUNICATION SYSTEMS DRAWINGS IS ONLY INDICATIVE.
9. ARRANGEMENT OF COMMUNICATION SYSTEMS EQUIPMENTS ON DRAWINGS ARE TENTATIVE EXACT ARRANGEMENT OF EQUIPMENTS SHALL BE MADE IN VIEW OF ITS PHYSICAL DIMENSIONS AND EASE OF MAINTENANCE.
10. CONDUIT/DUCT RUN UNDER FLOOR SHALL HAVE A MINIMUM COVER 2 INCHES FROM TOP OF CONDUIT/DUCT TO FINISH FLOOR LEVEL.
11. RUN GREEN-YELLOW OR GREEN SINGLE CORE PVC INSULATED COPPER CONDUCTOR CABLE OF SPECIFIED SIZES AS PROTECTIVE EARTH CONDUCTOR (ECC) ALL ALONG COMMUNICATION SYSTEMS WIRING.
12. ALL WIRING FOR CONTROLS SHALL BE CARRIED OUT WITH 1 CORE PVC CABLES OF SPECIFIED VOLTAGE GRADE AND SIZES.
13. THE WIRING SHALL BE CONTINUOUS LOOPING-IN TYPE AND NO JOINT IN WIRES SHALL BE ALLOWED.
14. THE WIRING SYSTEM SHALL BE CARRIED OUT ONLY AFTER THE CONDUIT SYSTEM IS COMPLETELY INSTALLED AND ALL OUTLET BOXES, ETC. ARE FIXED IN POSITION.
15. MOUNTING HEIGHTS OF ELECTRICAL FITTINGS WHEN MEASURED FROM FINISHED FLOOR LEVEL (F.F.L.) TO THE BOTTOM OF FITTINGS SHALL BE AS UNDER, UNLESS OTHERWISE SHOWN OR INSTRUCTED.
- | | |
|---------------------------------|------------|
| TELEPHONE JUNCTION BOX | 10 INCHES |
| TELEPHONE OUTLET | 10 INCHES |
| INTERCOM CONTROL PACK | 10 INCHES |
| INTERCOM STATION (WALL MOUNTED) | 36 INCHES |
| FA SYSTEM CONTROL PANEL | 36 INCHES |
| FA SYSTEM JUNCTION BOX | 10 INCHES |
| MANUAL CALL STATION | 42 INCHES |
| AUDIO ALARM | 100 INCHES |

ADDITION & REVISION					
ADD./REV. NO.	DATE	DESCRIPTION	DES. BY	CHK. BY	APP. BY

DESIGNER:



NEW VISION ENGINEERING CONSULTANT

Head Office: Office No.B-6 SECOND FLOOR Masood Arcade IJP Road Islamabad.

Ph: +92-51-4848375, Fax: +92-51-4848375

Email: newvisionec@yahoo.com

Regional Office: 287-A Street # 6, Cavalry Ground ,Lahore

Ph: +92-42-37250130

PROJECT:

"PROVISION OF MISSING FACILITIES FOR THE SHAIKH AYAZ UNIVERSITY SHIKARPUR"

TITLE:

ADMINISTRATION BLOCK

GENERAL NOTES

CAD filename:

CLIENT:

SHAIKH AYAZ UNIVERSITY SHIKARPUR

DESIGNED BY:

Mr. Shadab

APPROVED BY:

S A

DATE :

AUGUST, 2022

DRAWN BY:

Mr.RANA ALI HAIDER

JOB NO.

SCALE:

N.T.S

DRG. NO.

EL-01



"PROVISION OF MISSING FACILITIES FOR THE SHAIKH AYAZ UNIVERSITY SHIKARPUR"



BOOK SHOP & TUCK SHOPS VOLUME III TENDER DRAWINGS DECEMBER, 2022

DESIGN BY



NEW VISION ENGINEERING CONSULTANT

HEAD OFFICE:

Office No.B-6 Second Floor Masood Arcade
IJP Road Islamabad.


Ph: +92-51-4848375, Fax: +92-51-4848375

Email: newvisionec@yahoo.com

REGIONAL OFFICE:

287-A Street # 6,
Cavalry Ground ,Lahore

Ph: +92-42-37250130

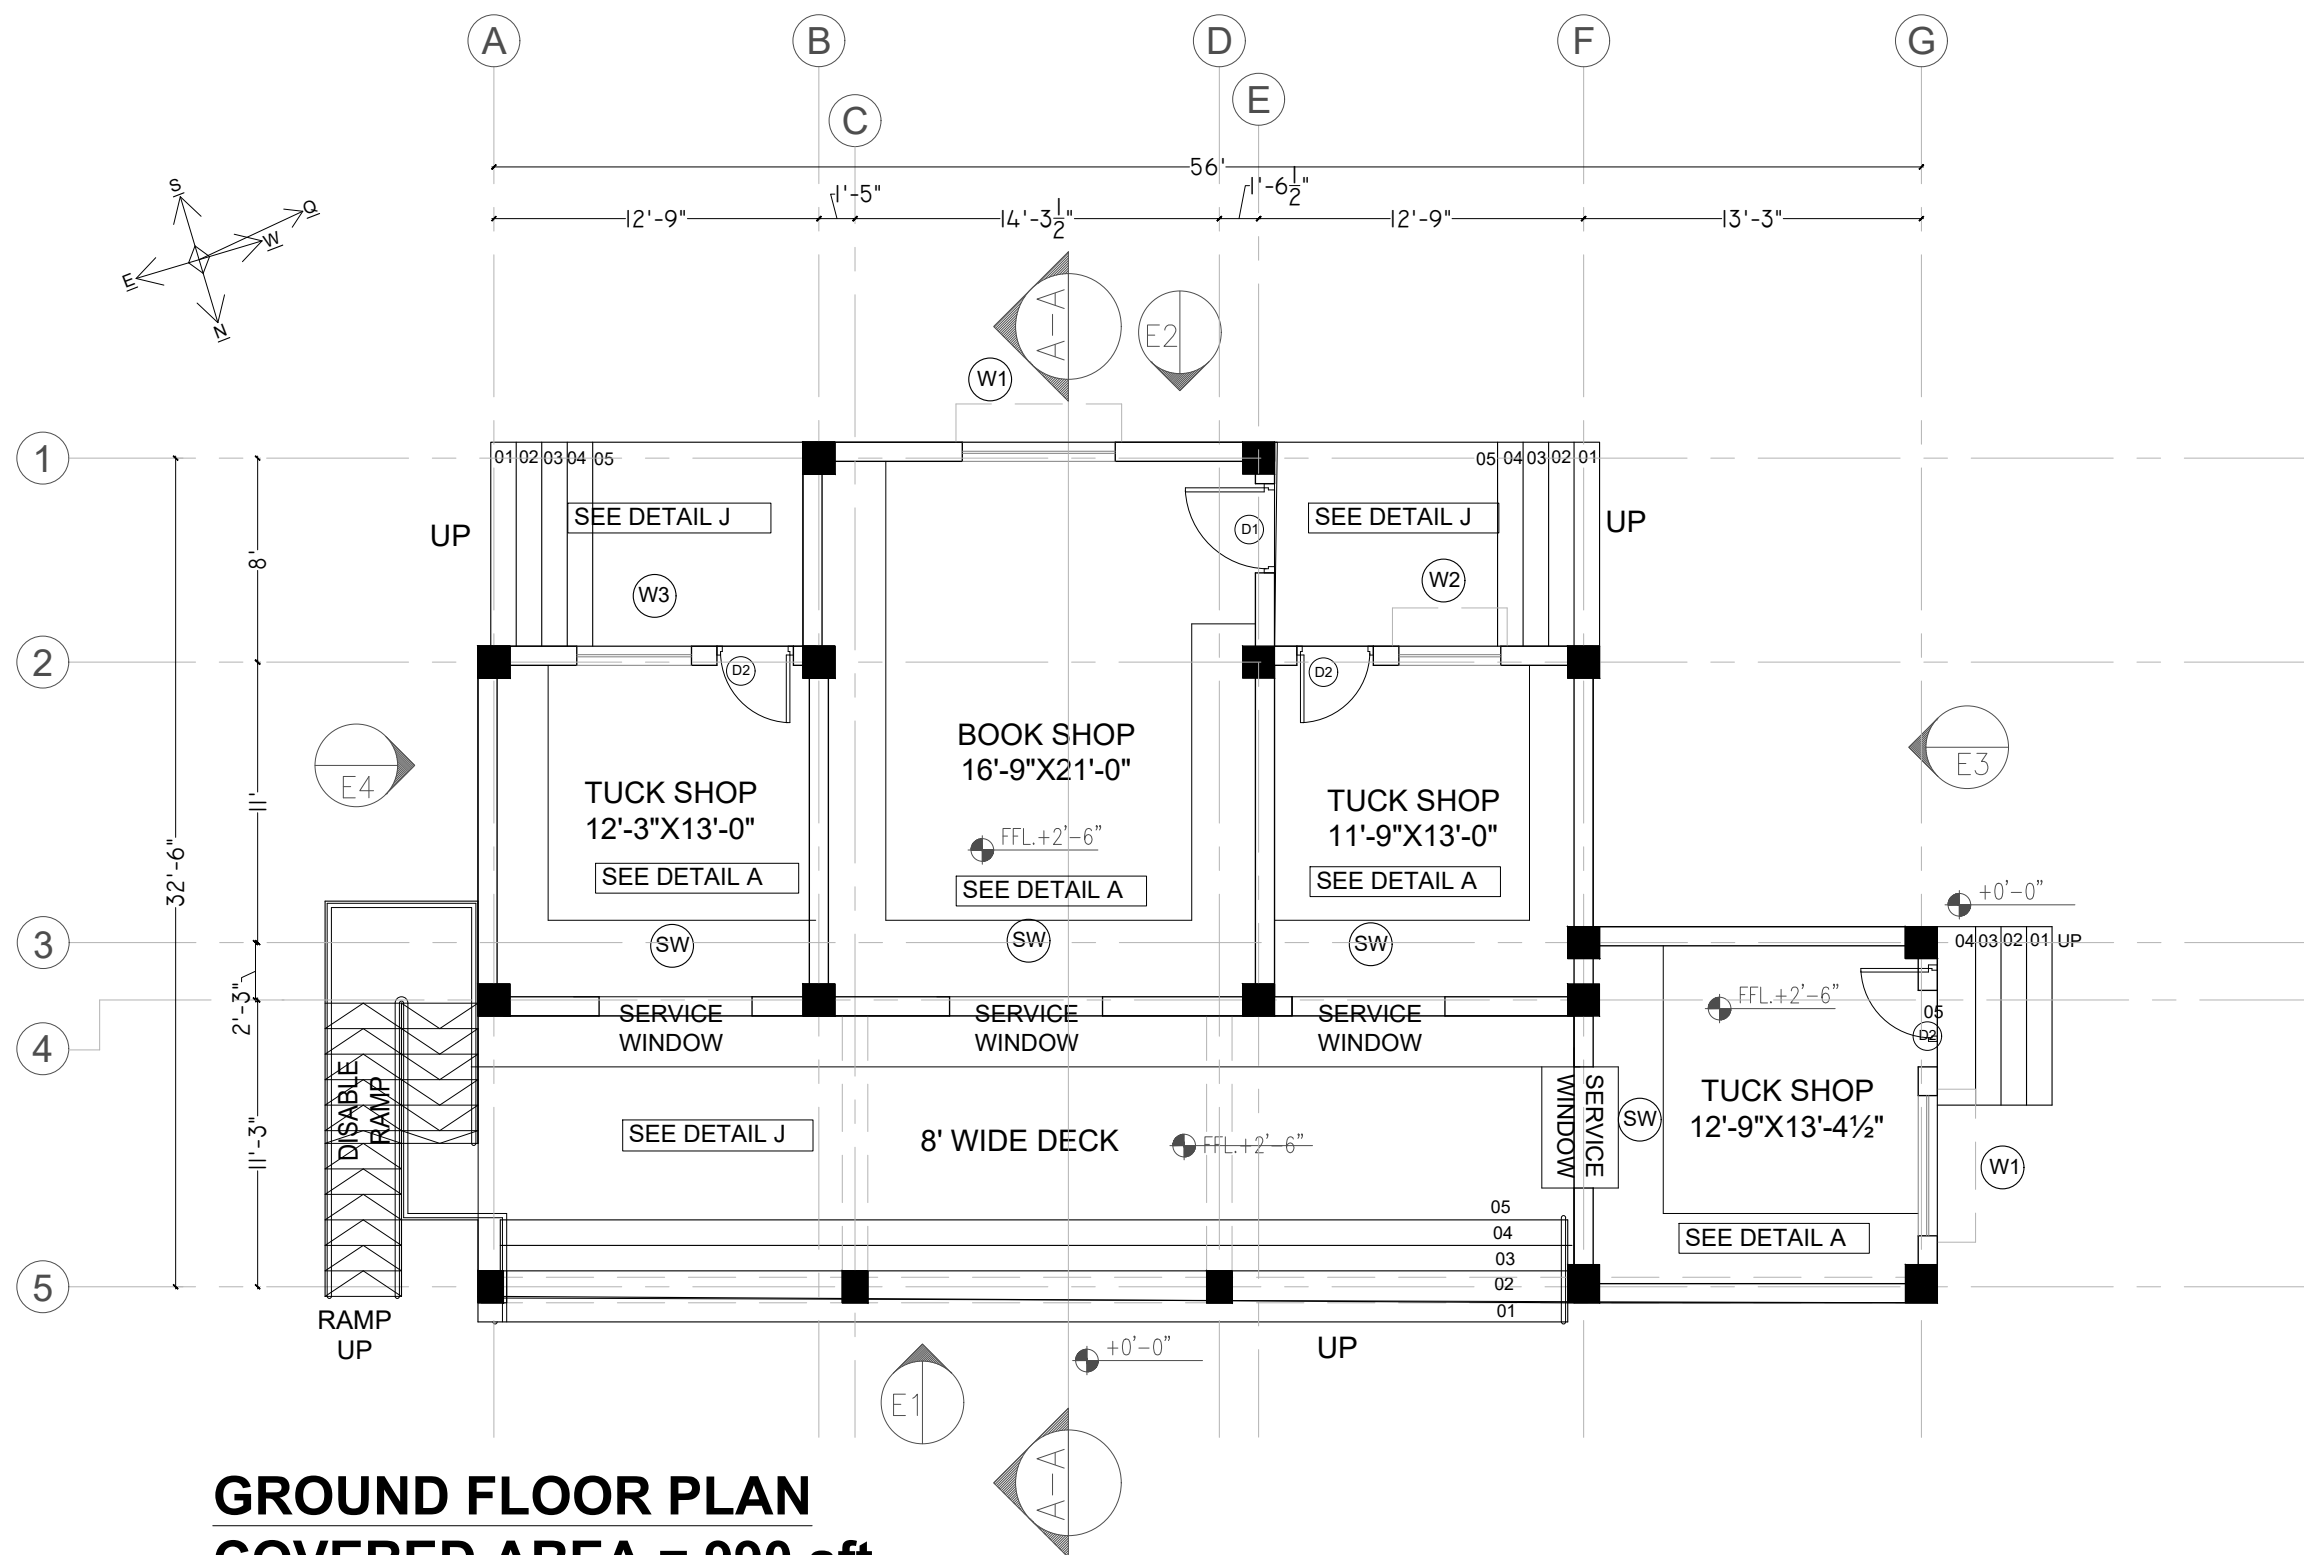

GROUND FLOOR PLAN
COVERED AREA = 990 sft
50% VERANDHA COVERED AREA = 239 SFT
TOTAL COVERED AREA = 1229 SFT


ADDITION & REVISION					
ADD./REV. NO.	DATE	DESCRIPTION	DES. BY	CHK. BY	APP. BY



NEW VISION ENGINEERING CONSULTANT
 Head Office: Office No.B-6 Second Floor Masood Arcade
 IJP Road Islamabad.
 Ph: +92-51-4848375, Fax: +92-51-4848375
 Email: newvisionec@yahoo.com
 Regional Office: 287-A Street # 6, Cavalry Ground ,Lahore
 Ph: +92-42-37250130

PROJECT:	"PROVISION OF MISSING FACILITIES FOR THE SHAIKH AYAZ UNIVERSITY SHIKARPUR"	
TITLE:	GROUND FLOOR PLAN	
CAD filename:		

CLIENT:		SHAIKH AYAZ UNIVERSITY SHIKARPUR	
DESIGNED BY: AR.SALMAN	APPROVED BY:	DATE :	JUNE, 2022
DRAWN BY: RIZWAN	JOB NO.	SCALE:	N.T.S
DRG. NO.		AR-01	

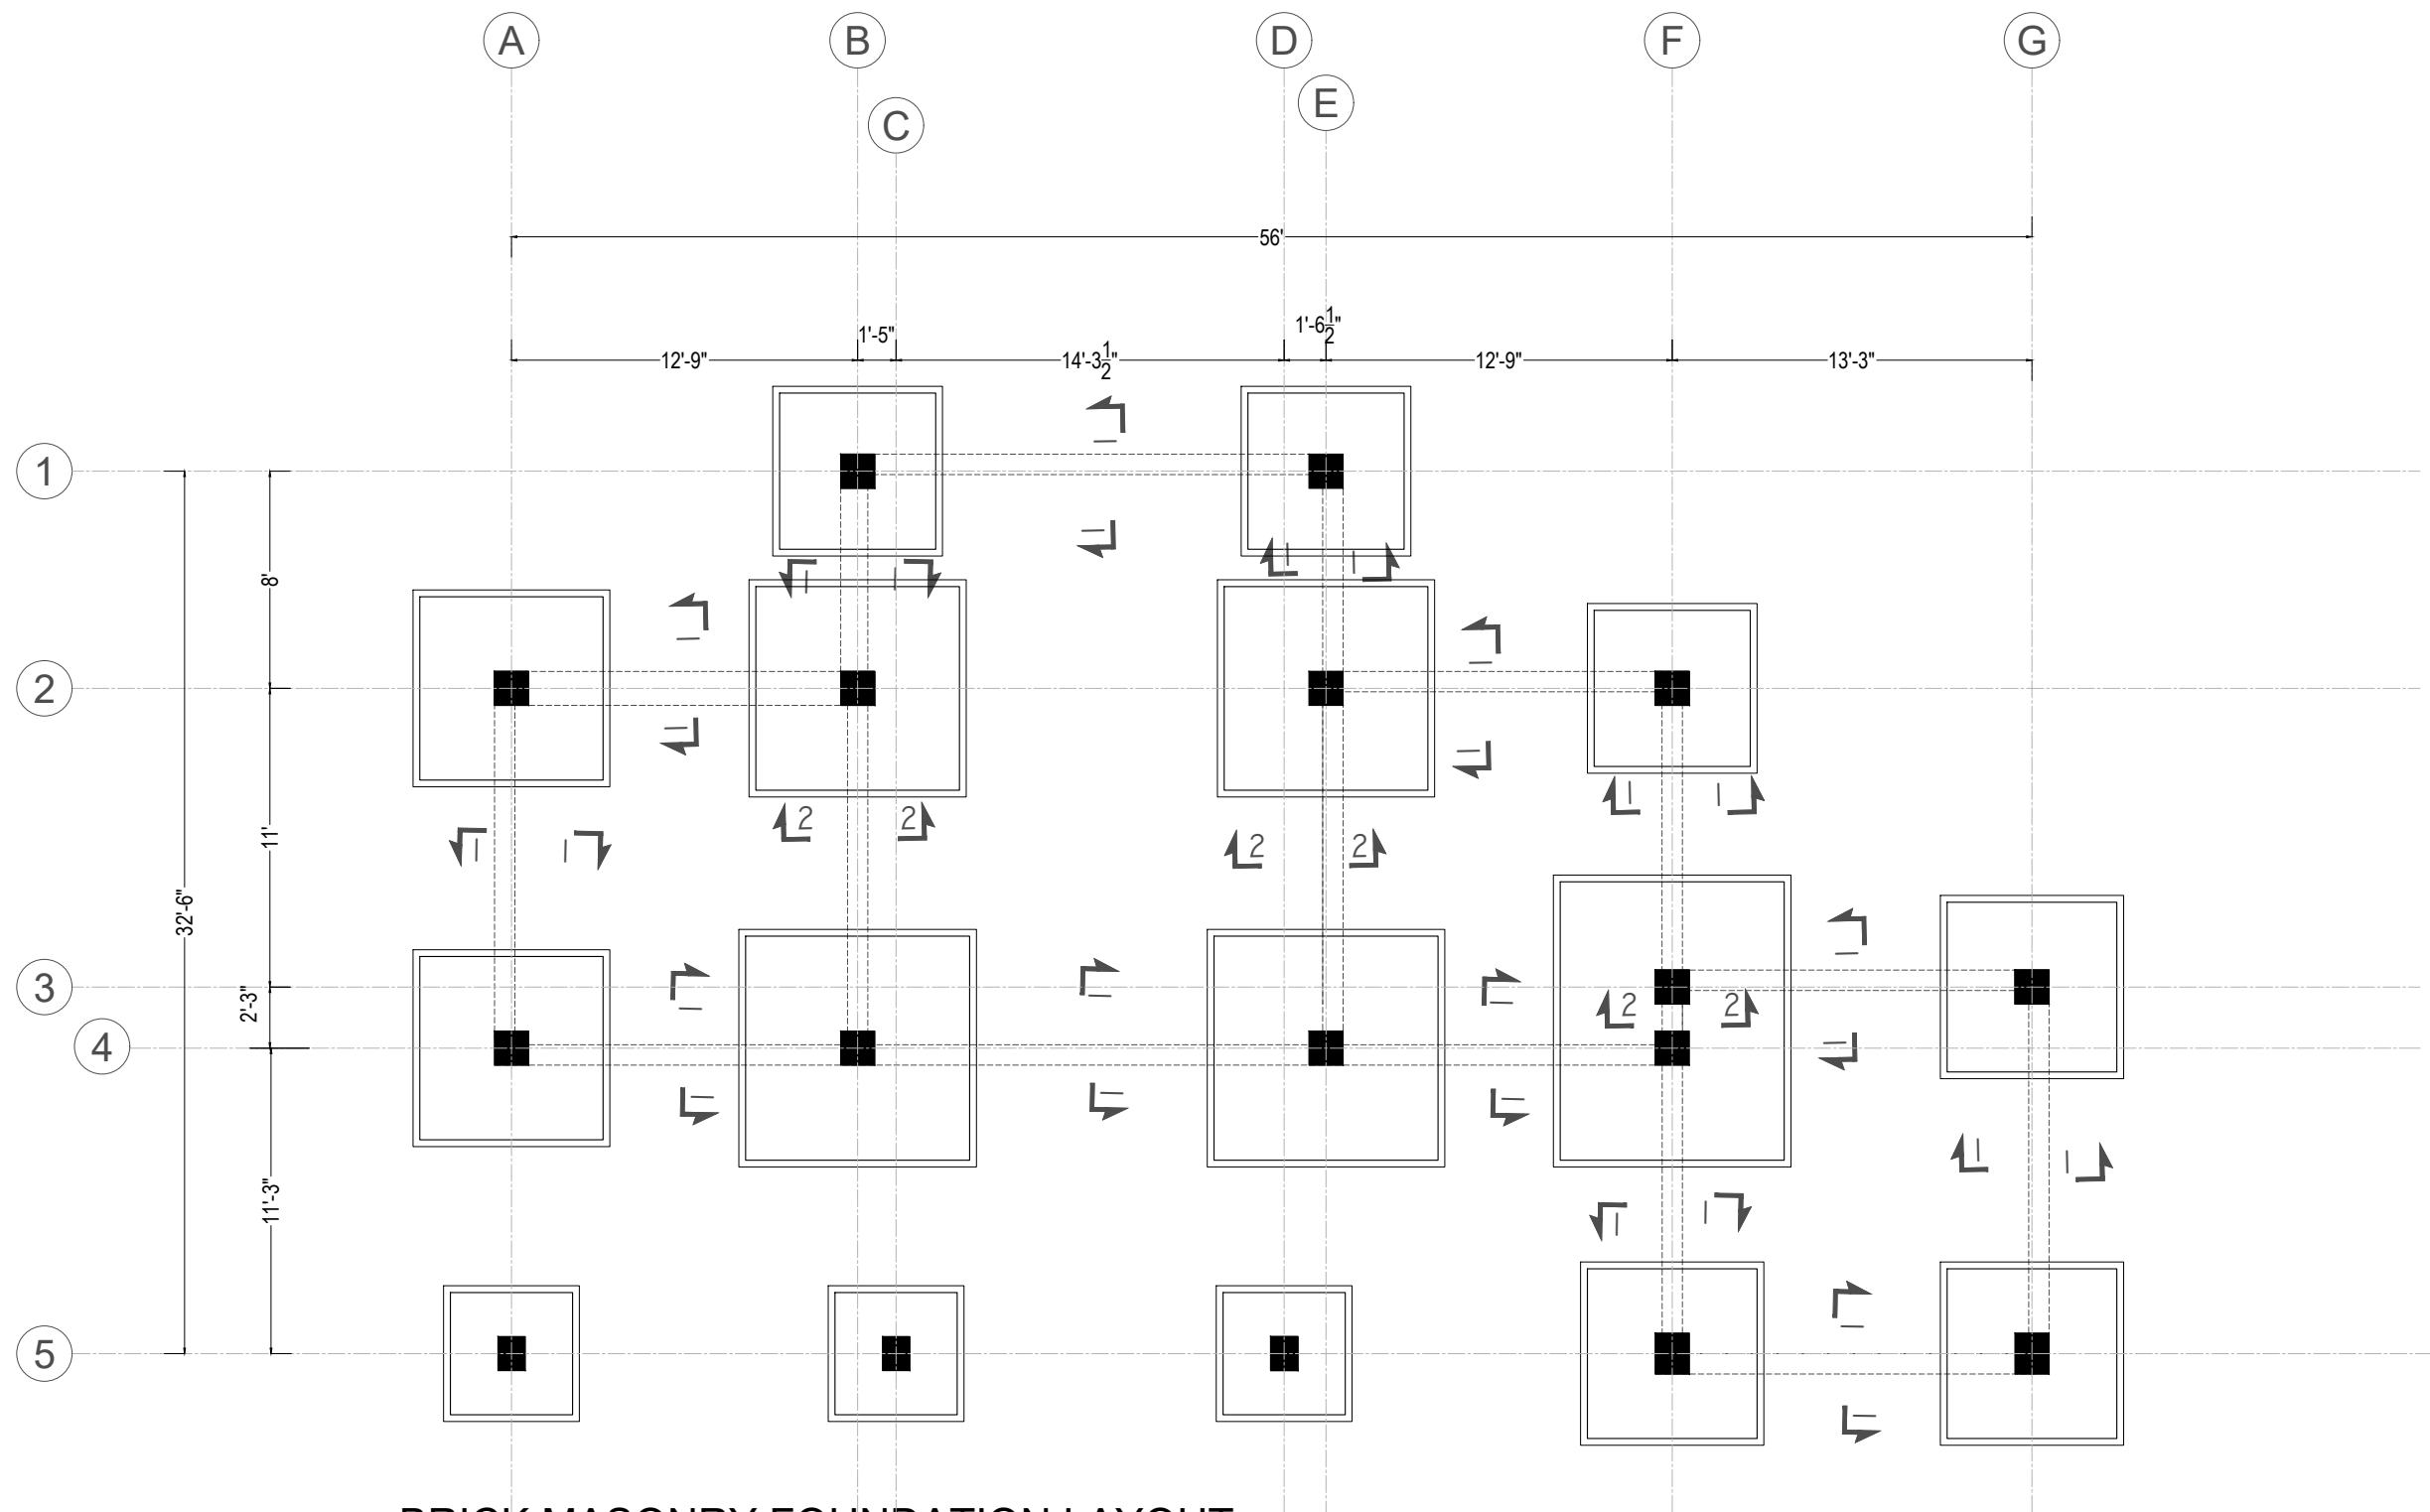

BRICK MASONRY FOUNDATION LAYOUT

FOR MORE DETAILS REFER TO ARCHITECTURAL DRAWINGS

ADDITION & REVISION					
ADD. REV. NO.	DATE	DESCRIPTION	DES. BY	CHK. BY	APP. BY



NEW VISION ENGINEERING CONSULTANT
 Head Office: Office No.B-6 SECOND FLOOR Masood Arcade
 IJP Road Islamabad.
 Ph: +92-51-4848375, Fax: +92-51-4848375
 Email: newvisionec@yahoo.com
 Regional Office: 287-A Street # 6, Cavalry Ground ,Lahore
 Ph: +92-42-37250130

PROJECT: "PROVISION OF MISSING FACILITIES FOR THE SHAIKH AYAZ UNIVERSITY SHIKARPUR"			CLIENT: SHAIKH AYAZ UNIVERSITY SHIKARPUR		
TITLE: BRICK MASONRY FOOTING LAYOUT			DESIGNED BY: ENG. AHSAN	APPROVED BY:	DATE: JUNE, 2022
			DRAWN BY: RIZWAN	JOB NO.	SCALE: N.T.S
			DRG. NO.	ST-10	



2' x 2' LED PANEL LIGHT

- Switch Board
- △ 10–/13 amp Light Plug sockets



20 Watt LED/Ceiling mounted Light Fixture, IP-44 rated



A.C wall mounted 220 volt (-TON)



15 Watt LED/Ceiling mounted Light Fixture, IP-44 rated



A.C Floor Standing cabinet 440 volt (-TON)



10 Watt LED/Ceiling mounted Light Fixture, IP-44 rated



Manual call point and sounder with flasher



40 Watt Luxline 4ft wall mounted Light Fixture, IP-44 rated



FA Panel



56" - 48" dia ceiling fan Fan shall be made with 99% purity Copper windings.



smoke detector



CCTV Camera



12 " outer dia exhaust fan with plastic body, fan blades and louvers



NVR



24 " outer dia Bracket fan with plastic body, fan blades and louvers



tv



Wifi



DATA POINT



telephone



SUB DB

ADDITION & REVISION					
ADD. REV. NO.	DATE	DESCRIPTION	DES. BY	CHK. BY	APP. BY

DESIGNER:



NEW VISION ENGINEERING CONSULTANT

Head Office: Office No.B-6 SECOND FLOOR Masood Arcade
IJP Road Islamabad.

Ph: +92-51-4848375, Fax: +92-51-4848375

Email: newvisionec@yahoo.com

Regional Office: 287-A Street # 6, Cavalry Ground ,Lahore

Ph: +92-42-37250130

PROJECT:

"PROVISION OF MISSING FACILITIES FOR THE
SHAIKH AYAZ UNIVERSITY SHIKARPUR"

TITLE:

LEGEND AND SYMBOLS

CLIENT:

SHAIKH AYAZ UNIVERSITY SHIKARPUR

DESIGNED BY:

ENG. SHADAB

APPROVED BY:

DATE :

JUNE, 2022

DRAWN BY:

RIZWAN

JOB NO.

SCALE:

N.T.S

DRG. NO.

EL-02



PROVISION OF MISSING FACILITIES FOR THE SHAIKH AYAZ UNIVERSITY SHIKARPUR



BOY'S AND GIRL'S HOSTEL VOLUME III TENDER DRAWINGS DEC, 2022

DESIGN BY



NEW VISION ENGINEERING CONSULTANT



HEAD OFFICE:

Office No.B-6 Second Floor Masood Arcade
IJP Road Islamabad.

Ph: +92-51-4848375, Fax: +92-51-4848375
Email: newvisionec@yahoo.com

REGIONAL OFFICE:

287-A Street # 6,
Cavalry Ground ,Lahore
Ph: +92-42-37250130

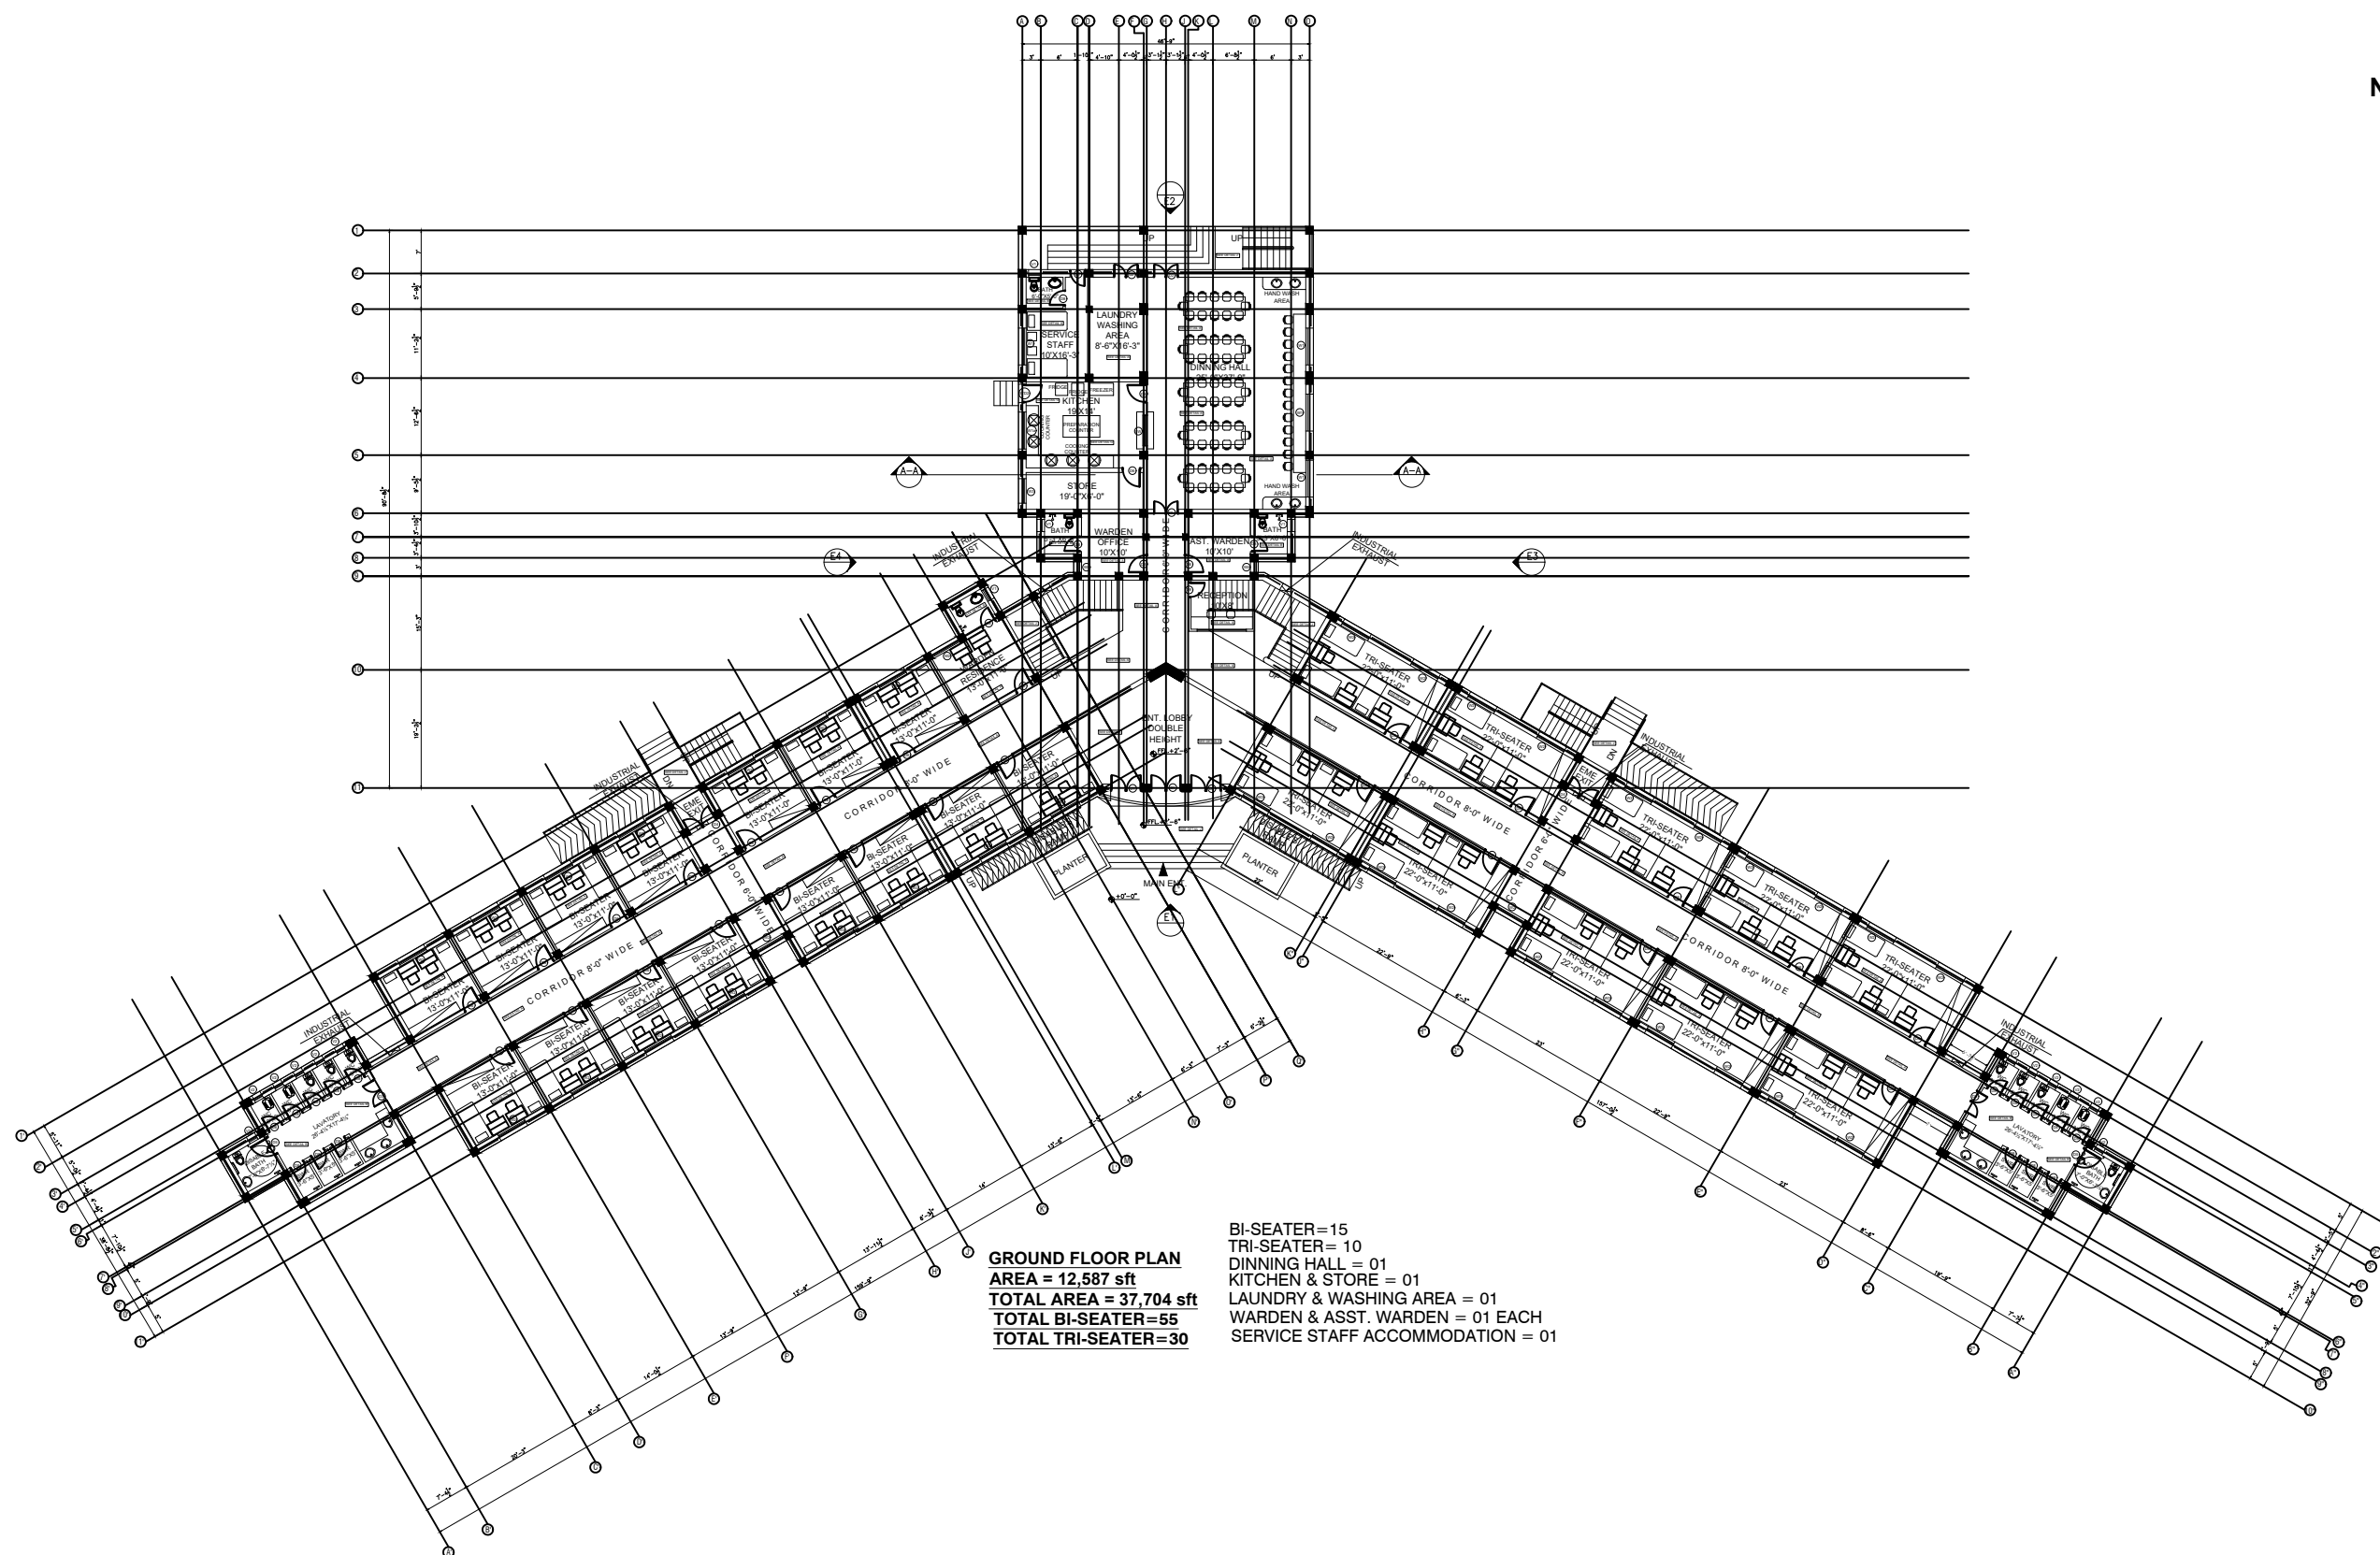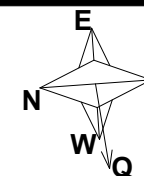

GROUND FLOOR PLAN
AREA = 12,587 sft
TOTAL AREA = 37,704 sft
TOTAL BI-SEATER=55
TOTAL TRI-SEATER=30

BI-SEATER=15
TRI-SEATER= 10
DINNING HALL = 01
KITCHEN & STORE = 01
LAUNDRY & WASHING AREA = 01
WARDEN & ASST. WARDEN = 01 EACH
SERVICE STAFF ACCOMMODATION = 01

ADDITION & REVISION					
ADD./REV. NO.	DATE	DESCRIPTION	DES. BY	CHK. BY	APP. BY



NEW VISION ENGINEERING CONSULTANT

Head Office: Office No.B-6 Second Floor Masood Arcade
IJP Road Islamabad.

Ph: +92-51-4848375, Fax: +92-51-4848375
Email: newvisionec@yahoo.com

Regional Office: 287-A Street # 6, Cavalry Ground ,Lahore

Ph: +92-42-37250130



PROJECT:
**"PROVISION OF MISSING FACILITIES FOR THE
SHAikh AYAZ UNIVERSITY SHIKARPUR"**

TITLE:
**BOY'S / GIRL'S HOSTEL
GROUND FLOOR PLAN**

CAD filename:

CLIENT:
SHAikh AYAZ UNIVERSITY SHIKARPUR

DESIGNED BY: AR. SALMAN	APPROVED BY: S A	DATE : AUGUST, 2022
DRAWN BY: RANA ALI HAIDER	JOB NO.	SCALE: N.T.S
DRG. NO.	AR-01	

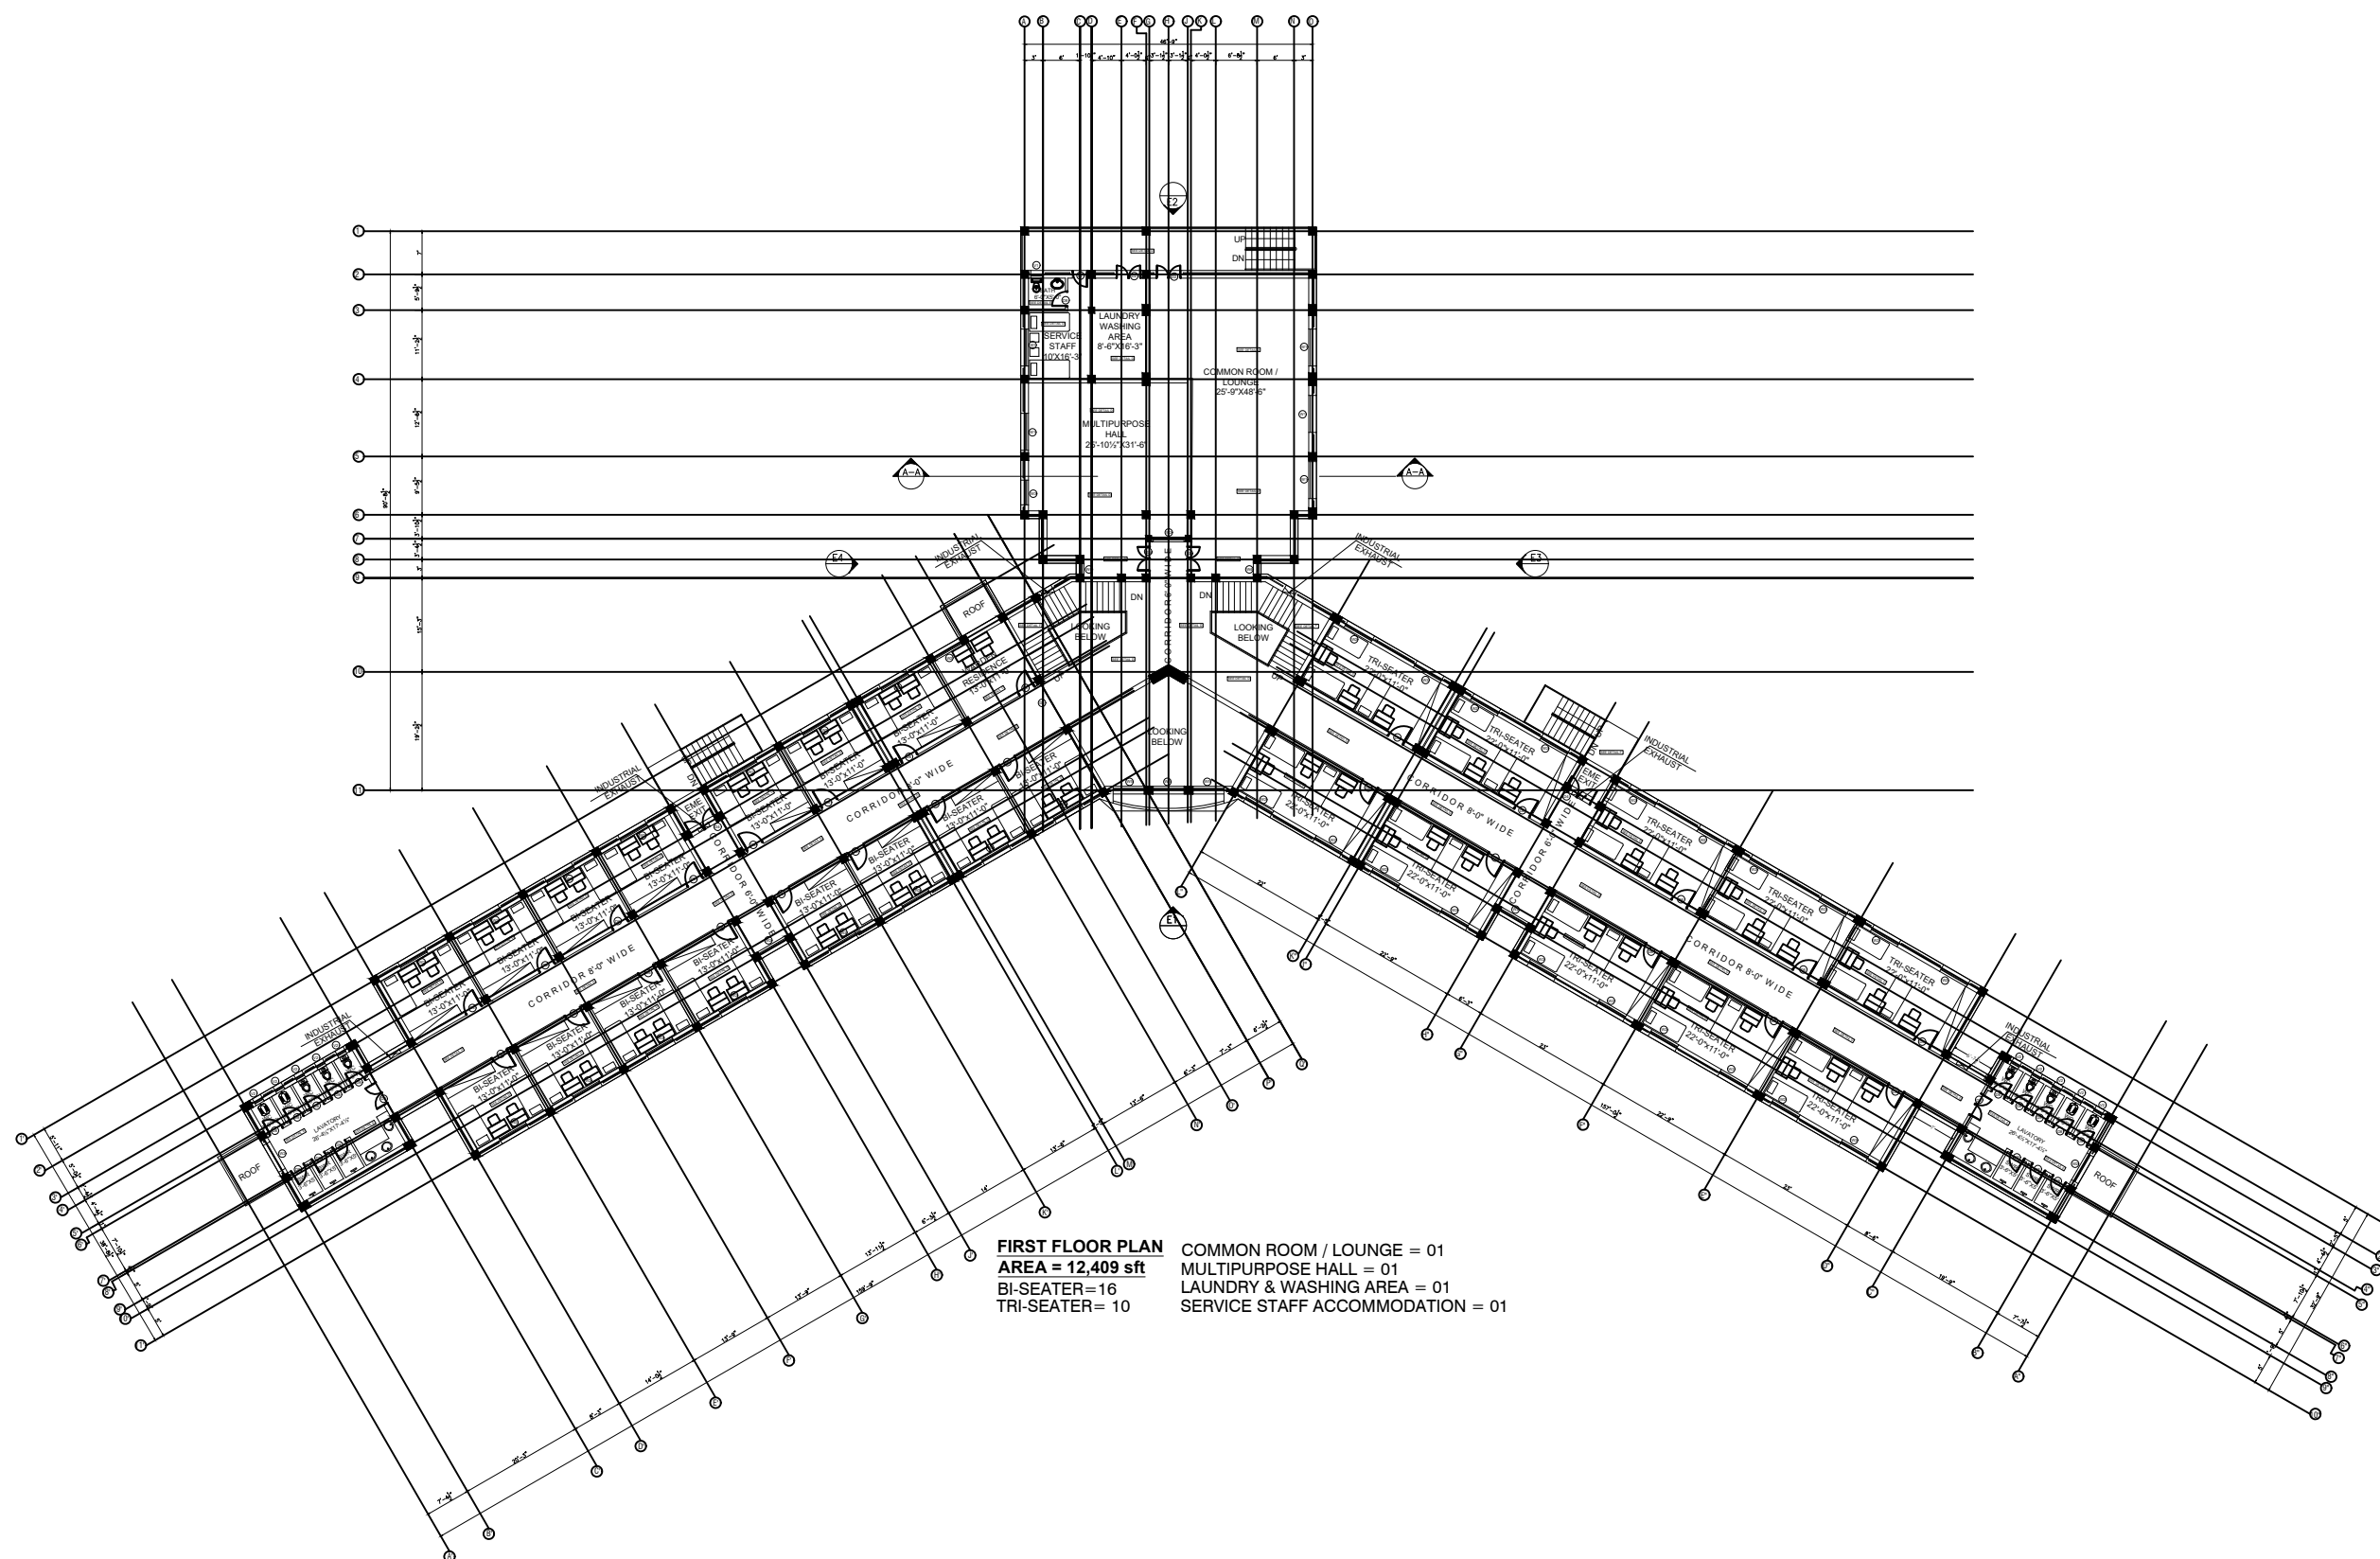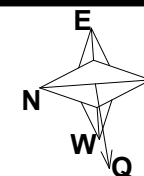



FIRST FLOOR PLAN
AREA = 12,409 sqft
BI-SEATER=16
TRI-SEATER= 10
COMMON ROOM / LOUNGE = 01
MULTIPURPOSE HALL = 01
LAUNDRY & WASHING AREA = 01
SERVICE STAFF ACCOMMODATION = 01

ADDITION & REVISION					
ADD. REV. NO.	DATE	DESCRIPTION	DES. BY	CHK. BY	APP. BY



NEW VISION ENGINEERING CONSULTANT
Head Office: Office No.B-6 Second Floor Masood Arcade
IJP Road Islamabad.
Ph: +92-51-4848375, Fax: +92-51-4848375
Email: newvisionec@yahoo.com
Regional Office: 287-A Street # 6, Cavalry Ground ,Lahore
Ph: +92-42-37250130

PROJECT: "PROVISION OF MISSING FACILITIES FOR THE SHAIKH AYAZ UNIVERSITY SHIKARPUR"		CLIENT: SHAIKH AYAZ UNIVERSITY SHIKARPUR	
TITLE: BOY'S / GIRL'S HOSTEL FIRST FLOOR PLAN	DESIGNED BY: AR. SALMAN		APPROVED BY: S A
	DRAWN BY: RANA ALI HAIDER		JOB NO.
CAD filename:		DRG. NO. AR-02	
		DATE :	AUGUST, 2022
		SCALE:	N.T.S

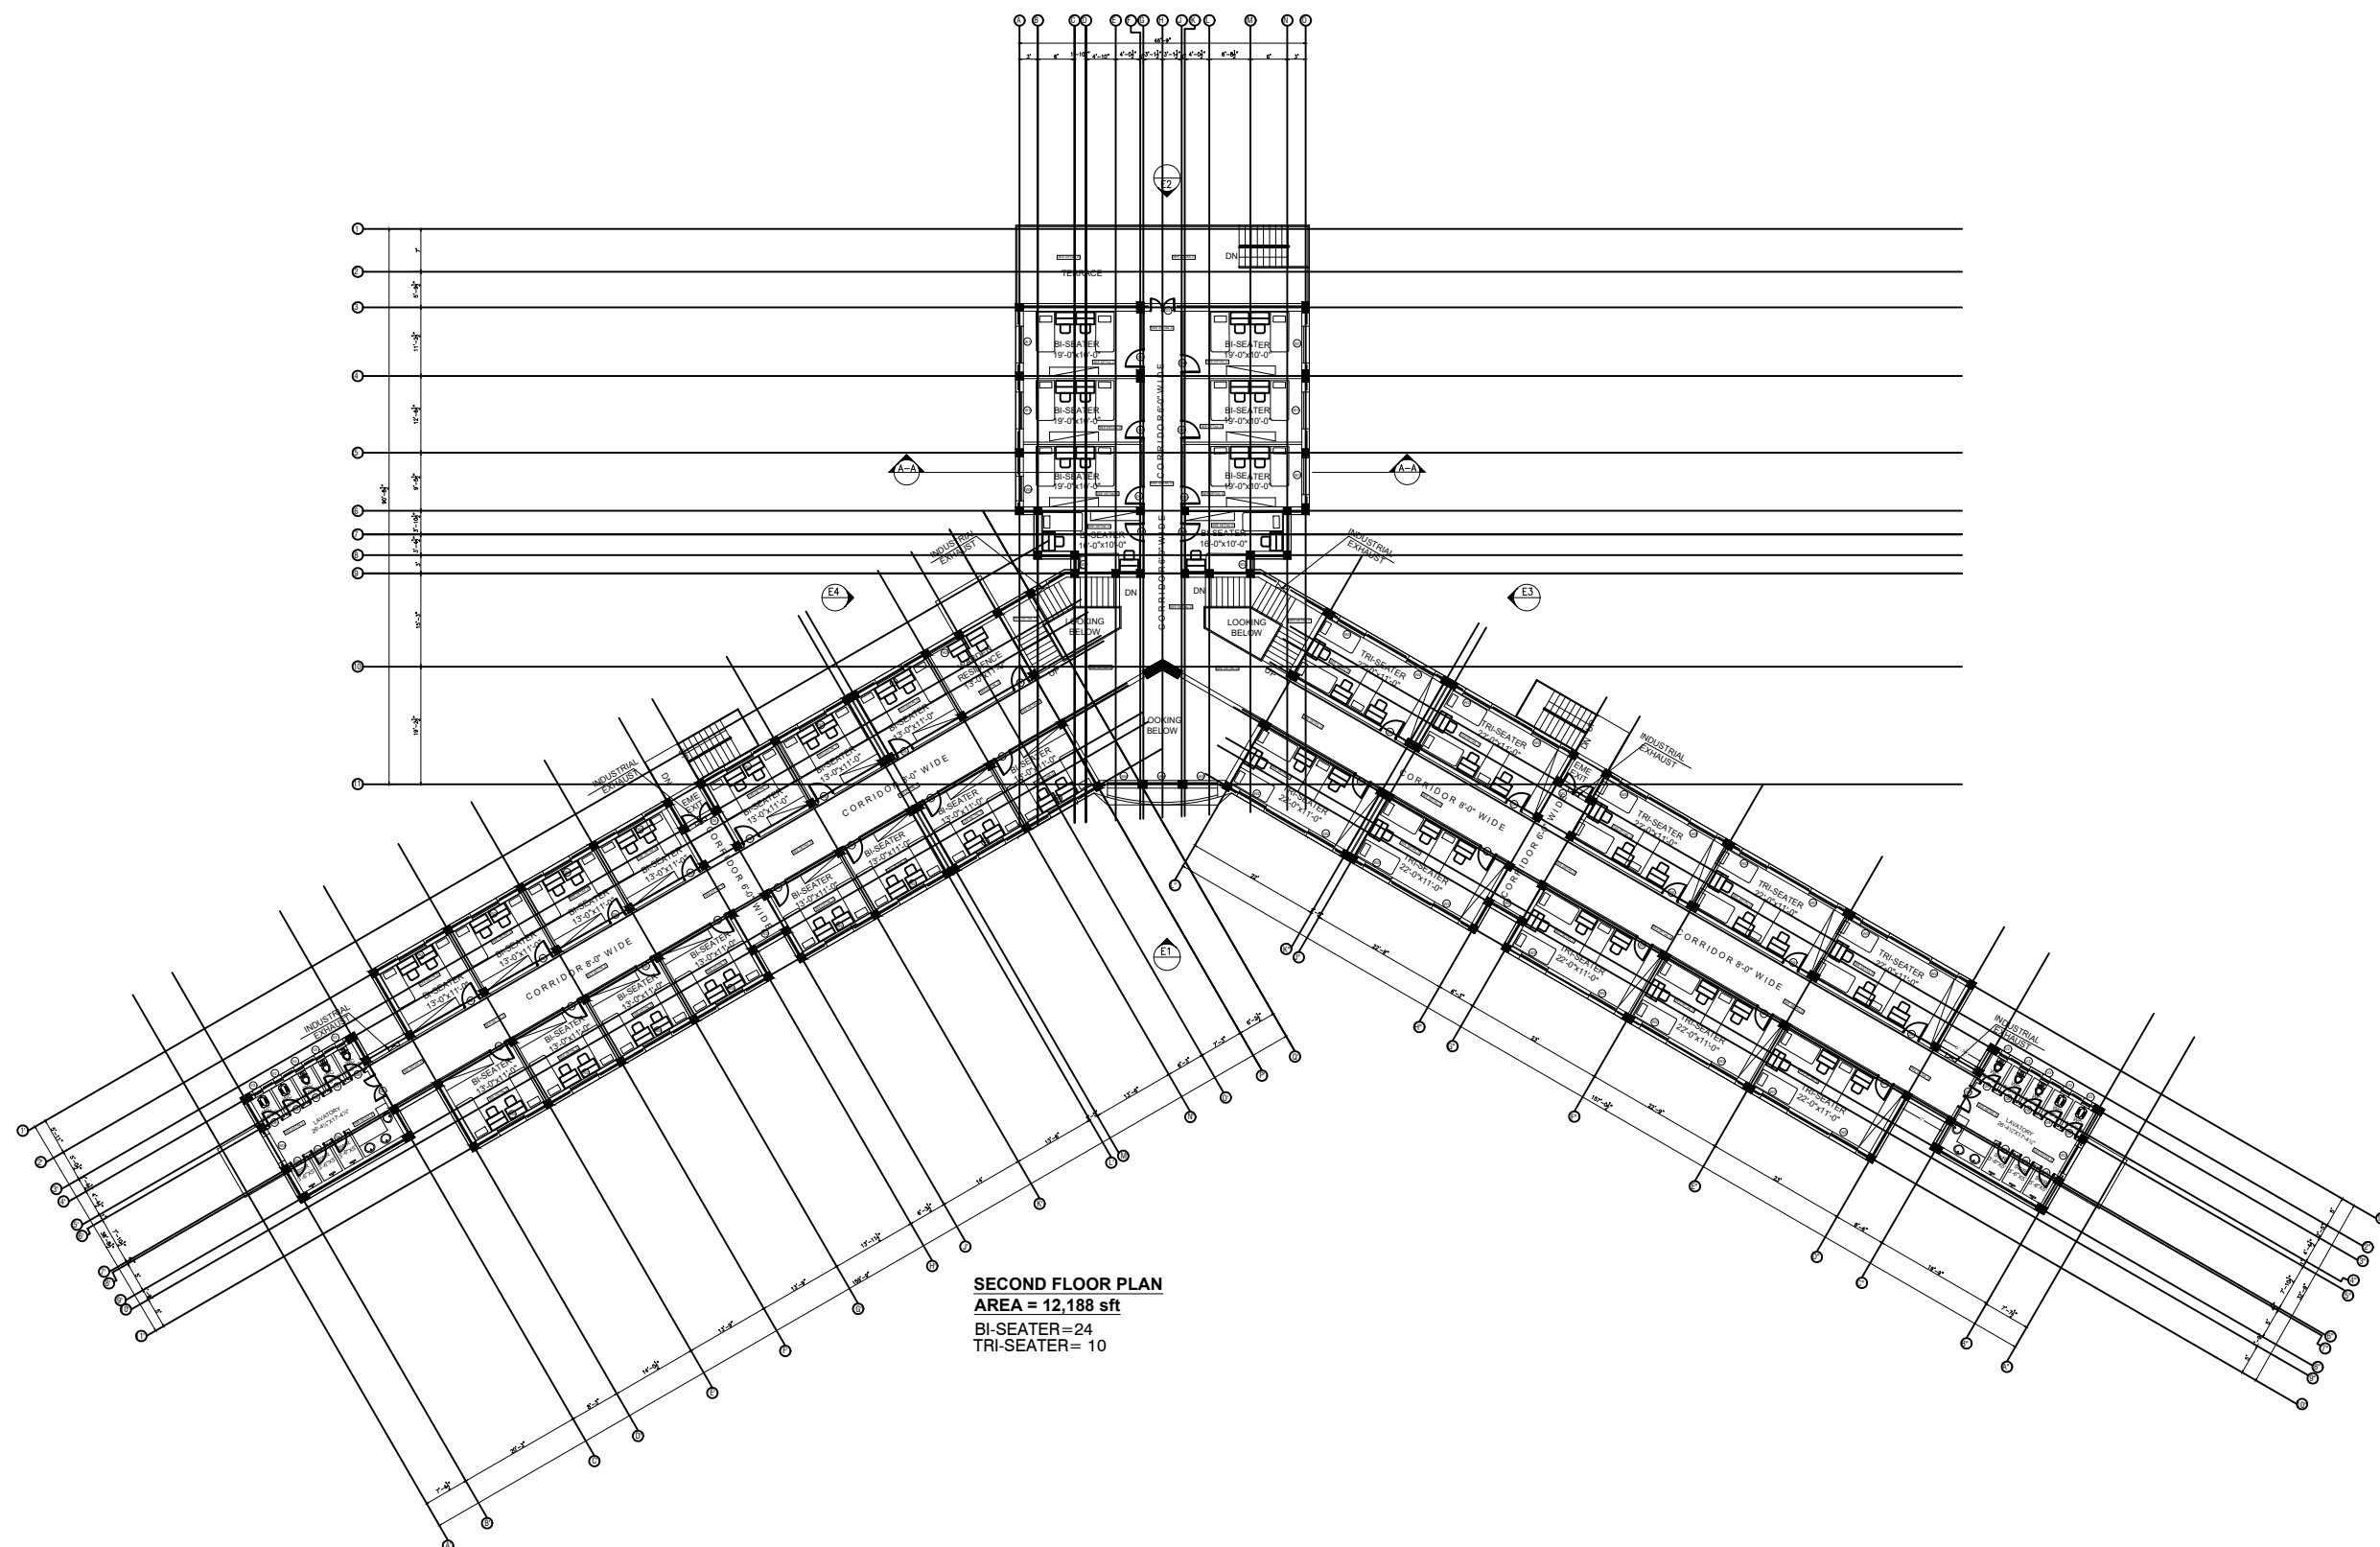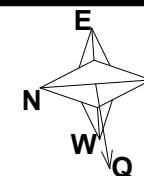


SECOND FLOOR PLAN
AREA = 12,188 sft
BI-SEATER=24
TRI-SEATER= 10

ADDITION & REVISION					
ADD./REV. NO.	DATE	DESCRIPTION	DES. BY	CHK. BY	APP. BY



NEW VISION ENGINEERING CONSULTANT
Head Office: Office No.B-6 Second Floor Masood Arcade
IJP Road Islamabad.
Ph: +92-51-4848375, Fax: +92-51-4848375
Email: newvisionec@yahoo.com
Regional Office: 287-A Street # 6, Cavalry Ground ,Lahore
Ph: +92-42-37250130

PROJECT: "PROVISION OF MISSING FACILITIES FOR THE SHAIKH AYAZ UNIVERSITY SHIKARPUR"		CLIENT: SHAIKH AYAZ UNIVERSITY SHIKARPUR	
TITLE: BOY'S / GIRL'S HOSTEL SECOND FLOOR PLAN	DESIGNED BY: AR. SALMAN		APPROVED BY: S A
	DRAWN BY: RANA ALI HAIDER		JOB NO.
CAD filename:		DRG. NO. AR-03	
		DATE :	AUGUST, 2022
		SCALE:	N.T.S

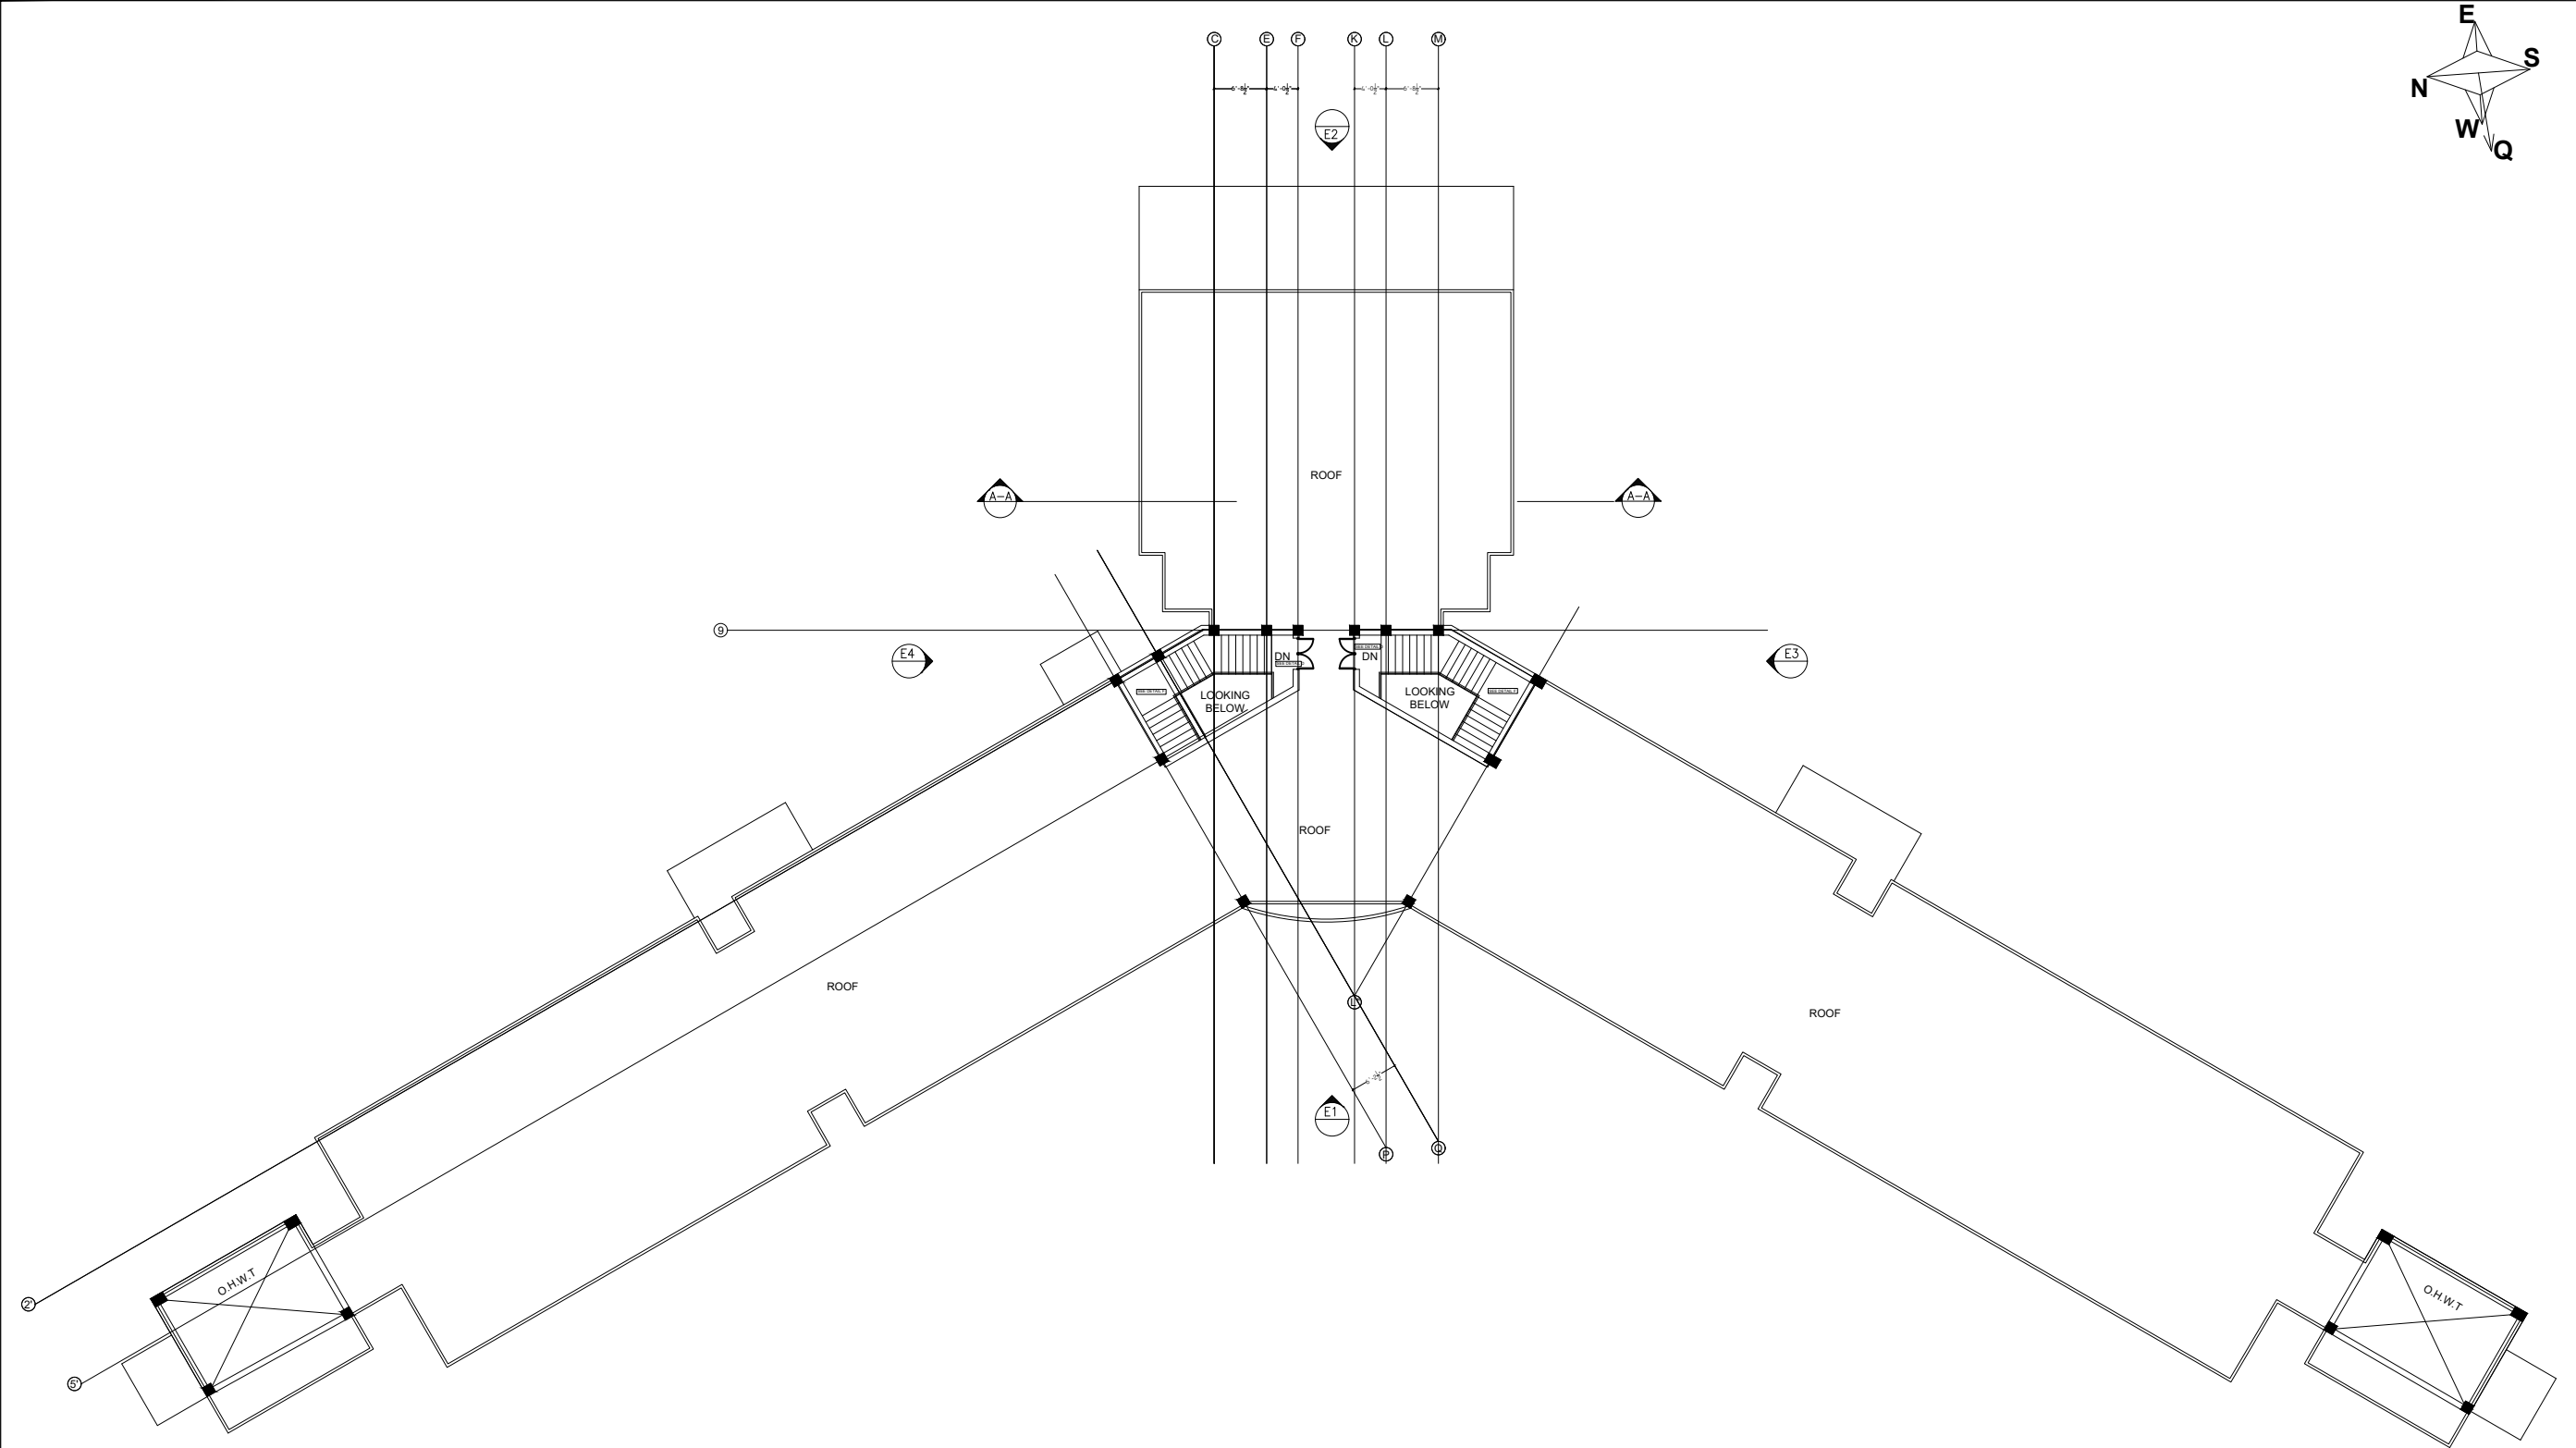


ROOF PLAN
AREA = 596 sft

ADDITION & REVISION					
ADD. REV. NO.	DATE	DESCRIPTION	DES. BY	CHK. BY	APP. BY



NEW VISION ENGINEERING CONSULTANT
Head Office: Office No.B-6 Second Floor Masood Arcade
IJP Road Islamabad.
Ph: +92-51-4848375, Fax: +92-51-4848375
Email: newvisionec@yahoo.com
Regional Office: 287-A Street # 6, Cavalry Ground ,Lahore
Ph: +92-42-37250130

PROJECT: "PROVISION OF MISSING FACILITIES FOR THE SHAIKH AYAZ UNIVERSITY SHIKARPUR"		CLIENT: SHAIKH AYAZ UNIVERSITY SHIKARPUR	
TITLE: BOY'S / GIRL'S HOSTEL ROOF FLOOR PLAN	DESIGNED BY: AR. SALMAN	APPROVED BY: S A	DATE : AUGUST, 2022
	DRAWN BY: RANA ALI HAIDER	JOB NO.	SCALE: N.T.S
CAD filename:		DRG. NO. AR-04	

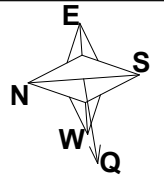

BOY'S & GIRL'S HOSTEL AREA'S

GROUND FLOOR PLAN	12587 sft
FIRST FLOOR PLAN	12409 sft
SECOND FLOOR PLAN	12188 sft
ROOF FLOOR PLAN	520 sft
TOTAL AREA	37704 sft

ADDITION & REVISION					
ADD. REV. NO.	DATE	DESCRIPTION	DES. BY	CHK. BY	APP. BY



NEW VISION ENGINEERING CONSULTANT

Head Office: Office No.B-6 Second Floor Masood Arcade
IJP Road Islamabad.

Ph: +92-51-4848375, Fax: +92-51-4848375

Email: newvisionec@yahoo.com

Regional Office: 287-A Street # 6, Cavalry Ground ,Lahore

Ph: +92-42-37250130

PROJECT:
"PROVISION OF MISSING FACILITIES FOR THE
SHAIKH AYAZ UNIVERSITY SHIKARPUR"

TITLE: BOY'S / GIRL'S HOSTEL

AREA'S

CAD filename:

CLIENT: SHAIKH AYAZ UNIVERSITY SHIKARPUR

DESIGNED BY:
AR. SALMAN

DRAWN BY:
RANA ALI HAIDER

DRG. NO.



APPROVED BY:
S A

JOB NO.

AR-05

DATE : AUGUST, 2022

SCALE:
N.T.S

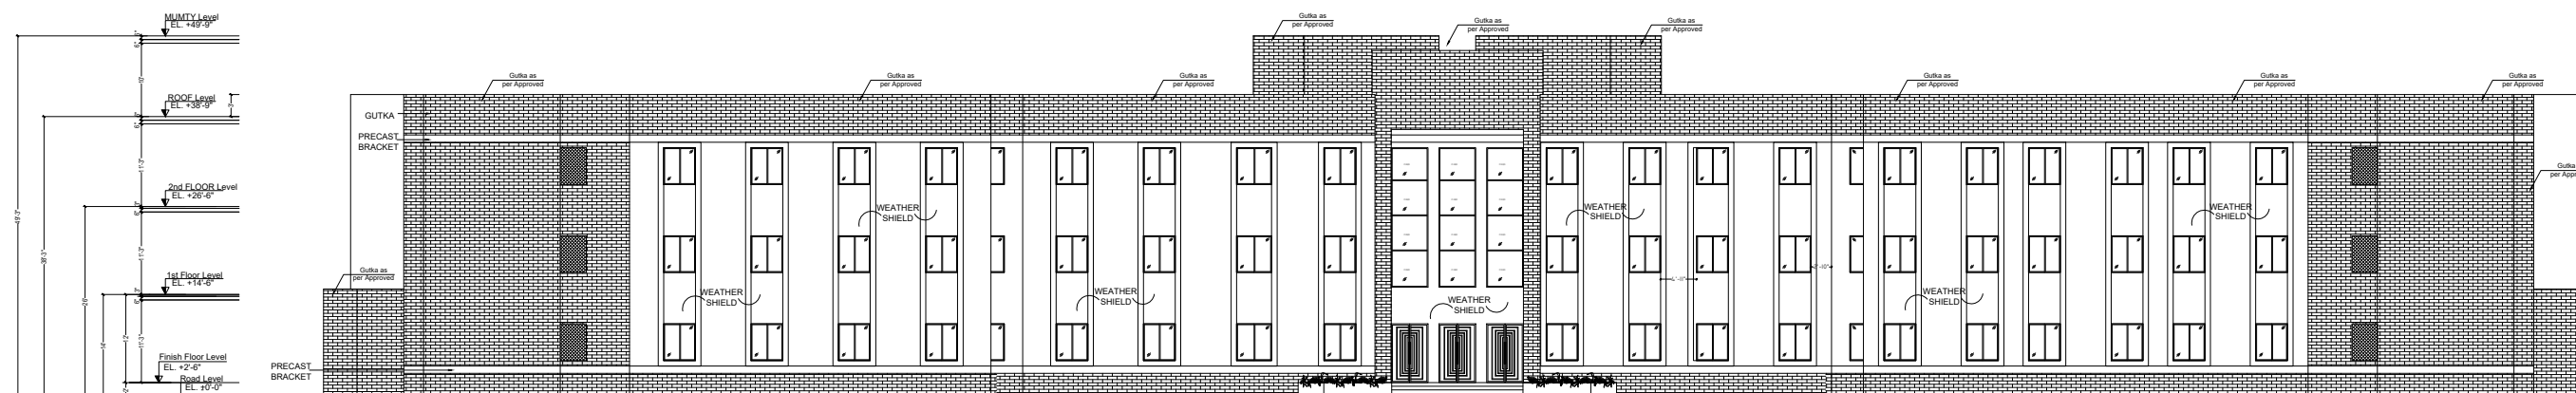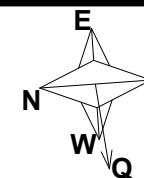

E1 ELEVATION E1

ADDITION & REVISION					
ADD. REV. NO.	DATE	DESCRIPTION	DES. BY	CHK. BY	APP. BY



NEW VISION ENGINEERING CONSULTANT

Head Office: Office No.B-6 Second Floor Masood Arcade
IJP Road Islamabad.

Ph: +92-51-4848375, Fax: +92-51-4848375
Email: newvisionec@yahoo.com

Regional Office: 287-A Street # 6, Cavalry Ground ,Lahore
Ph: +92-42-37250130

PROJECT:
**"PROVISION OF MISSING FACILITIES FOR THE
SHAIKH AYAZ UNIVERSITY SHIKARPUR"**

TITLE:
**BOY'S / GIRL'S HOSTEL
ELEVATION E1**

CAD filename:

CLIENT:
SHAIKH AYAZ UNIVERSITY SHIKARPUR

DESIGNED BY: AR. SALMAN	APPROVED BY: S A	DATE : AUGUST, 2022
DRAWN BY: RANA ALI HAIDER	JOB NO.	SCALE: N.T.S

DRG. NO. AR-06

GENERAL TECHNICAL NOTES

1. Figured dimensions are to be followed.
 2. Class "A" kiln burnt brick with minimum crushing strength of 2000 PSI should be used & joint at end should be sloppy, Vertical toothed joint at corners are prohibited.
 3. A steel G-60 deformed steel should be used in beams footing slabs and water retaining structures, in columns, for all diameters.
 4. All steel should be checked for its quality and placement DETAIL as shown in drawings.
 5. Extra care is required for proper placement of top reinforcement at support sections and cantilevers.
 6. Dotted bars designate top reinforcement.
 7. Provide L- shaped end hooks for all bars at discontinuous ends in footings, walls, beams and slabs as shown in drawings.
 8. Lap length should be followed As except specified:-
 - (a) 1" $\varnothing$ = 60"
 - (b) 3/4" $\varnothing$ = 45"
 - (c) 5/8" $\varnothing$ = 36"
 - (d) 1/2" $\varnothing$ = 30"
 - (e) 3/8" $\varnothing$ = 23"
 09. Provide 3/8" dia at 12" c/c as distribution steel if not shown in drawings.
 10. Minimum concrete cover.
 - a) Footing = 2"
 - b) Slabs = 3/4"
 - c) Beams = 1 1/2"
 - d) Columns = 1 1/2"
 - e) Water tank and retaining wall
i- Water/earth face or exposed to weather = 2"
ii- Other faces = 1"
 11. All footing should be taken below the original Ground Level to achieve the minimum depth as shown in drawings. Footing should not be placed on uncompacted fill area.
 12. All drawings should be read in conjunction with Architectural Drawings.
 13. Contractor will co-ordinate all drawings such as architectural, structural, electrical, mechanical, water supply, drainage etc: before execution of work.
 14. Standard ACI 318, Astm C 33 and Astm A-615 use for structural concrete
 15. Fine modulus of fine aggregate varies from 2- 3.5mm
For concrete use 2.9- 3.2mm
For plaster use 2.2- 3.6mm
- QUALITY OF CONCRETE
1. FOOTINGS & RETAINING WALLS.
Minimum concrete compressive strength for 6"x12" cylinder to be 3000 psi at 28 days age. Concrete Nominal Mix 1:2:4 or more rich to provide specified strength (Equivalent 6"x6"x6" cube strength 3750 psi)

2. COLUMNS.

Minimum concrete compressive strength for 6"x12" cylinder to be 4000 psi at 28 days age. Concrete Nominal Mix to be 1:1½:3 or more rich to provide specified strength

3. BEAMS, RIBS & SLABS.

Minimum concrete compressive strength for 6"x12" cylinder to be 3000 psi at 28 days age. Concrete Nominal Mix to be 1:2:4 or more rich to provide specified strength (Equivalent 6"x6"x6" cube strength 3750 psi)


4. Use of plasticizers recommended to reduce the water cement ratio and increase workability of concrete.
5. All concrete mixes to be used, should be got designed & approved before execution of work.
6. Quality, size and gradation of aggregates (fine & course) as used during the mix design, should be strictly adhered with.
7. The Design is in accordance with Seismic Zone 2A.

NOTES

1. ALL LAYOUT DIMENSIONS AND F.FLOOR LEVELS TO BE AS PER ARCH DRAWING.
2. PROVIDE PLINTH BEAM PB AT PLINTH LEVEL, WALL BEAMS AT SLAB LEVEL.
3. PROVIDE #2 DOUBLE-LEG TIE BARS AT 12" CENTRES AT COMMON JOINT BETWEEN WALLS AND COLUMNS. THESE BARS SHOULD PASS INTO WALLS ON EACH SIDE OF COLUMNS.

REINFORCING STEEL

REINFORCING STEEL $f_y = 60,000$ psi			
BAR NO.	BAR DIA (IN.)	DEVELOPMENT LENGTH (INCH) IN TENSION	
		$f_c = 3000$ psi	$f_c = 4000$ psi
#3	0.375	17"	15"
#4	0.500	22"	19"
#5	0.625	28"	24"
#6	0.750	33"	29"
#7	0.875	48"	42"
#8	1.000	55"	48"
BAR NO.	BAR DIA (IN.)	DEVELOPMENT LENGTH (INCH) IN COMPRESSION	
		$f_c = 3000$ psi	$f_c = 4000$ psi
#3	0.375	9"	8"
#4	0.500	11"	10"
#5	0.625	14"	12"
#6	0.750	17"	15"
#7	0.875	20"	17"
#8	1.000	22"	19"
BAR NO.	BAR DIA (IN.)	SPLICE LENGTH (INCH) IN TENSION	
		$f_c = 3000$ psi	$f_c = 4000$ psi
#3	0.375	22"	20"
#4	0.500	29"	25"
#5	0.625	37"	32"
#6	0.750	43"	38"
#7	0.875	63"	55"
#8	1.000	72"	63"

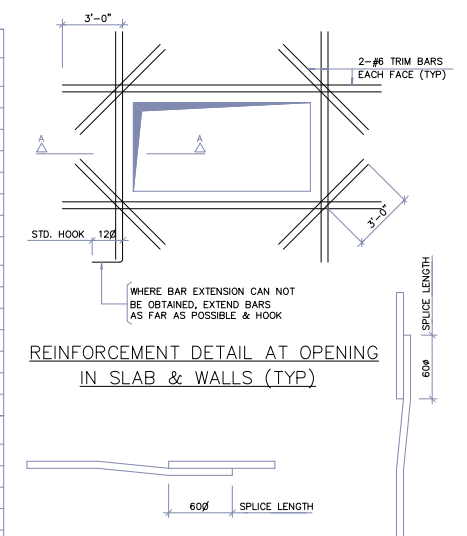

REINFORCEMENT DETAIL AT OPENING
IN SLAB & WALLS (TYP)

BEAM SPLICE
(TYP)


COLUMN SPLICE
(TYP)

BAR DIA	D
#3	2½"
#4	3"
#5	4"
#6	4½"
#8	6"
#9	9"
#11	11"




STANDARD BAR HOOKS


BAR DIA	D
Ø3	1½"
Ø4	2"
Ø5	2½"

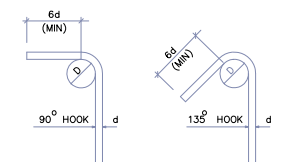

STIRRUPS AND TIE HOOKS

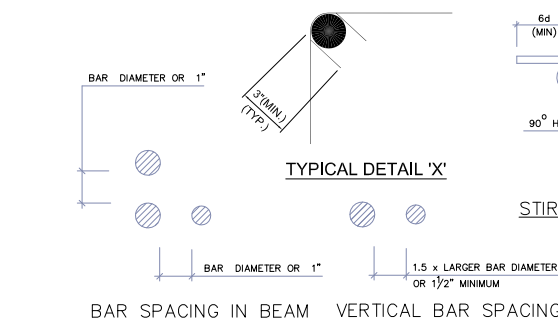


BAR SPACING IN BEAM	VERTICAL BAR SPACING
1	1
2	2
3	3
100	100

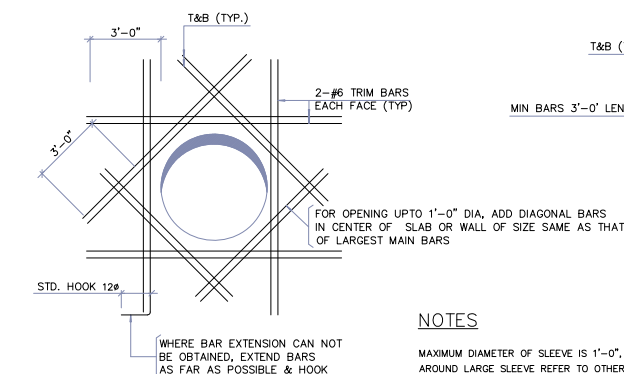


REINFORCEMENT AROUND SLEEVE IN SLAB & WALLS (TYP)

NOTES

MAXIMUM DIAMETER OF SLEEVE IS 1'-0", FOR TRIM BARS
AROUND LARGE SLEEVE REFER TO OTHER DETAIL.

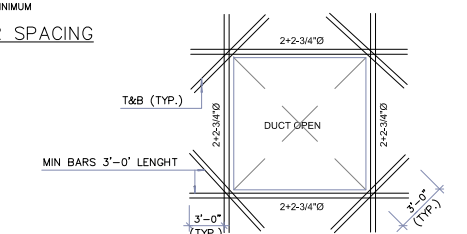

TYP. DUCT OPENING DETAIL

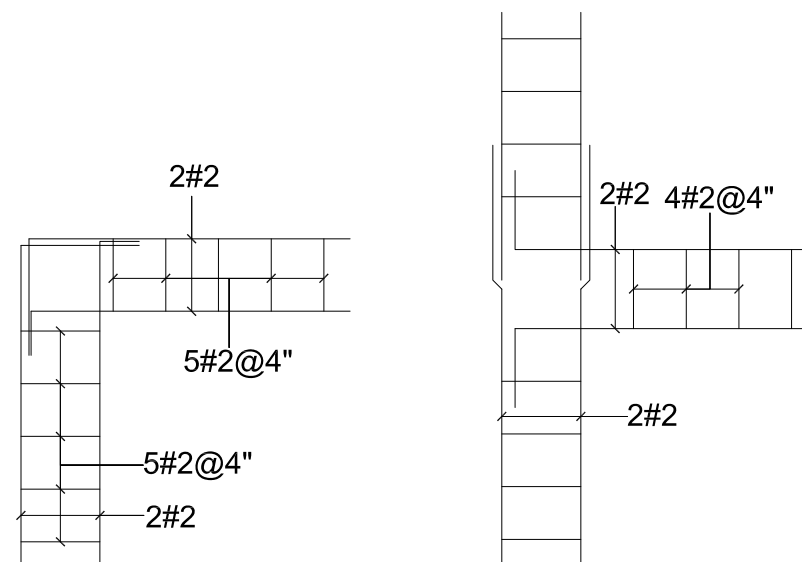

PLAN OF BRICK WALL TIE FOR CORNER JOINT

PLAN OF BRICK WALL TIE FOR T- JOINT

ADDITION & REVISION					
ADD./REV. NO.	DATE	DESCRIPTION	DES. BY	CHK. BY	APP. BY



NEW VISION ENGINEERING CONSULTANT
Head Office: Office No.B-6 SECOND FLOOR Masood Arcade
IJP Road Islamabad.
Ph: +92-51-4848375, Fax: +92-51-4648375
Email: newvisionec@yahoo.com
Regional Office: 287-A Street # 6, Cavalry Ground ,Lahore
Ph: +92-42-37250130

PROJECT:

**"PROVISION OF MISSING FACILITIES FOR THE
SHAikh AYAZ UNIVERSITY SHIKARPUR"**

TITLE:

GENERAL NOTES

	CLIENT:
--	---------

SHAIKH AYAZ UNIVERSITY SHIKARPUR

	DESIGNED BY:
	ENG.

SH	APPROVED BY:
----	--------------

DATE : AUG. 2022

DRAWN BY:
HAMZ.

	JOB NO.
HID	

SCALE: N.T.S

DRG. NO.	
----------	--

ST-02



NEW VISION ENGINEERING CONSULTANT
 Head Office: Office No.B-6 SECOND FLOOR Masood Arcade
 IJP Road Islamabad.
 Ph: +92-51-4848375, Fax: +92-51-4848375
 Email: newvisionec@yahoo.com
 Regional Office: 287-A Street # 6, Cavalry Ground ,Lahore
 Ph: +92-42-37250130

PROJECT:

**"PROVISION OF MISSING FACILITIES FOR THE
SHAIKH AYAZ UNIVERSITY SHIKARPUR"**

TITLE:

FOUNDATION SECTION A-A

CLIENT:

SHAIKH AYAZ UNIVERSITY SHIKARPUR

DESIGNED BY:
ENG. DANISH

APPROVED BY:

DATE :	AUG, 2022
--------	-----------


DRAWN BY:
HARDY

	JOB NO.
--	---------

SCALE:	N.T.S
--------	-------

DRG. NO.	
----------	--

ST-08

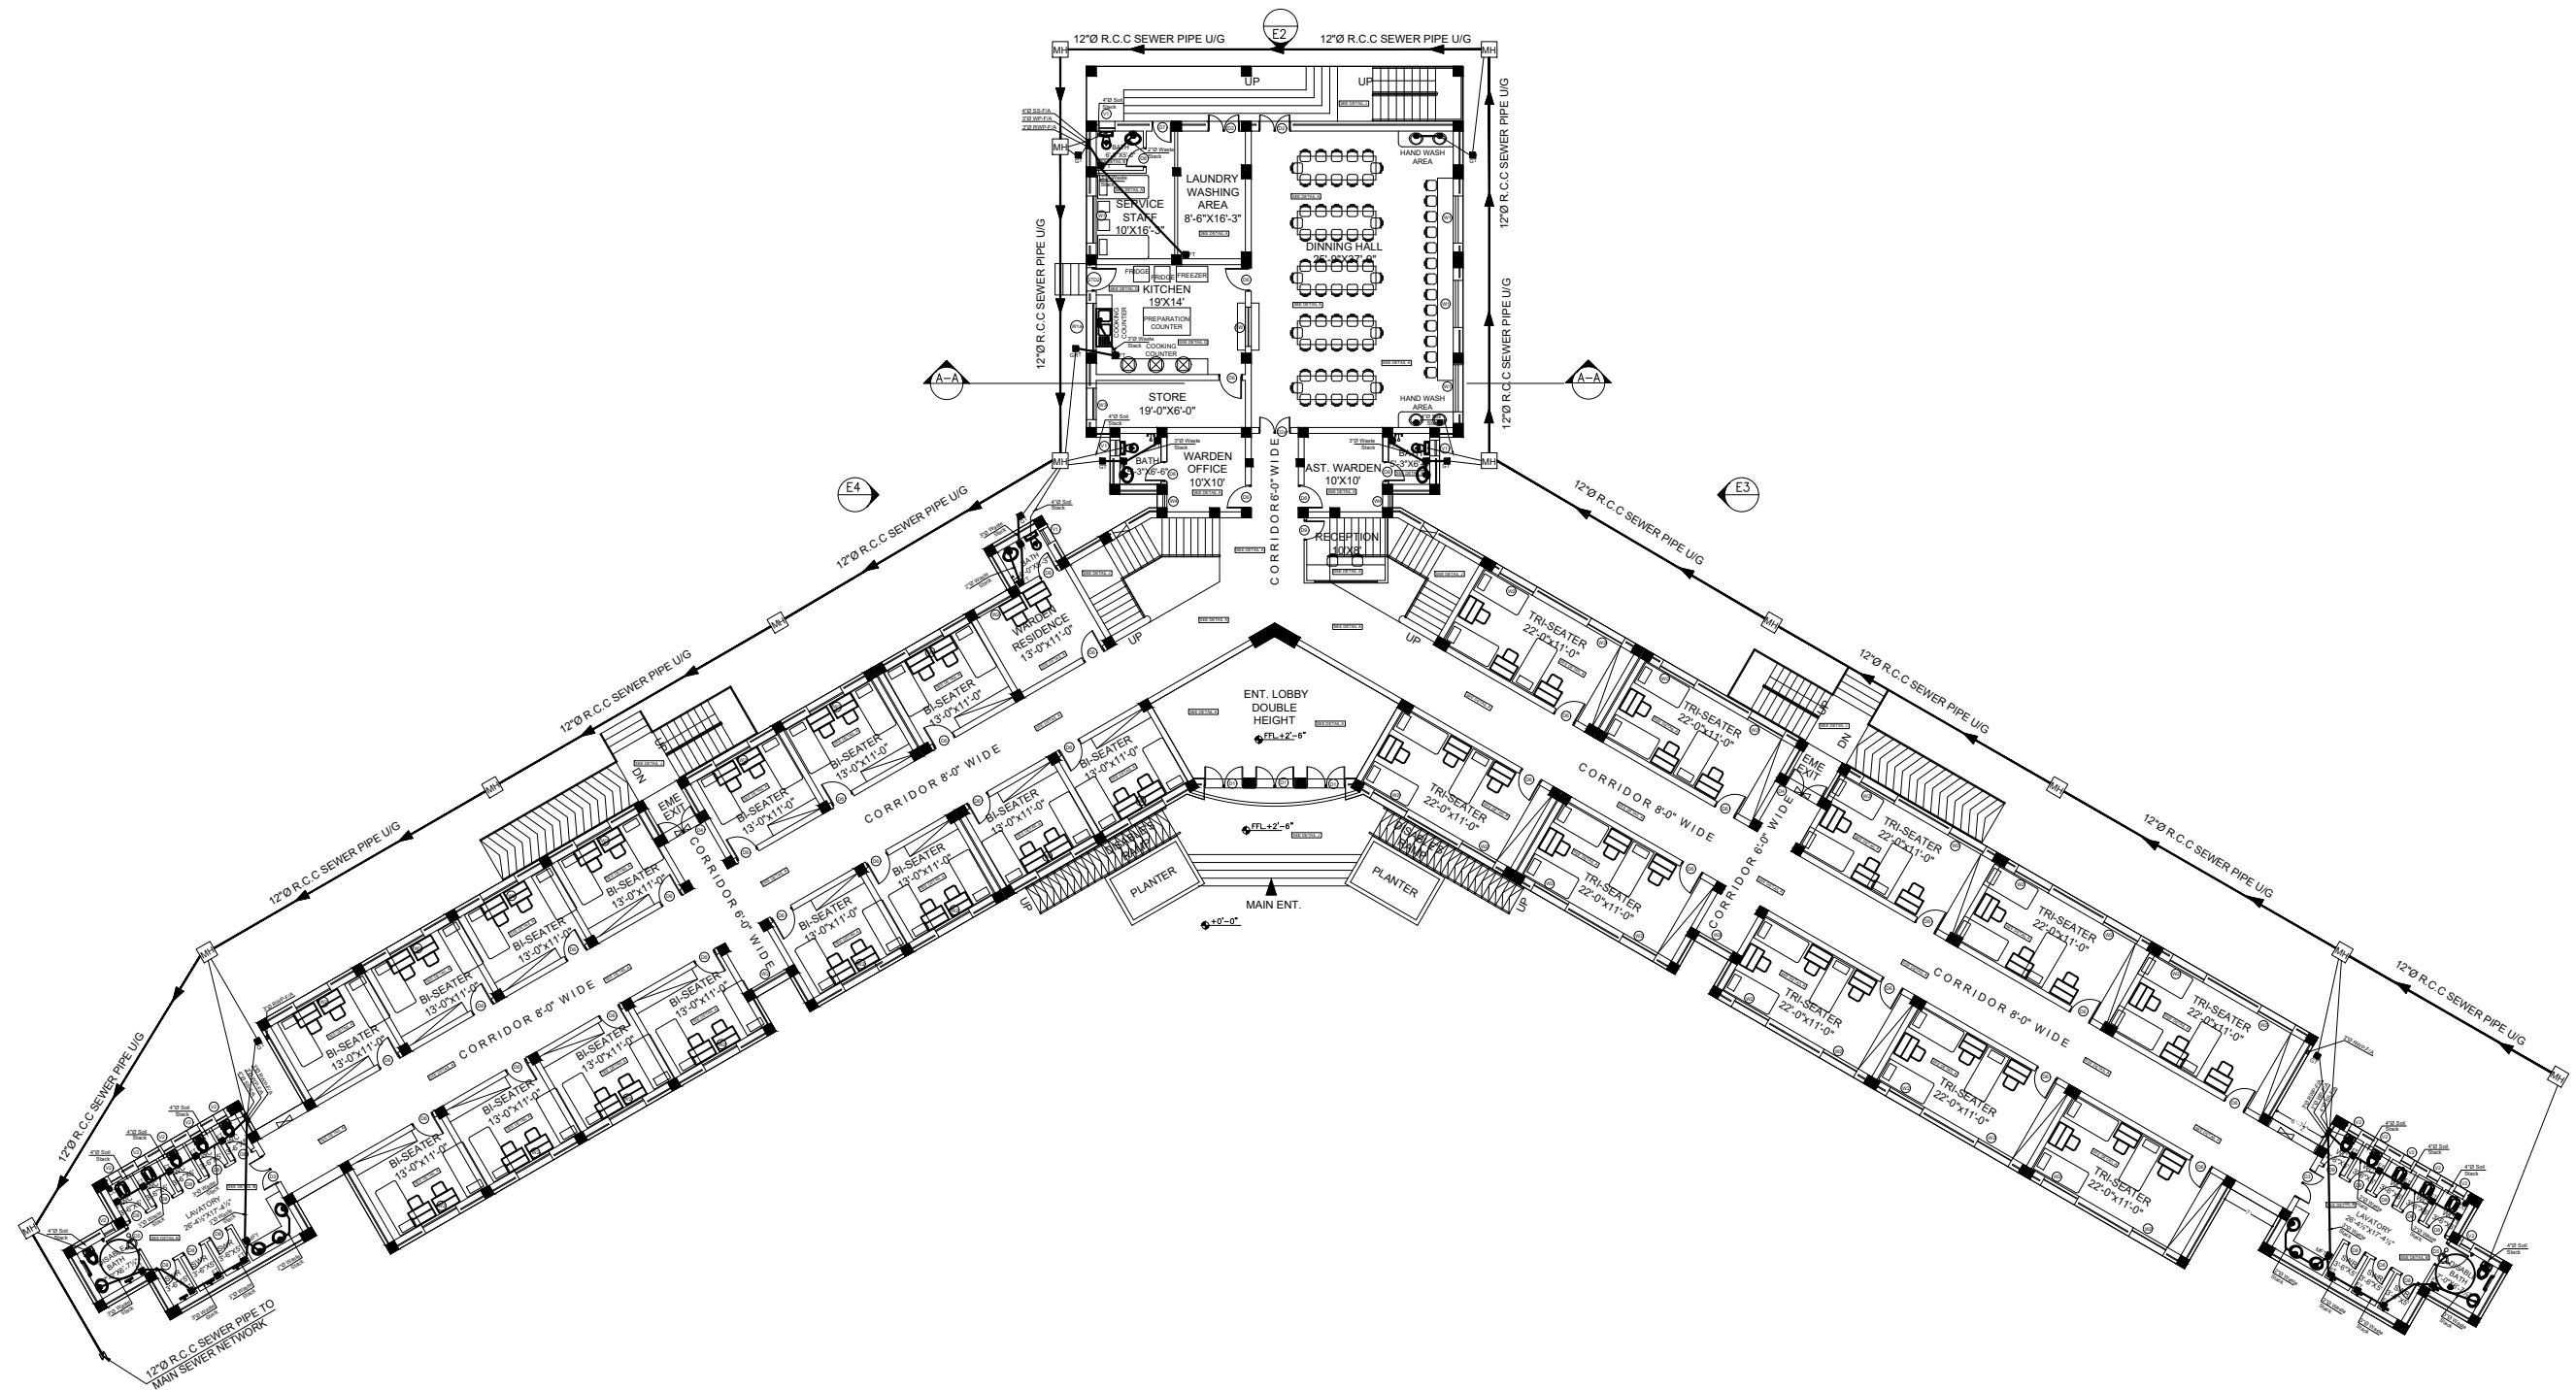

ADDITION & REVISION						
ADD./REV. NO.	DATE	DESCRIPTION	DES. BY	CHK. BY	APP. BY	



NEW VISION ENGINEERING CONSULTANT

Head Office: Office No.B-6 Second Floor Masood Arcade
IJP Road Islamabad.

Ph: +92-51-4848375, Fax: +92-51-4848375
Email: newvisionec@yahoo.com

Regional Office: 287-A Street # 6, Cavalry Ground ,Lahore
Ph: +92-42-37250130

PROJECT:
**"PROVISION OF MISSING FACILITIES FOR THE
SHAIKH AYAZ UNIVERSITY SHIKARPUR"**

TITLE:
**BOY'S / GIRL'S HOSTEL
GROUND FLOOR (SANITARY DRAINAGE LAYOUT)**

CAD filename:

CLIENT:
SHAIKH AYAZ UNIVERSITY SHIKARPUR

DESIGNED BY: MR.AHMAD	APPROVED BY: S A	DATE : AUGUST, 2022
DRAWN BY: RANA ALI HAIDER	JOB NO.	SCALE: N.T.S
DRG. NO.	PL-02	

	 Switch Board
	 10-/13 amp Light Plug sockets
 2' x 2' LED PANEL LIGHT	 20 amp Power Plug sockets
 20 Watt LED/Ceiling mounted Light Fixture, IP-44 rated	 A.C wall mounted 220 volt (-TON)
 15 Watt LED/Ceiling mounted Light Fixture, IP-44 rated	 A.C Floor Standing cabinet 440 volt (-TON)
 10 Watt LED/Ceiling mounted Light Fixture, IP-44 rated	 Manual call point and sounder with flasher
 40 Watt Luxline 4ft wall mounted Light Fixture, IP-44 rated	 FA Panel
 10 Watt Flood light	 smoke detector
 56" - 48" dia ceiling fan Fan shall be made with 99% purity Copper windings.	 CCTV Camera
 24 " outer dia industrial exhaust fan	 NVR
 12 " outer dia exhaust fan with plastic body,fan blades and louvers	
 24 " outer dia Bracket fan with plastic body,fan blades and louvers	 tv
	 Wifi
 Speaker	 DATA POINT
 Amplifier & PA system	 telephone
	 SUB DB

ADDITION & REVISION					
ADD./REV. NO.	DATE	DESCRIPTION	DES. BY	CHK. BY	APP. BY

DESIGNER:



NEW VISION ENGINEERING CONSULTANT
Head Office: Office No.B-6 SECOND FLOOR Masood Arcade
IJP Road Islamabad.
Ph: +92-51-4848375, Fax: +92-51-4848375
Email: newvisionec@yahoo.com
Regional Office: 287-A Street # 6, Cavalry Ground ,Lahore
Ph: +92-42-37250130

PROJECT:

"PROVISION OF MISSING FACILITIES FOR THE
SHAIKH AYAZ UNIVERSITY SHIKARPUR"

TITLE:

**BOY'S / GIRL'S HOSTEL
LEGENDS AND SYMBOLS**

CAD filename:

CLIENT:

SHAIKH AYAZ UNIVERSITY SHIKARPUR

DESIGNED BY:

Mr. Shadab

APPROVED BY:

S A

DATE :

AUGUST, 2022

DRAWN BY:

Mr.RANA ALI HAIDER

JOB NO.

SCALE:

N.T.S

DRG. NO.

EL-02



"PROVISION OF MISSING FACILITIES FOR THE SHAIKH AYAZ UNIVERSITY SHIKARPUR"



CAFETERIA VOLUME III TENDER DRAWINGS DEC, 2022

DESIGN BY



NEW VISION ENGINEERING CONSULTANT

HEAD OFFICE:

Office No.B-6 Second Floor Masood Arcade
IJP Road Islamabad.


Ph: +92-51-4848375, Fax: +92-51-4848375

Email: newvisionec@yahoo.com

REGIONAL OFFICE:

287-A Street # 6,
Cavalry Ground ,Lahore

Ph: +92-42-37250130

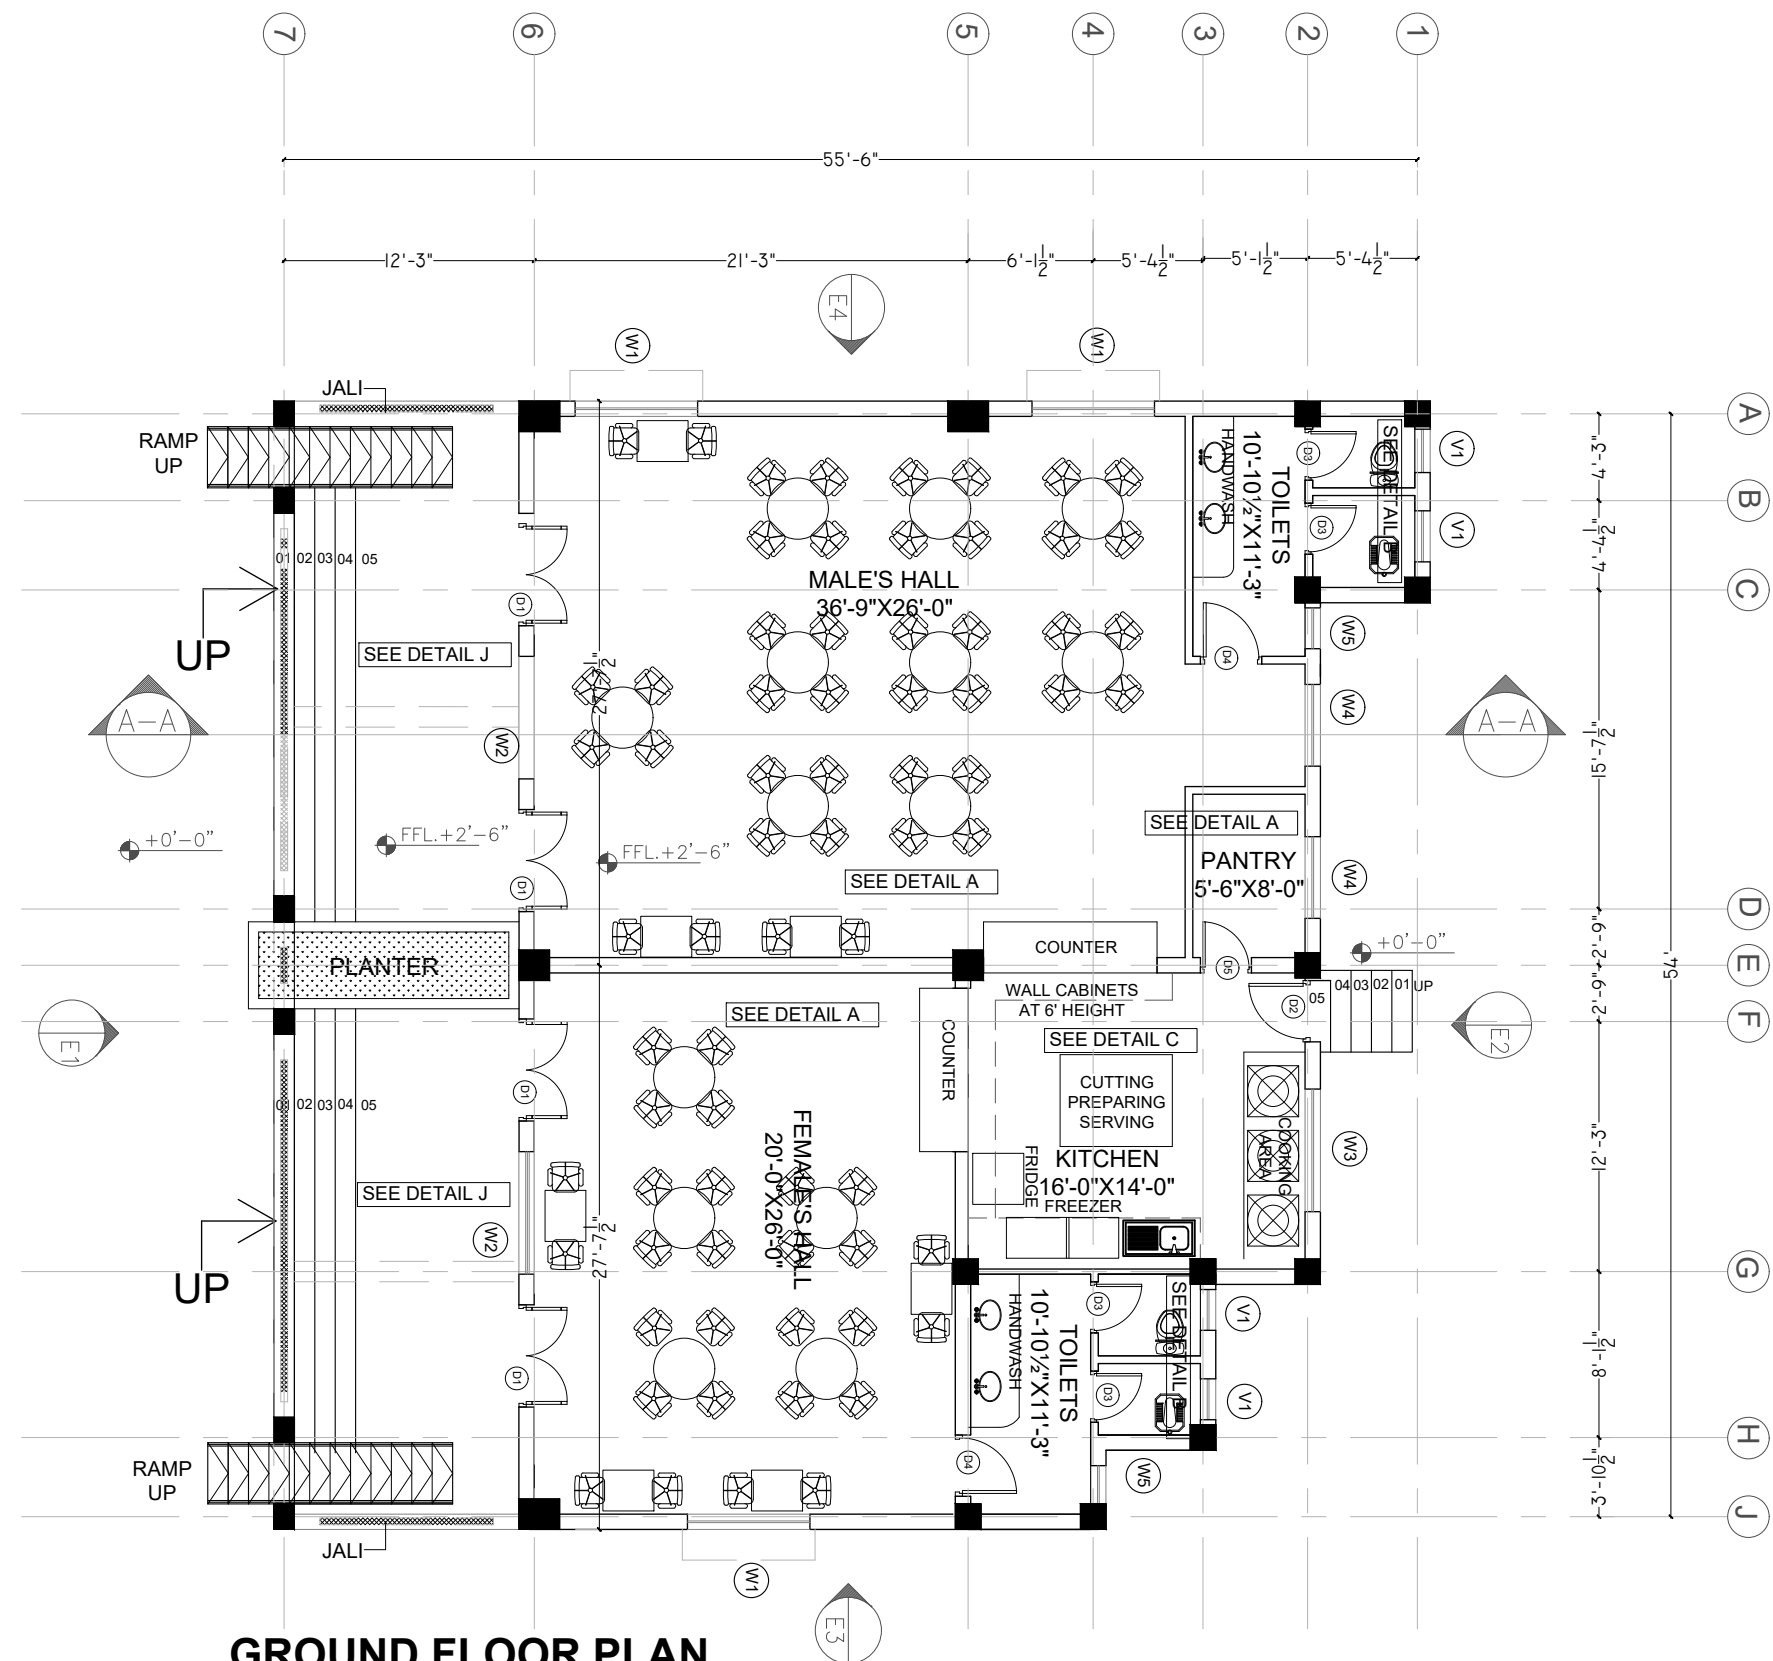

TOTAL COVERED AREA = 2471

AR-01



"PROVISION OF MISSING FACILITIES FOR THE SHAIKH AYAZ UNIVERSITY SHIKARPUR"

ROAD WORK TENDER DRAWINGS SEP, 2022

DESIGN BY



NEW VISION ENGINEERING CONSULTANT

HEAD OFFICE:

Office No.B-6 Second Floor Masood Arcade
IJP Road Islamabad.


Ph: +92-51-4848375, Fax: +92-51-4848375

Email: newvisionec@yahoo.com

REGIONAL OFFICE:

287-A Street # 6,
Cavalry Ground ,Lahore

Ph: +92-42-37250130

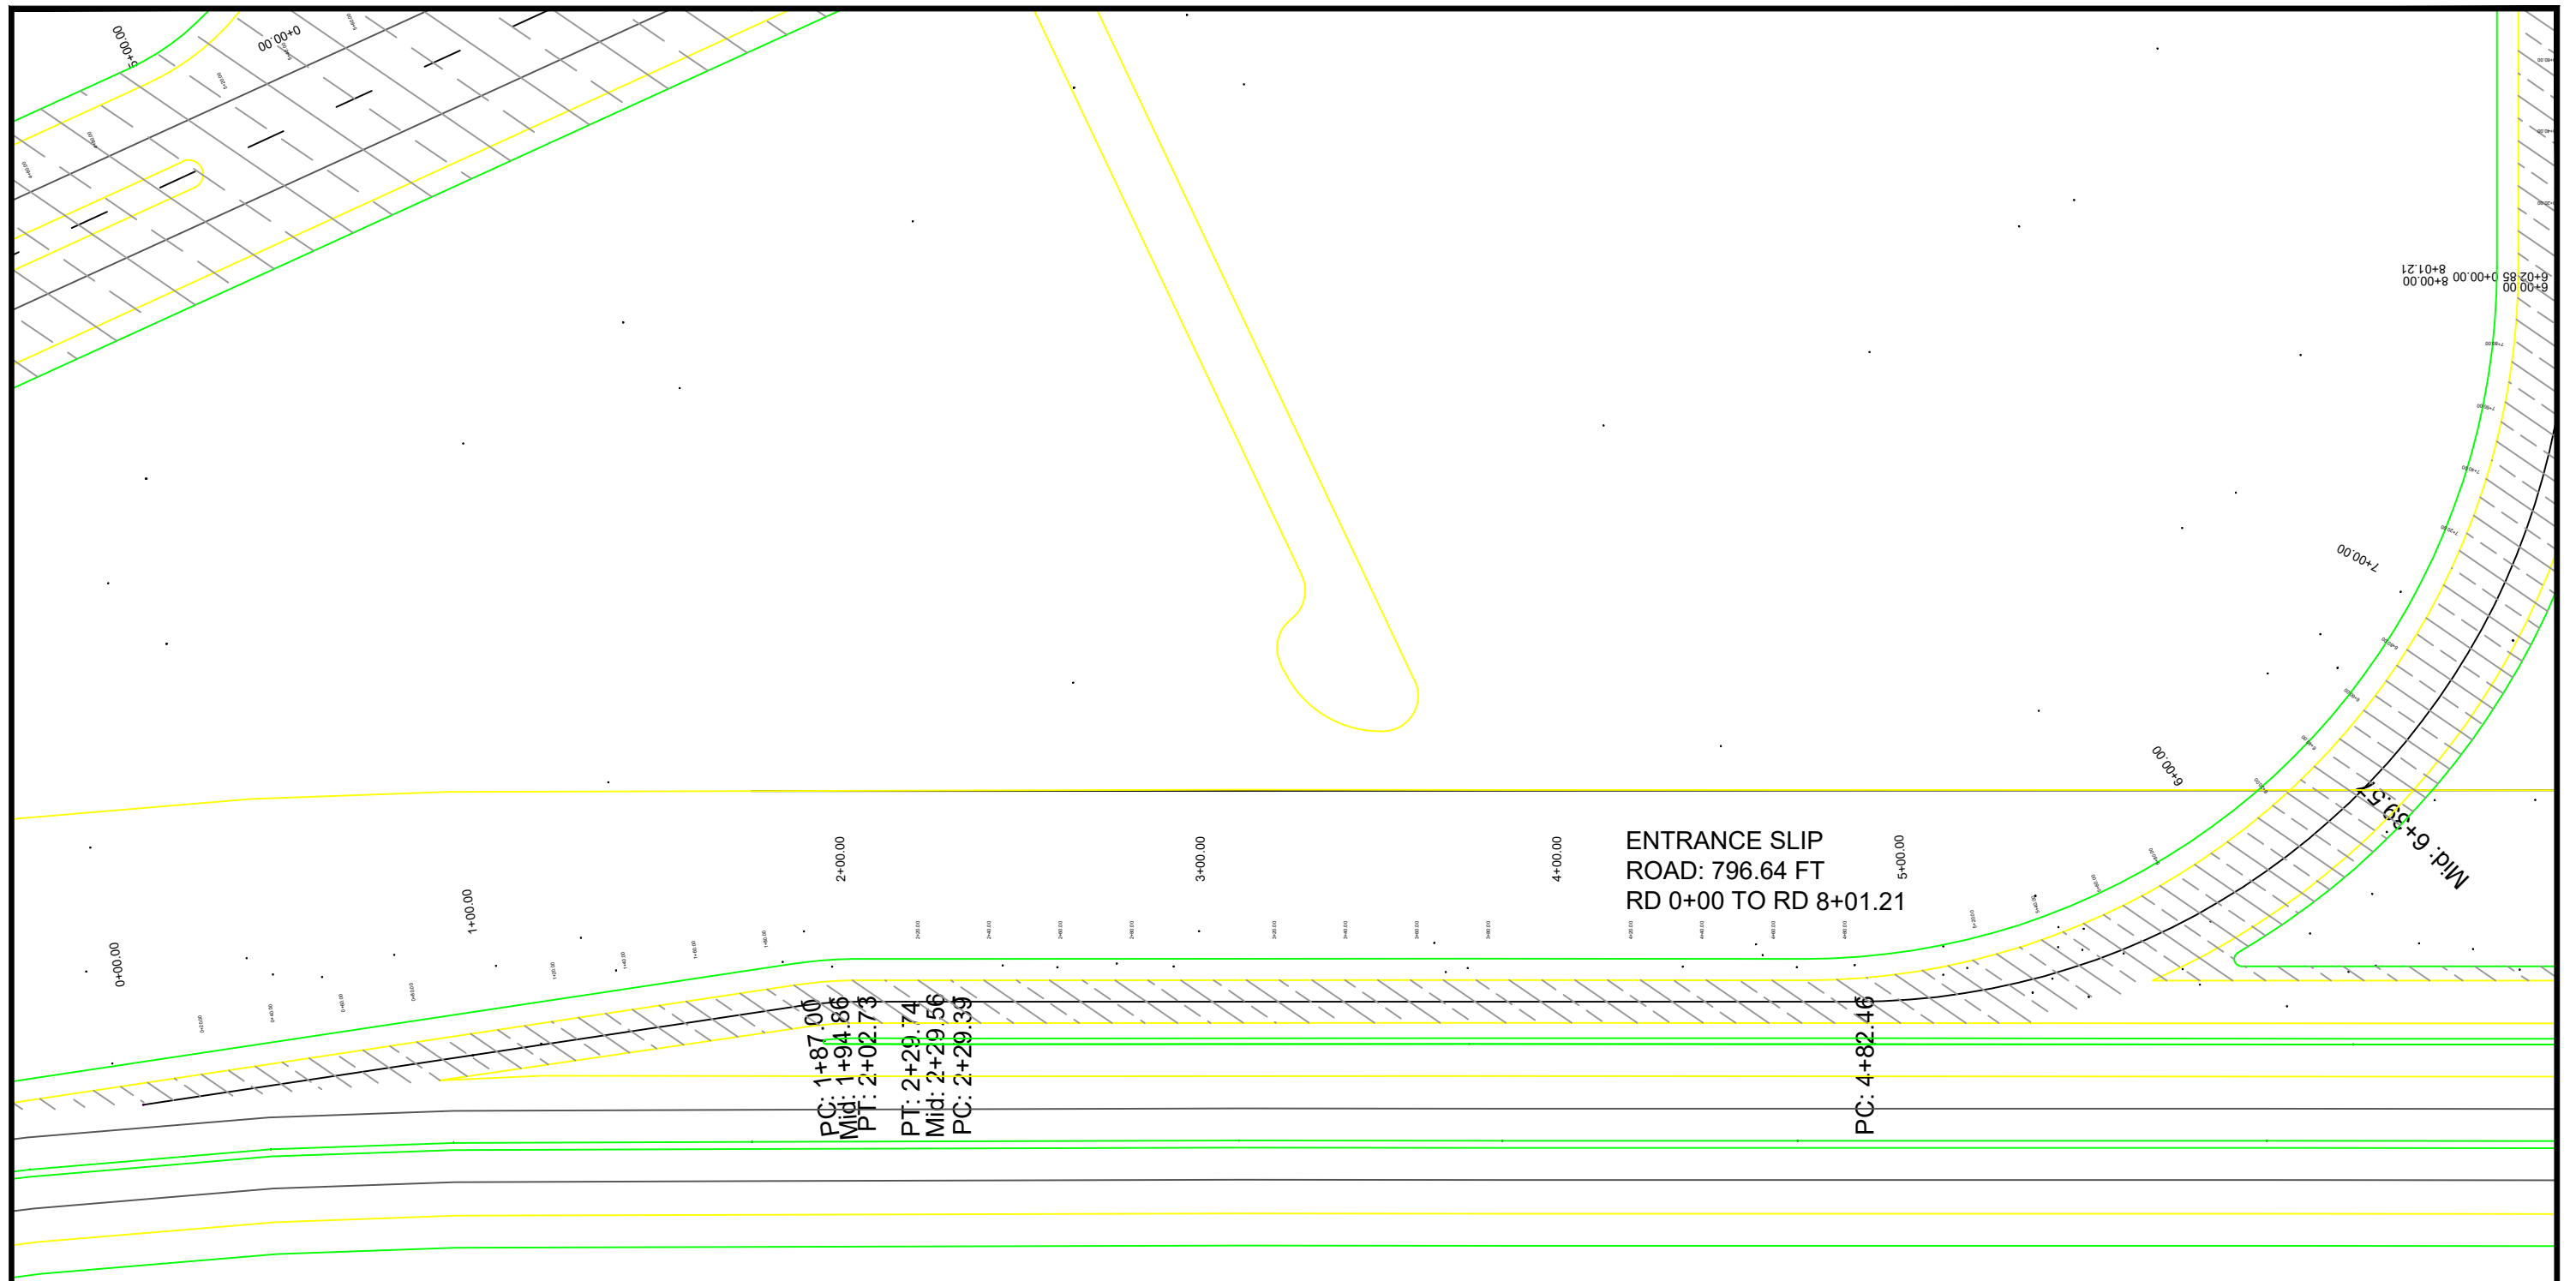

PC: 1+87.00
Mid: 1+94.86
PT: 2+02.73
PT: 2+29.74
Mid: 2+29.56
PC: 2+29.39

PC: 4+82.46

ENTRANCE SLIP
ROAD: 796.64 FT
RD 0+00 TO RD 8+01.21

Mid: 6+39.57
7+00.00
8+00.00
8+01.21


ADDITION & REVISION					
ADD./REV. NO.	DATE	DESCRIPTION	DES. BY	CHK. BY	APP. BY

DESIGNER :


NEW VISION ENGINEERING CONSULTANT
Head Office: Office No. B-6 Second Floor Masood Arcade
IJP Road Islamabad.
Ph: +92-51-4848374, Fax: +92-51-4848375
Email: newvisionec@yahoo.com
Regional Office: 287-A Street # 06 Cavalry Ground Cantt.
Lahore.
Ph: +92-42-37250130

PROJECT:	ESTABLISHMENT OF SHIEKH AYAZ UNIVERSITY SHIKARPUR
TITLE:	ENTRANCE SLIP ROAD PLAN

CLIENT: SHIEKH AYAZ UNIVERSITY SHIKARPUR		
DESIGNED BY: AB	APPROVED BY: MR	DATE: SEP, 2022
PREPARED BY: AB	JOB NO.	SCALE: AS SHOWN
CHECKED BY: MF	DRG. NO.	02

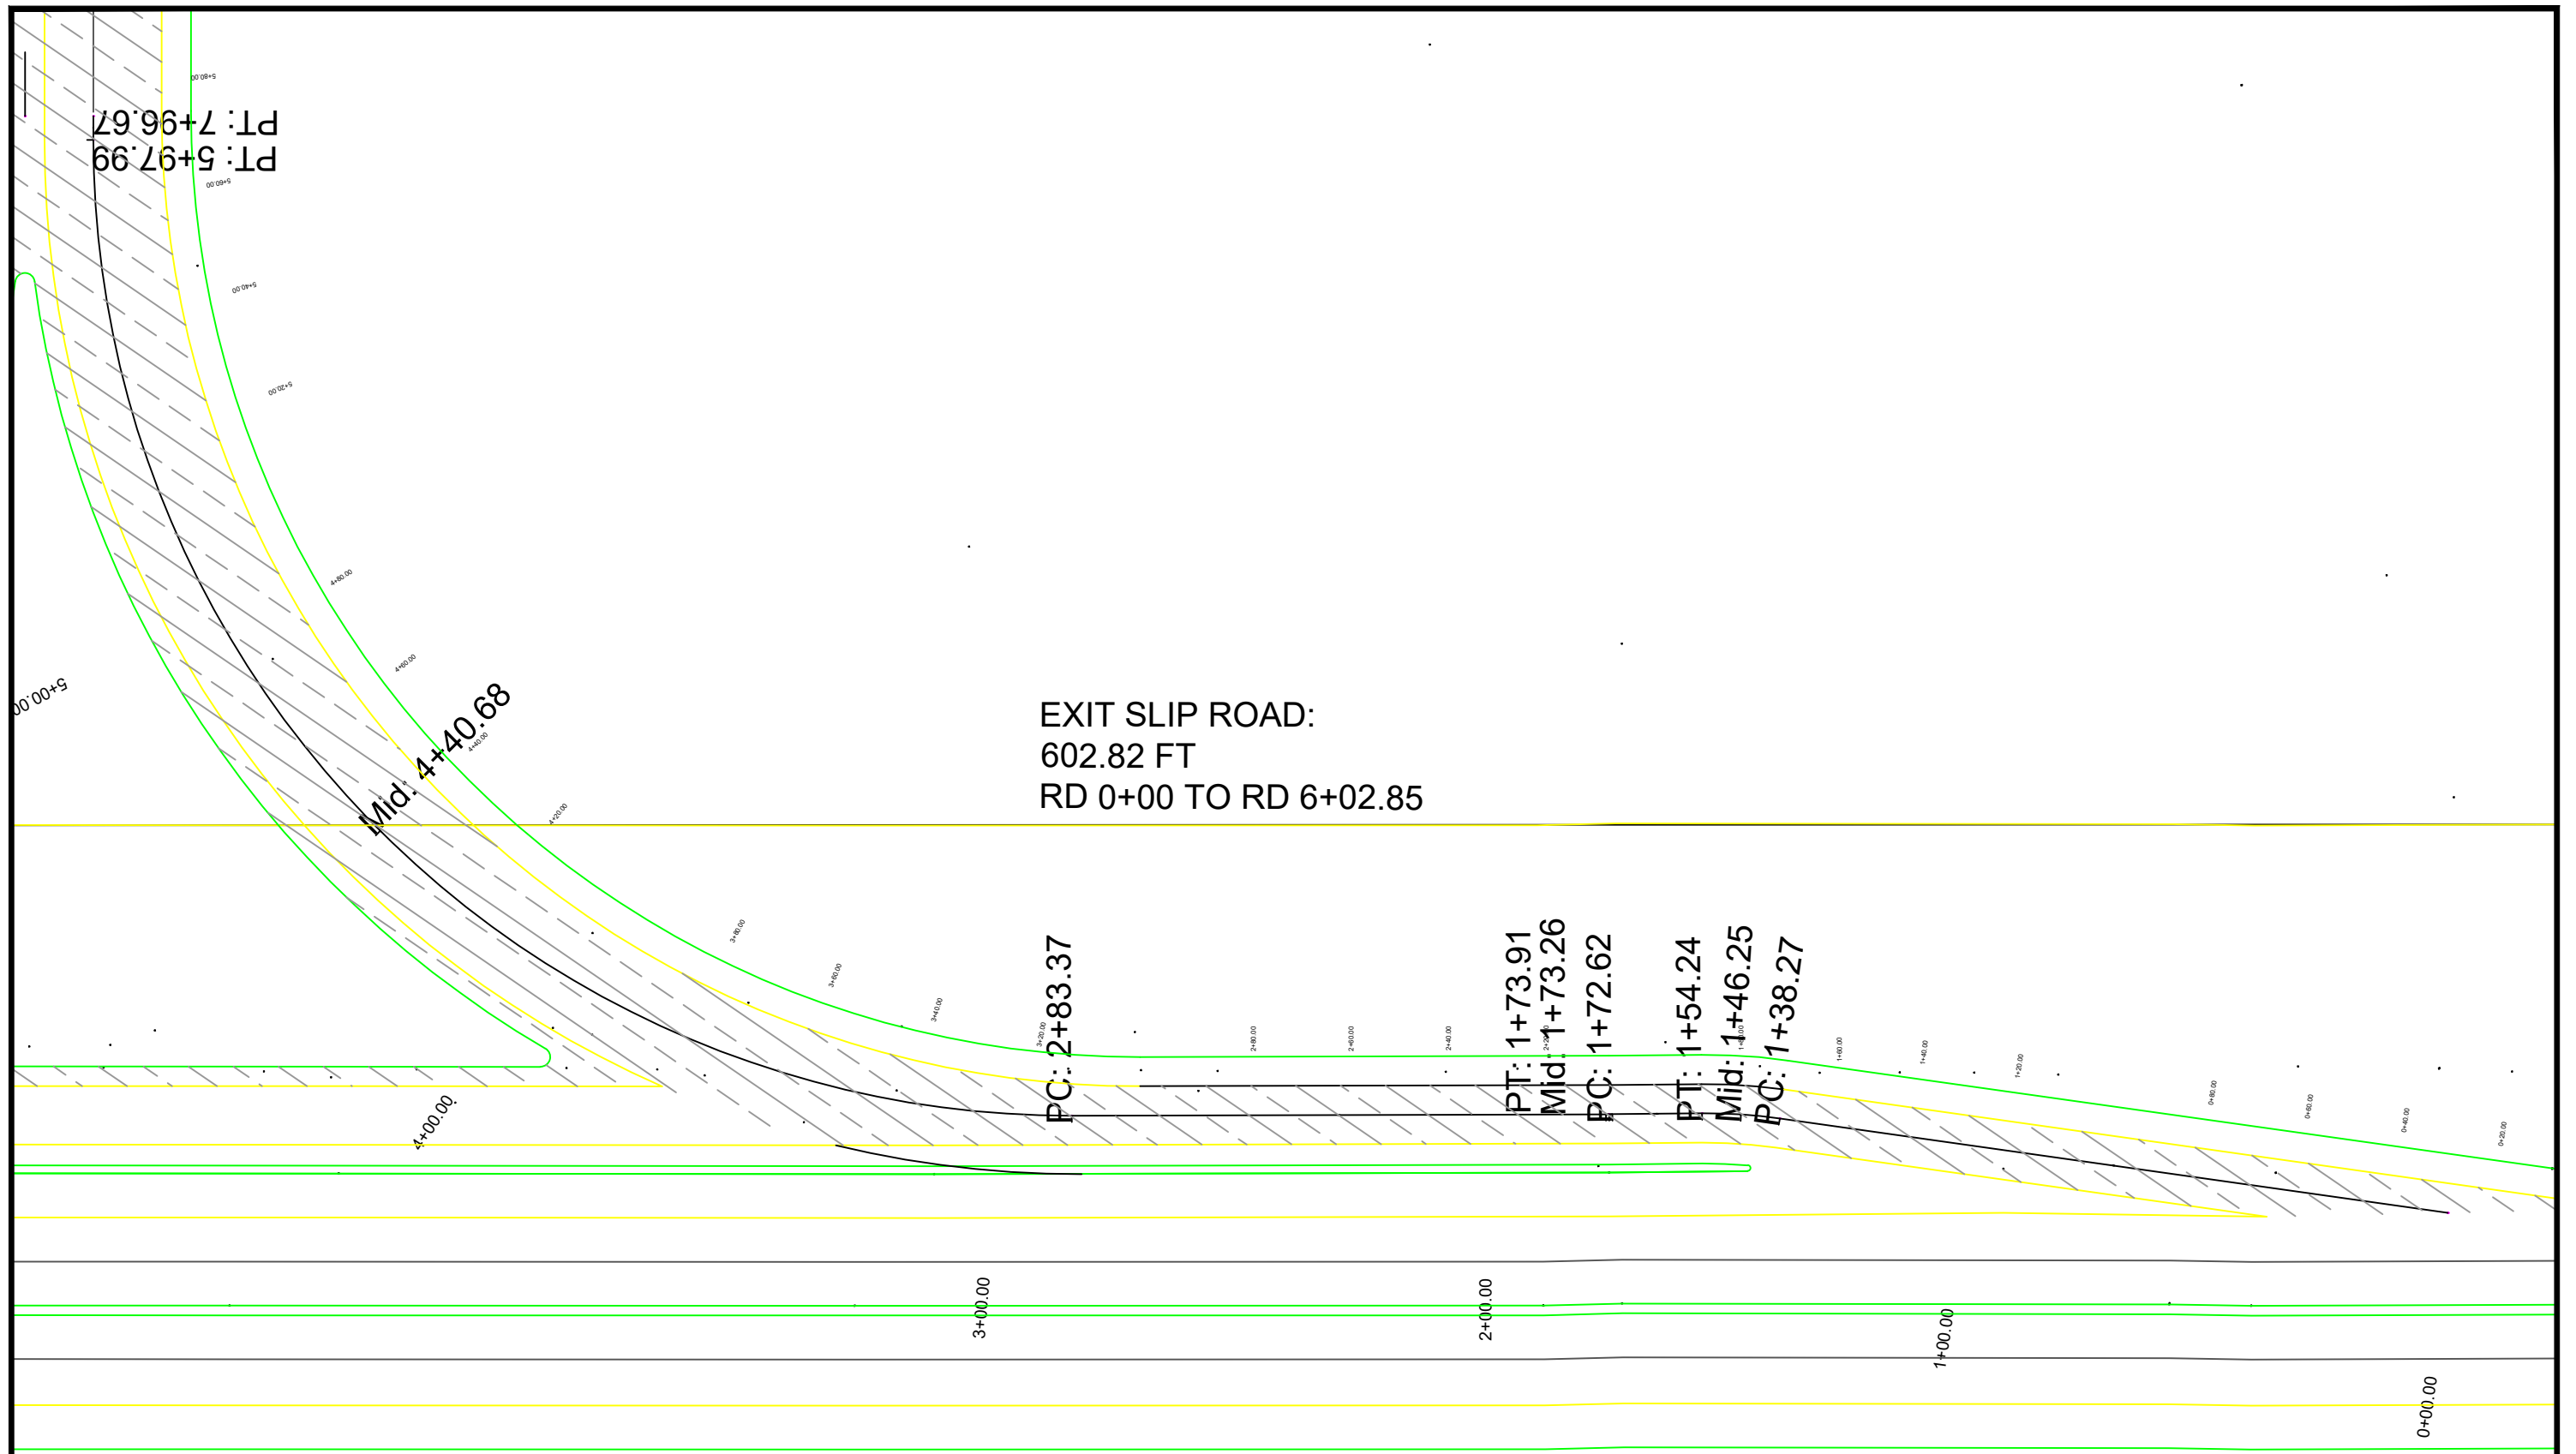

EXIT SLIP ROAD:
602.82 FT
RD 0+00 TO RD 6+02.85


ADDITION & REVISION					
ADD./REV. NO.	DATE	DESCRIPTION	DES. BY	CHK. BY	APP. BY



NEW VISION ENGINEERING CONSULTANT
Head Office: Office No. B-6 Second Floor Masood Arcade
IJP Road Islamabad.
Ph: +92-51-4848374, Fax: +92-51-4848375
Email: newvisionec@yahoo.com
Regional Office: 287-A Street # 06 Cavalry Ground Cantt.
Lahore.
Ph: +92-42-37250130

PROJECT:	ESTABLISHMENT OF SHIEKH AYAZ UNIVERSITY SHIKARPUR	
TITLE:	EXIT SLIP ROAD PLAN	

CLIENT:	SHIEKH AYAZ UNIVERSITY SHIKARPUR		
DESIGNED BY:	AB	APPROVED BY: MR	DATE: SEP, 2022
PREPARED BY:	AB	JOB NO.	SCALE: AS SHOWN
CHECKED BY:	MF	DRG. NO.	03

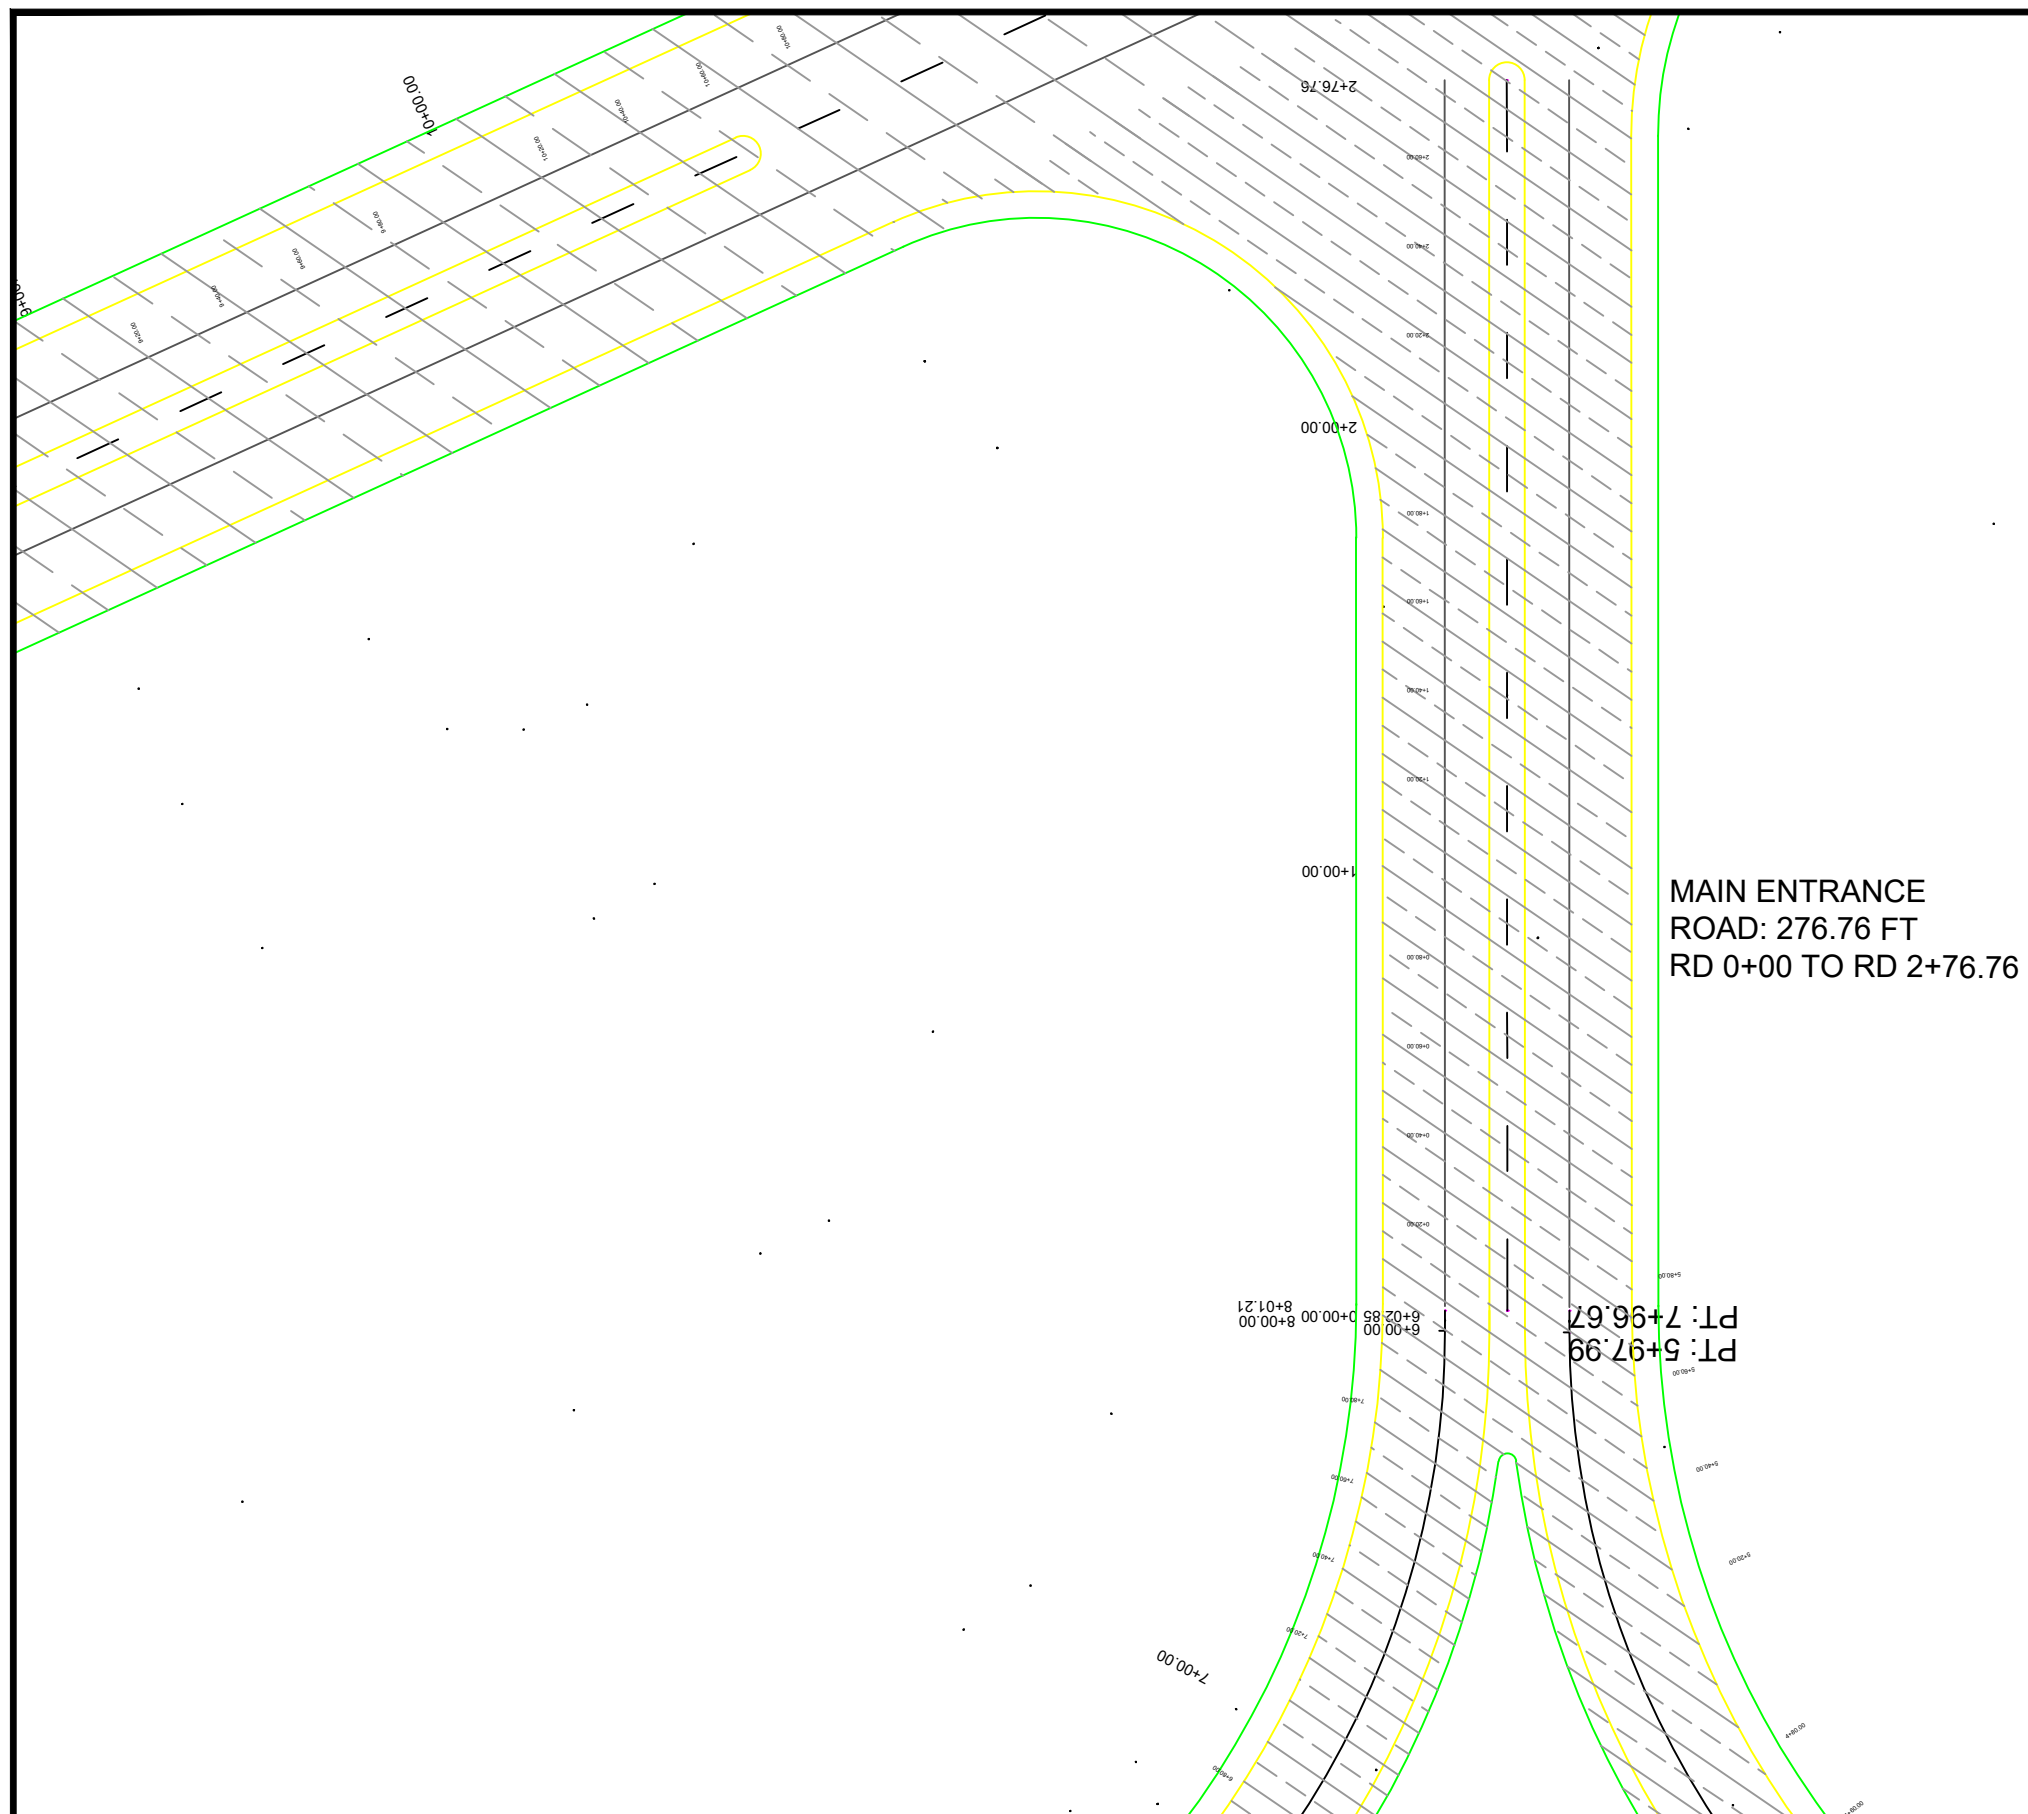

ADDITION & REVISION					
ADD./REV. NO.	DATE	DESCRIPTION	DES. BY	CHK. BY	APP. BY

DESIGNER :



NEW VISION ENGINEERING CONSULTANT

Head Office: Office No. B-6 Second Floor Masood Arcade
IJP Road Islamabad.

Ph: +92-51-4848374, Fax: +92-51-4848375
Email: newvisionec@yahoo.com

Regional Office: 287-A Street # 06 Cavalry Ground Cantt.
Lahore.

Ph: +92-42-37250130

PROJECT:

CT: ESTABLISHMENT OF
SHIEKH AYAZ UNIVERSITY
SHIKARPUR

TITLE:

MAIN ENTRANCE ROAD PLAN

CLIENT:

SHIEKH AYAZ UNIVERSITY
SHIKARPUR

DESIGNED BY:	AB
--------------	----

APPROVED BY: MR

DATE. SEP, 2022

PREPARED BY:
AB

JOB NO.


SCALE: AS SHOWN

CHECKED BY:
MF



DRG. NO.


04

FOR CIRCULAR ROADS

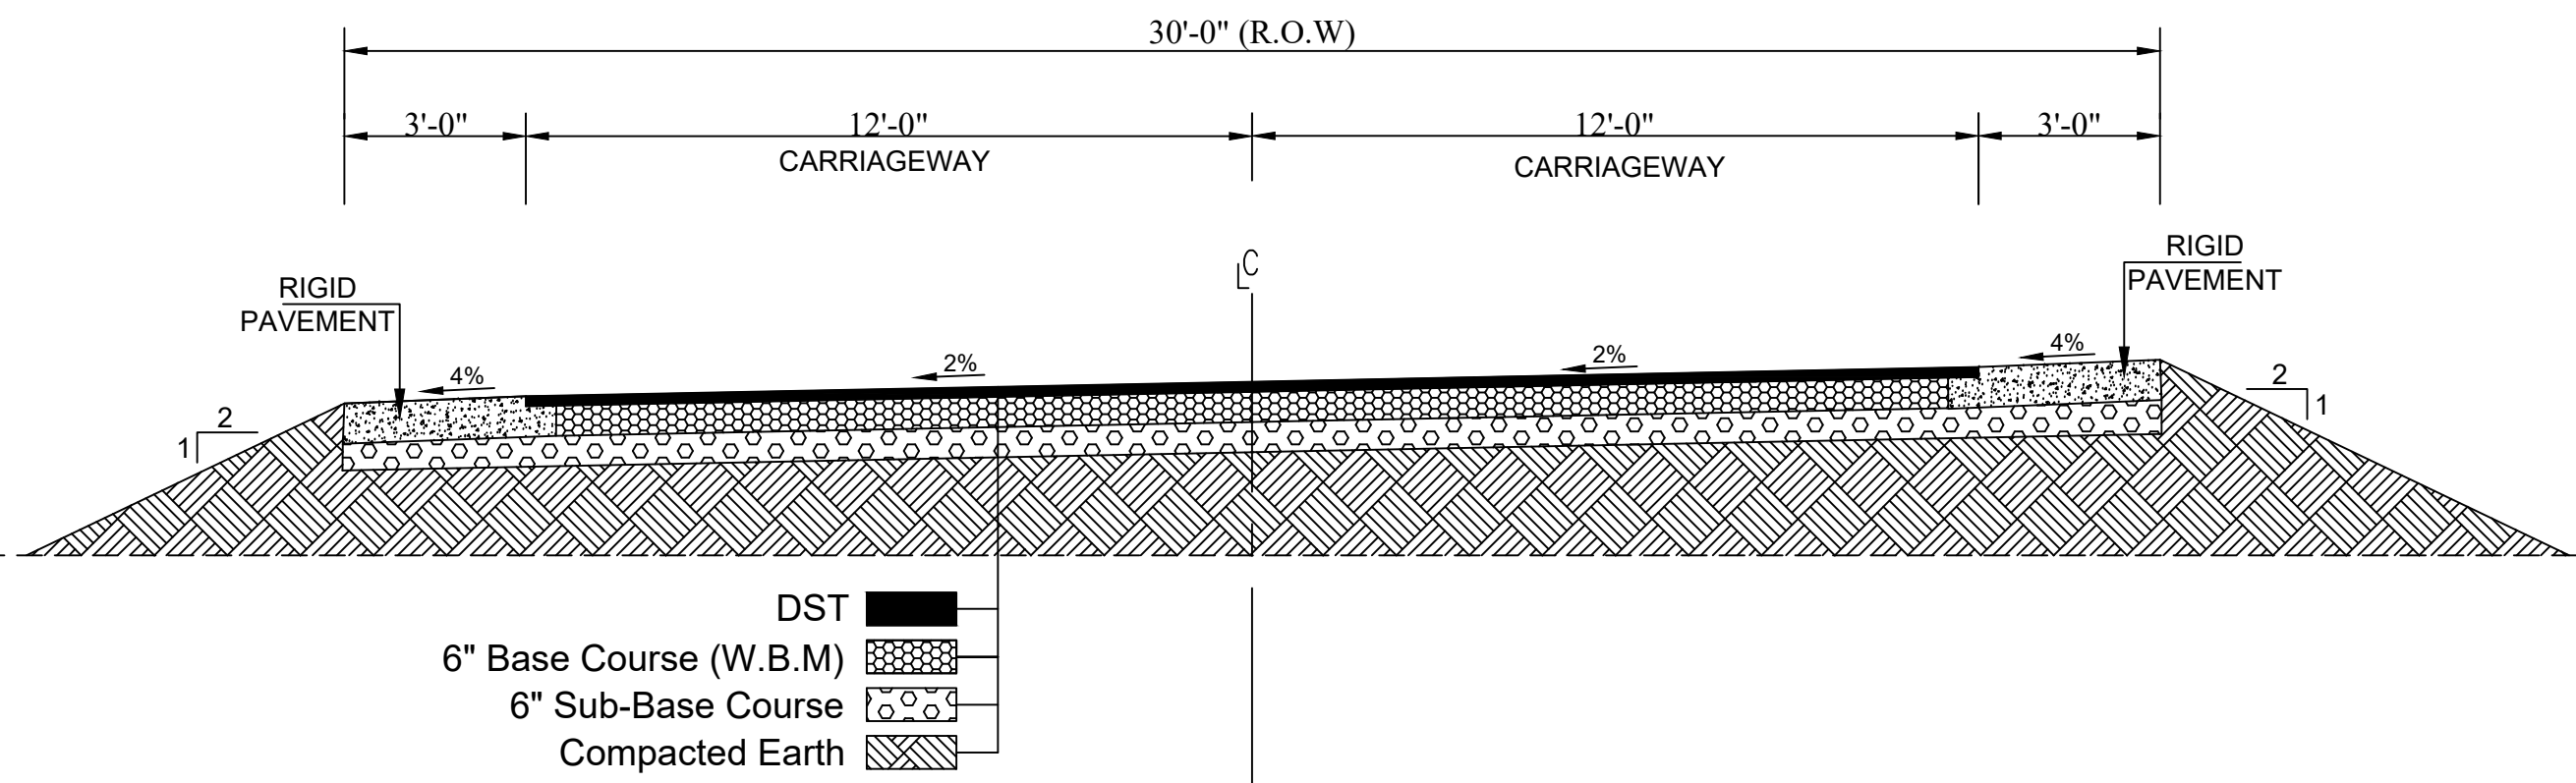


DESIGNER :  NEW VISION ENGINEERING CONSULTANT Head Office: Office No. B-6 Second Floor Masood Arcade IJP Road Islamabad. Ph: +92-51-4848374, Fax: +92-51-4848375 Email: newvisionec@yahoo.com Regional Office: 287-A Street # 06 Cavalry Ground Cantt. Lahore. Ph: +92-42-37250130							PROJECT: PROVISION OF MISSING FACILITIES SHIEKH AYAZ UNIVERSITY SHIKARPUR			CLIENT: SHIEKH AYAZ UNIVERSITY SHIKARPUR					
							TITLE: TYPICAL SECTION FOR CIRCULAR ROADS			DESIGNED BY: ENG.M.ASIF		APPROVED BY: MR		DATE: SEP, 2022	
										PREPARED BY: ABDUL BAIS		JOB NO.		SCALE: AS SHOWN	
										CHECKED BY: ENG.M.ASIF		DRG. NO.		02	
							ADD./REV. NO.		DATE		DESCRIPTION		DES. BY		CHK. BY

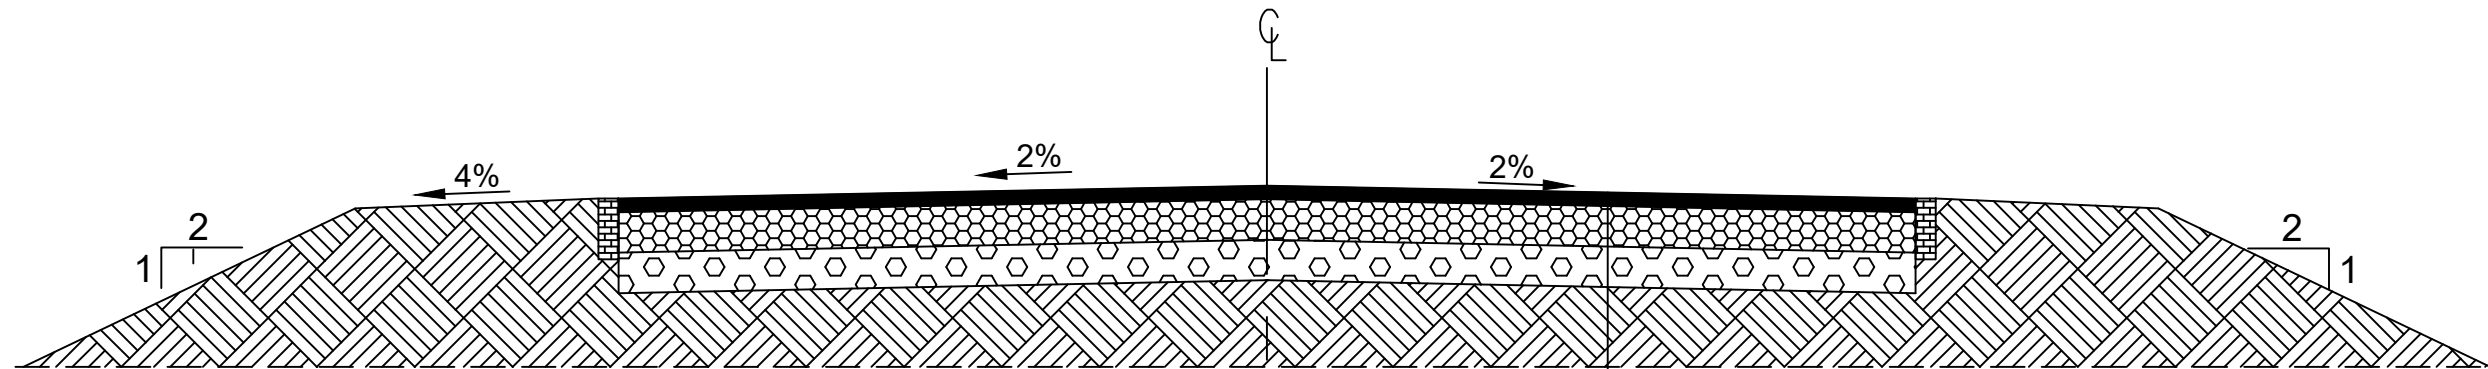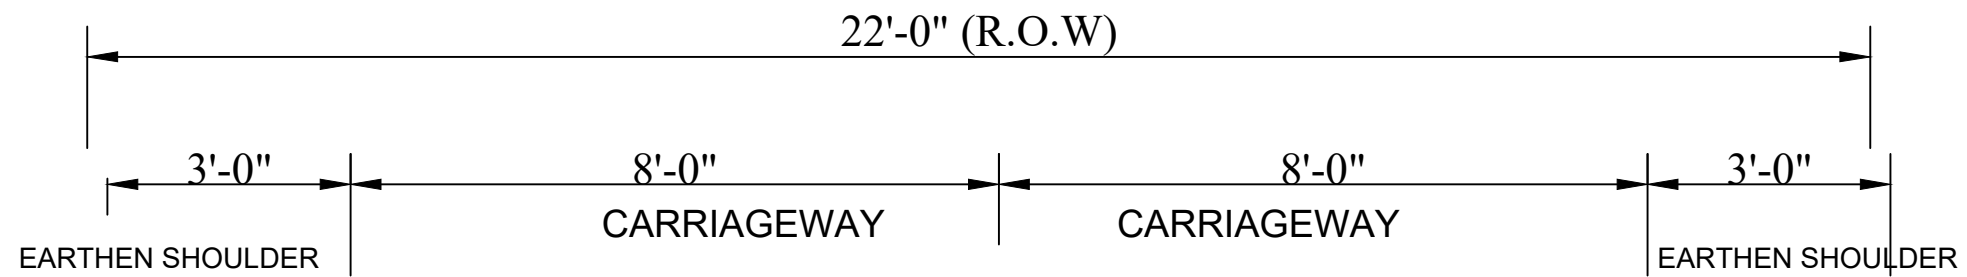

 -  DST
-  6" Base Course (W.B.M)
-  6" Sub-Base Course
-  Compacted Earth

						ADDITION & REVISION		DESIGNER :  NEW VISION ENGINEERING CONSULTANT Head Office: Office No. B-6 Second Floor Masood Arcade IJP Road Islamabad. Ph: +92-51-4848374, Fax: +92-51-4848375 Email: newvisionec@yahoo.com Regional Office: 287-A Street # 06 Cavalry Ground Cantt. Lahore. Ph: +92-42-37250130		PROJECT: PROVISION OF MISSING FACILITIES SHIEKH AYAZ UNIVERSITY SHIKARPUR TITLE: TYPICAL SECTION FOR LINK ROADS		CLIENT: SHIEKH AYAZ UNIVERSITY SHIKARPUR DESIGNED BY: ENG.M.ASIF APPROVED BY: MR DATE. SEP, 2022 PREPARED BY: ABDUL BAIS JOB NO. SCALE: AS SHOWN CHECKED BY: ENG.M.ASIF DRG. NO. 03																																																																																																																																																																																																																																																																																																																																																																																																																																																																																																																																																																																																																																																																																																																																																																																																																																																																																																																																																																																																																																																																																																																																																																																																																																																																																														

For 12' Carriageway Slip Road

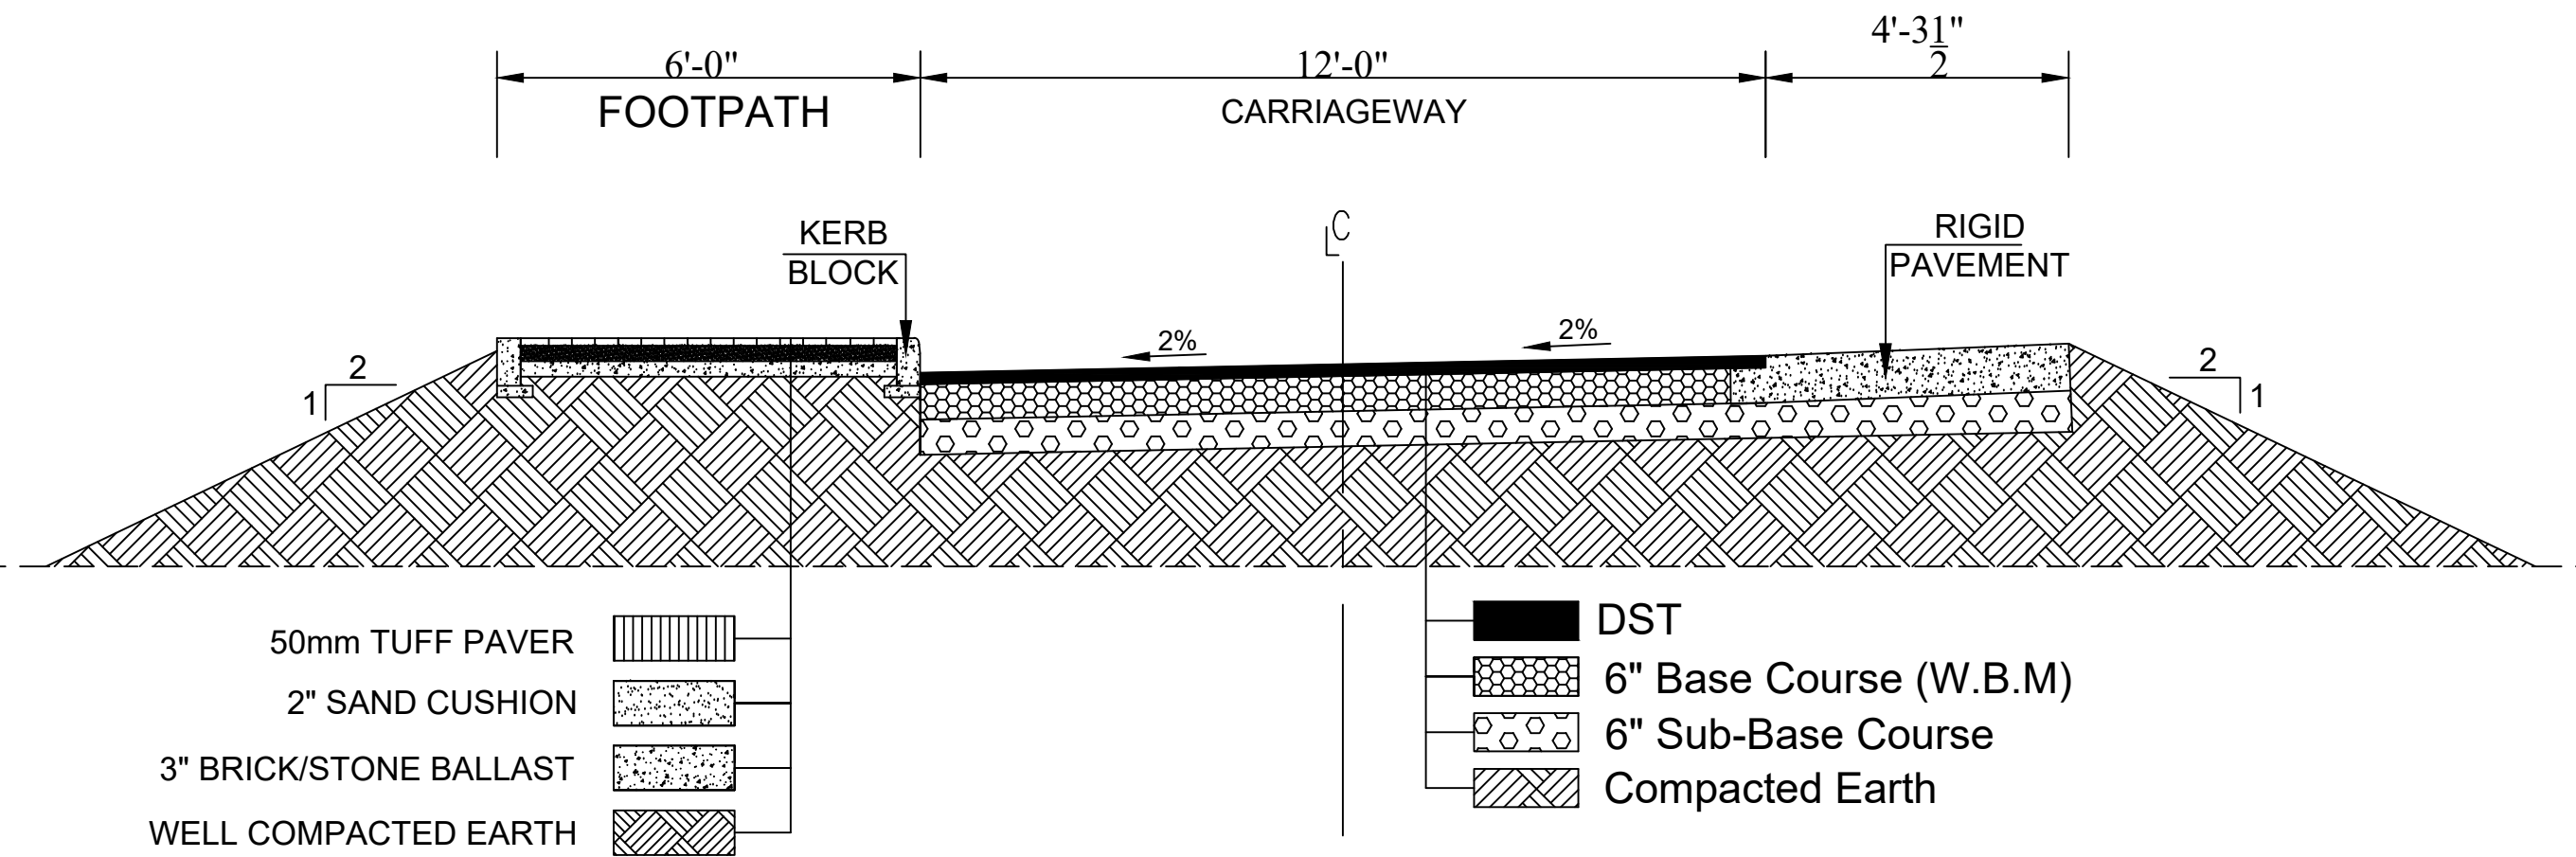

ADDITION & REVISION						
ADD./REV. NO.	DATE	DESCRIPTION	DES. BY	CHK. BY	APP. BY	

DESIGNER :



NEW VISION ENGINEERING CONSULTANT

Head Office: Office No. B-6 Second Floor Masood Arcade
IJP Road Islamabad.

Ph: +92-51-4848374, Fax: +92-51-4848375
Email: newvisionec@yahoo.com

Regional Office: 287-A Street # 06 Cavalry Ground Cantt.
Lahore.

Ph: +92-42-37250130

PROJECT:

PROJECT: **PROVISION OF MISSING FACILITIES
SHIEKH AYAZ UNIVERSITY
SHIKARPUR**

TITLE:

TYPICAL SECTION
FOR
12' CARRIAGEWAY SLIP ROADS

CLIENT:

SHIEKH AYAZ UNIVERSITY
SHIKARPUR

DESIGNED BY:
ENG.M.ASIF

APPROVED BY: MR

DATE. SEP, 2022

PREPARED BY:
ABDUL BAIS

JOB NO.


SCALE: AS SHOWN

CHECKED BY:
ENG.M.ASIF


DRG. NO.

04


For 24' Carriage Way Slip Road

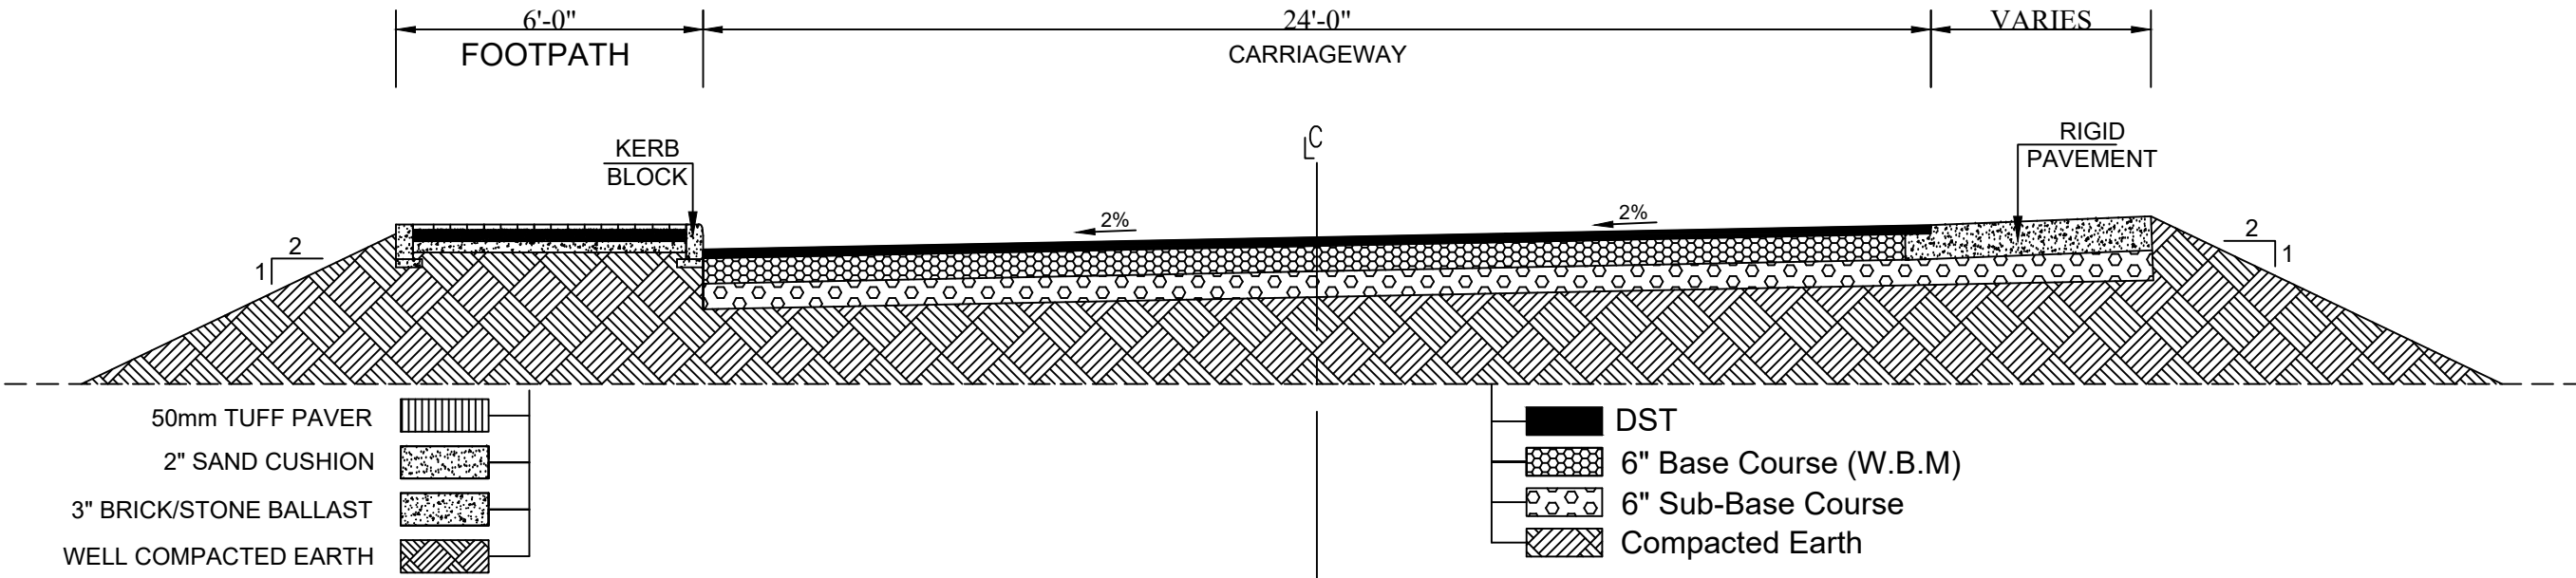

						ADDITION & REVISION				DESIGNER :  NEW VISION ENGINEERING CONSULTANT Head Office: Office No. B-6 Second Floor Masood Arcade IJP Road Islamabad. Ph: +92-51-4848374, Fax: +92-51-4848375 Email: newvisionec@yahoo.com Regional Office: 287-A Street # 06 Cavalry Ground Cantt. Lahore. Ph: +92-42-37250130		PROJECT:		PROVISION OF MISSING FACILITIES SHIEKH AYAZ UNIVERSITY SHIKARPUR				CLIENT:		SHIEKH AYAZ UNIVERSITY SHIKARPUR			
						TITLE:		TYPICAL SECTION FOR 24' CARRIAGEWAY SLIP ROADS				DESIGNED BY:		APPROVED BY: MR		DATE: SEP, 2022							
												ENG.M.ASIF											
												PREPARED BY:		JOB NO.		SCALE: AS SHOWN							
												ABDUL BAIS											
						CHECKED BY:		DRG. NO.				05											
ENG.M.ASIF																							
ADD./REV. NO.	DATE	DESCRIPTION	DES. BY	CHK. BY	APP. BY																		

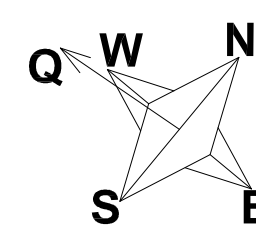

ADDITION & REVISION					
ADD/REV. NO.	DATE	DESCRIPTION	DES. BY	CHK. BY	APP. BY

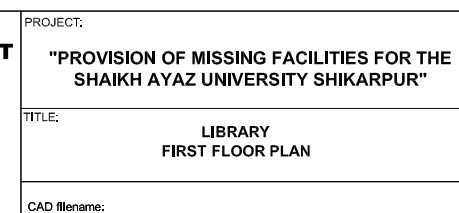

CLIENT:		
SHAikh AYAZ UNIVERSITY SHIKARPUR		
DESIGNED BY: AR,SALMAN	APPROVED BY:	DATE : JUNE, 2022
DRAWN BY: RIZWAN	JOB NO.	SCALE: N.T,S
DRG. NO.		

"PROVISION OF MISSING FACILITIES FOR THE SHAIKH AYAZ UNIVERSITY SHIKARPUR"



LIBRARY VOLUME III TENDER DRAWINGS DEC, 2022

DESIGN BY



NEW VISION ENGINEERING CONSULTANT

HEAD OFFICE:


Office No.B-6 Second Floor Masood Arcade
IJP Road Islamabad.

Ph: +92-51-4848375, Fax: +92-51-4848375
Email: newvisionec@yahoo.com

REGIONAL OFFICE:

287-A Street # 6,
Cavalry Ground ,Lahore
Ph: +92-42-37250130

3D VIEWS LIBRARY

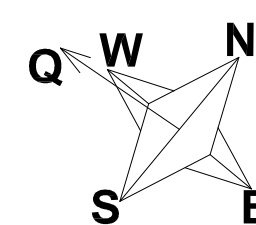


ADDITION & REVISION					
ADD/REV. NO.	DATE	DESCRIPTION	DES. BY	CHK. BY	APP. BY



PROJECT:	"PROVISION OF MISSING FACILITIES FOR THE SHAikh AYAZ UNIVERSITY SHIKARPUR"
TITLE:	LIBRARY FIRST FLOOR PLAN
CAD filename:	

CLIENT:		
SHAikh AYAZ UNIVERSITY SHIKARPUR		
DESIGNED BY: AR,SALMAN	APPROVED BY:	DATE : JUNE, 2022
DRAWN BY: RIZWAN	JOB NO.	SCALE: N,T,S
DRG. NO.		AR-02

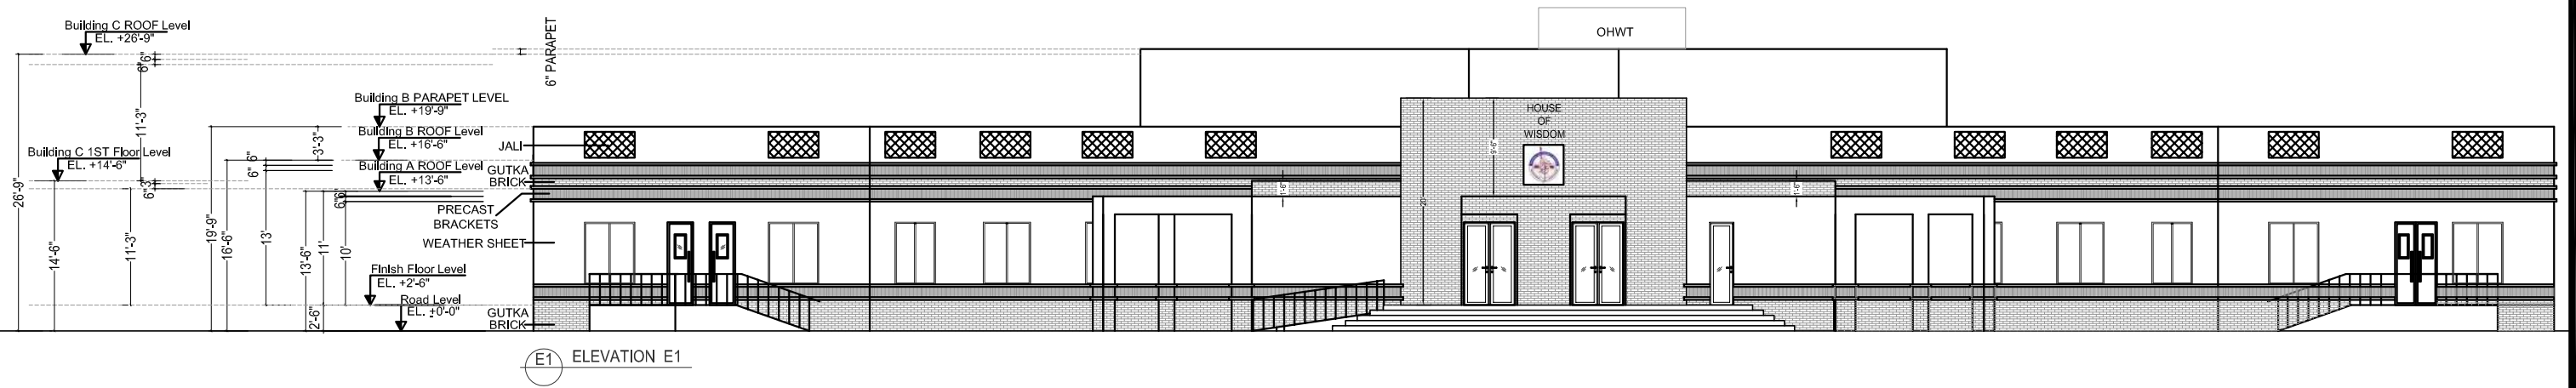

ADDITION & REVISION					
ADD./REV. NO.	DATE	DESCRIPTION	DES. BY	CHK. BY	APP. BY



NEW VISION ENGINEERING CONSULTANT
Head Office: Office No.B-6 Second Floor Masood Arcade
IJP Road Islamabad.
Ph: +92-51-4848375, Fax: +92-51-4848375
Email: newvisionec@yahoo.com
Regional Office: 287-A Street # 6, Cavalry Ground ,Lahore
Ph: +92-42-37250130

PROJECT:	"PROVISION OF MISSING FACILITIES FOR THE SHAIKH AYAZ UNIVERSITY SHIKARPUR"	
TITLE:	LIBRARY ELEVATION E-1	
CAD filename:		

CLIENT:				SHAIKH AYAZ UNIVERSITY SHIKARPUR			
DESIGNED BY:		APPROVED BY:		DATE :		JUNE, 2022	
AR,SALMAN							
DRAWN BY:		JOB NO.		SCALE:			
RIZWAN						N.T.S	
DRG. NO.				AR-03			

Figured dimensions are to be followed.

Class "A" kiln burnt brick with minimum crushing strength of 2000 PSI should be used & joint at end should be sloppy, Vertical toothed joint at corners are prohibited. A steel G-60 deformed steel should be used in beams footing slabs and water retaining structures, in columns, for all diameters.

All steel should be checked for its quality and placement DETAIL as shown in drawings.

Extra care is required for proper placement of top reinforcement at support sections and cantilevers.

Dotted bars designate top reinforcement.

Provide L- shaped end hooks for all bars at discontinuous ends in footings, walls, beams and slabs as shown in drawings.

Lap length should be followed As except specified:-

- (a) 1" $\varnothing$ = 60"
- (b) 3/4" $\varnothing$ = 45"
- (c) 5/8" $\varnothing$ = 36"
- (d) 1/2" $\varnothing$ = 30"
- (e) 3/8" $\varnothing$ = 23"

Provide 3/8" dia at 12" c/c as distribution steel if not shown in drawings.

Minimum concrete cover.

- a) Footing = 2"
- b) Slabs = 3/4"
- c) Beams = 1½"
- d) Columns = 1½"
- e) Water tank and retaining wall
i- Water/earth face or exposed to weather = 2"
ii- Other faces = 1"

All footing should be taken below the original Ground Level to achieve the minimum depth as shown in drawings. Footing should not be placed on uncompacted fill area.

All drawings should be read in conjunction with Architectural Drawings.

Contractor will co-ordinate all drawings such as architectural, structural, electrical, mechanical, water supply, drainage etc: before execution of work.

Standard ACI 318, Astm C 33 and Astm A-615 use for structural concrete

Fine modulus of fine aggregate varies from 2- 3.5mm
For concrete use 2.9- 3.2mm
For plaster use 2.2- 3.6mm

QUALITY OF CONCRETE

FOOTINGS & RETAINING WALLS.

Minimum concrete compressive strength for 6"x12" cylinder to be 3000 psi at 28 days age. Concrete Nominal Mix 1:2:4 or more rich to provide specified strength (Equivalent 6"x6"x6" cube strength 3750 psi)

Minimum concrete compressive strength for 6"x12" cylinder to be 4000 psi at 28 days age. Concrete Nominal Mix to be 1:1½:3 or more rich to provide specified strength

Minimum concrete compressive strength for 6"x12" cylinder to be 3000 psi at 28 days age. Concrete Nominal Mix to be 1:2:4 or more rich to provide specified strength (Equivalent 6"x6"x6" cube strength 3750 psi)


Use of plasticizers recommended to reduce the water cement ratio and increase workability of concrete.

All concrete mixes to be used, should be got designed & approved before execution of work.

Quality, size and gradation of aggregates (fine & course) as used during the mix design, should be strictly adhered with.

The Design is in accordance with Seismic Zone 2A.

1. ALL LAYOUT DIMENSIONS AND F.FLOOR LEVELS TO BE AS PER ARCH DRAWING.
2. PROVIDE PLINTH BEAM PB AT PLINTH LEVEL, WALL BEAMS AT SLAB LEVEL.
3. PROVIDE #2 DOUBLE-LEG TIE BARS AT 12" CENTRES AT COMMON JOINT BETWEEN WALLS AND COLUMNS. THESE BARS SHOULD PASS INTO WALLS ON EACH SIDE OF COLUMNS.

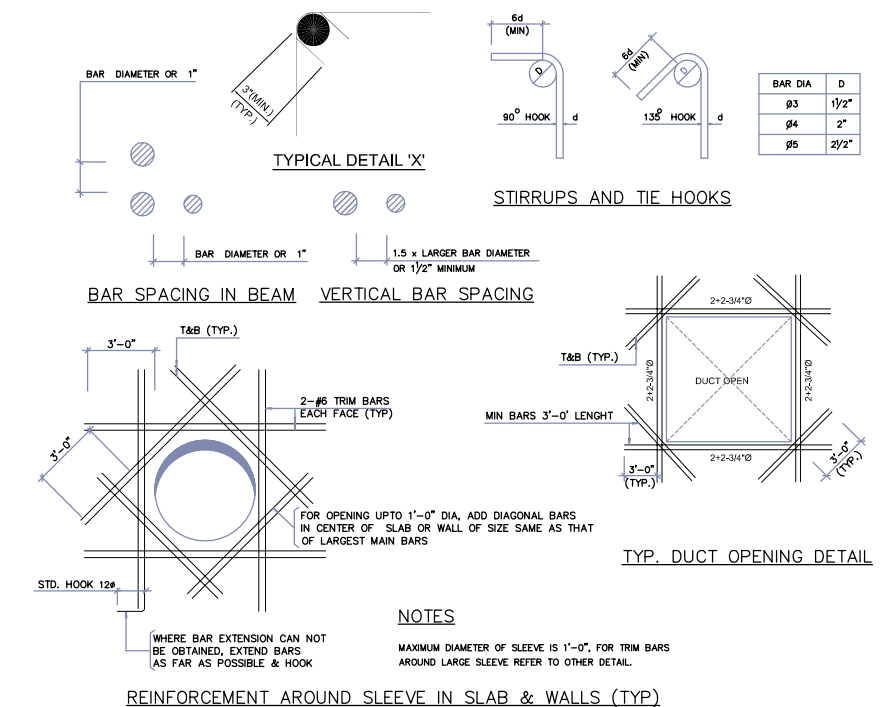

ADDITION & REVISION					
ADD, DEL, REV	DATE	DESCRIPTION	POST BY	CALC BY	APP BY



NEW VISION ENGINEERING CONSULTANT
Head Office: Office No.B-6 SECOND FLOOR Masood Arcade
IJP Road Islamabad.
Ph: +92-51-4848375, Fax: +92-51-4848375
Email: newvisionec@yahoo.com
Regional Office: 287-A Street # 6, Cavalry Ground ,Lahore
Ph: +92-42-37250130






TITLE: _____

GENERAL NOTES

CLIENT:			SHAIKH AYAZ UNIVERSITY SHIKARPUR		
DESIGNED BY: ENG. AHSAN		APPROVED BY:		DATE: JUNE, 2022	
DRAWN BY: RIZWAN		JOB NO.		SCALE: N.T.S	
DRG. NO.		ST-02			



CLIENT:		
SHAikh AYAZ UNIVERSITY SHIKARPUR		
DESIGNED BY: ENG. AHSAN	APPROVED BY:	DATE : JUNE, 2022
DRAWN BY: RIZWAN	JOB NO.	SCALE: N.T.S
DRG. NO.		ST-06

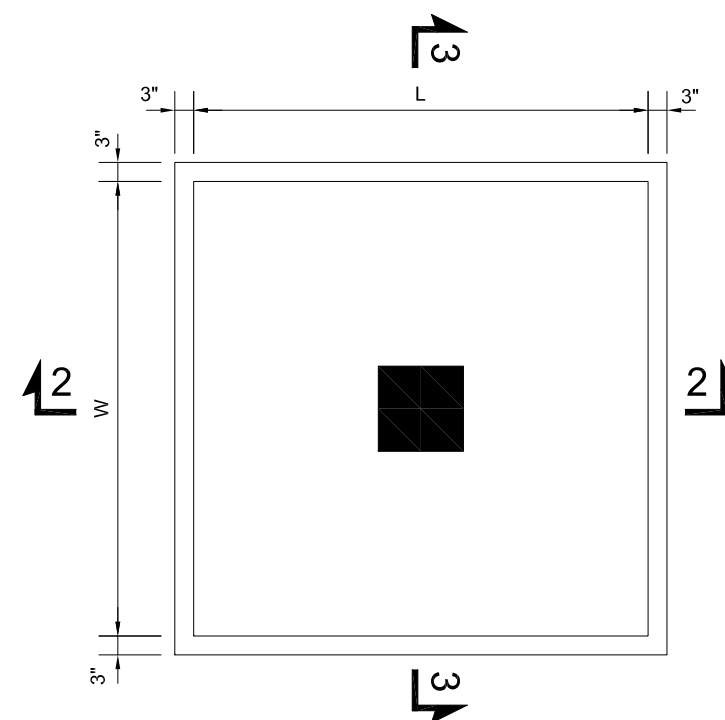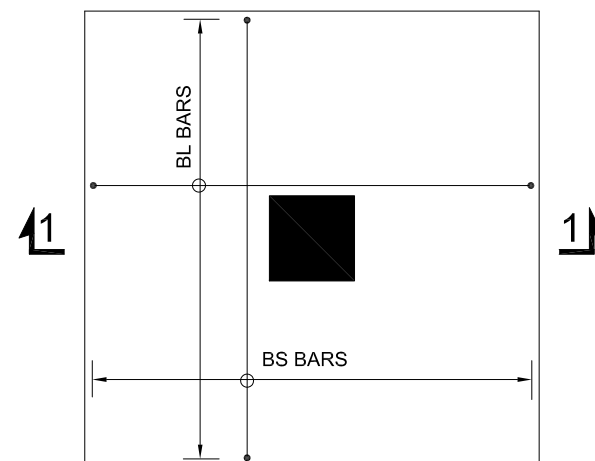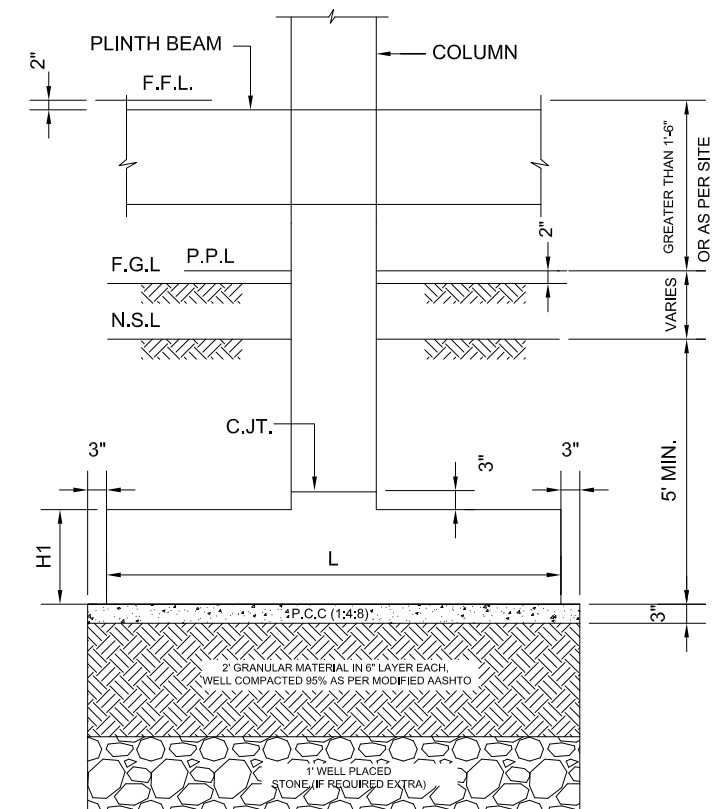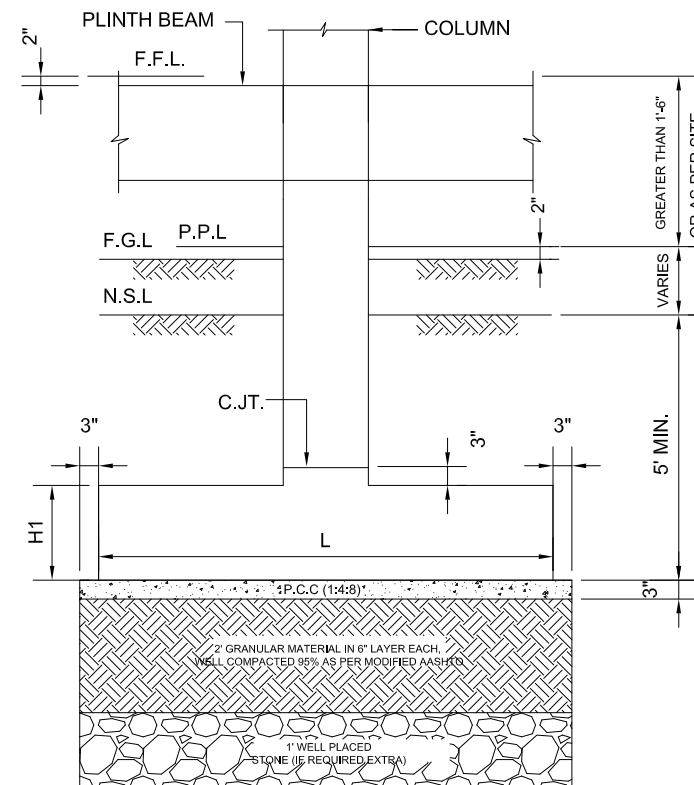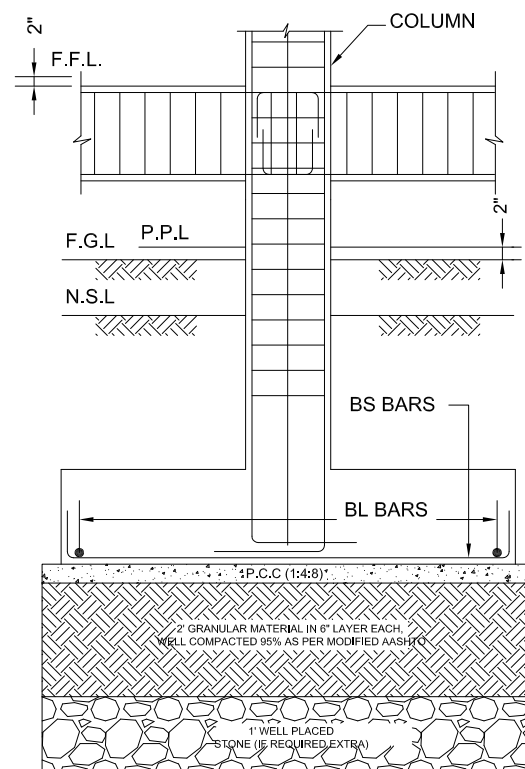

ADDITION & REVISION					
ADD/REV. NO.	DATE	DESCRIPTION	REV. BY	CHK. BY	ADD.



NEW VISION ENGINEERING CONSULTANT
Head Office: Office No.B-6 SECOND FLOOR Masood Arcade
IJP Road Islamabad.
Ph: +92-51-4848375, Fax: +92-51-4848375
Email: newvisionec@yahoo.com
Regional Office: 287-A Street # 6, Cavalry Ground ,Lahore
Ph: +92-42-37250130

PROJECT:	"PROVISION OF MISSING FACILITIES FOR THE SHAIKH AYAZ UNIVERSITY SHIKARPUR"
TITLE:	FOUNDATION SECTION

CLIENT:		
SHAIKH AYAZ UNIVERSITY SHIKARPUR		
DESIGNED BY: ENG. AHSAN	APPROVED BY:	DATE : JUNE, 2022
DRAWN BY: RIZWAN	JOB NO.	SCALE: N.T.S
DRG. NO.	ST-08	